


A-SQUARE

A-SQUARE

A-SQUARE

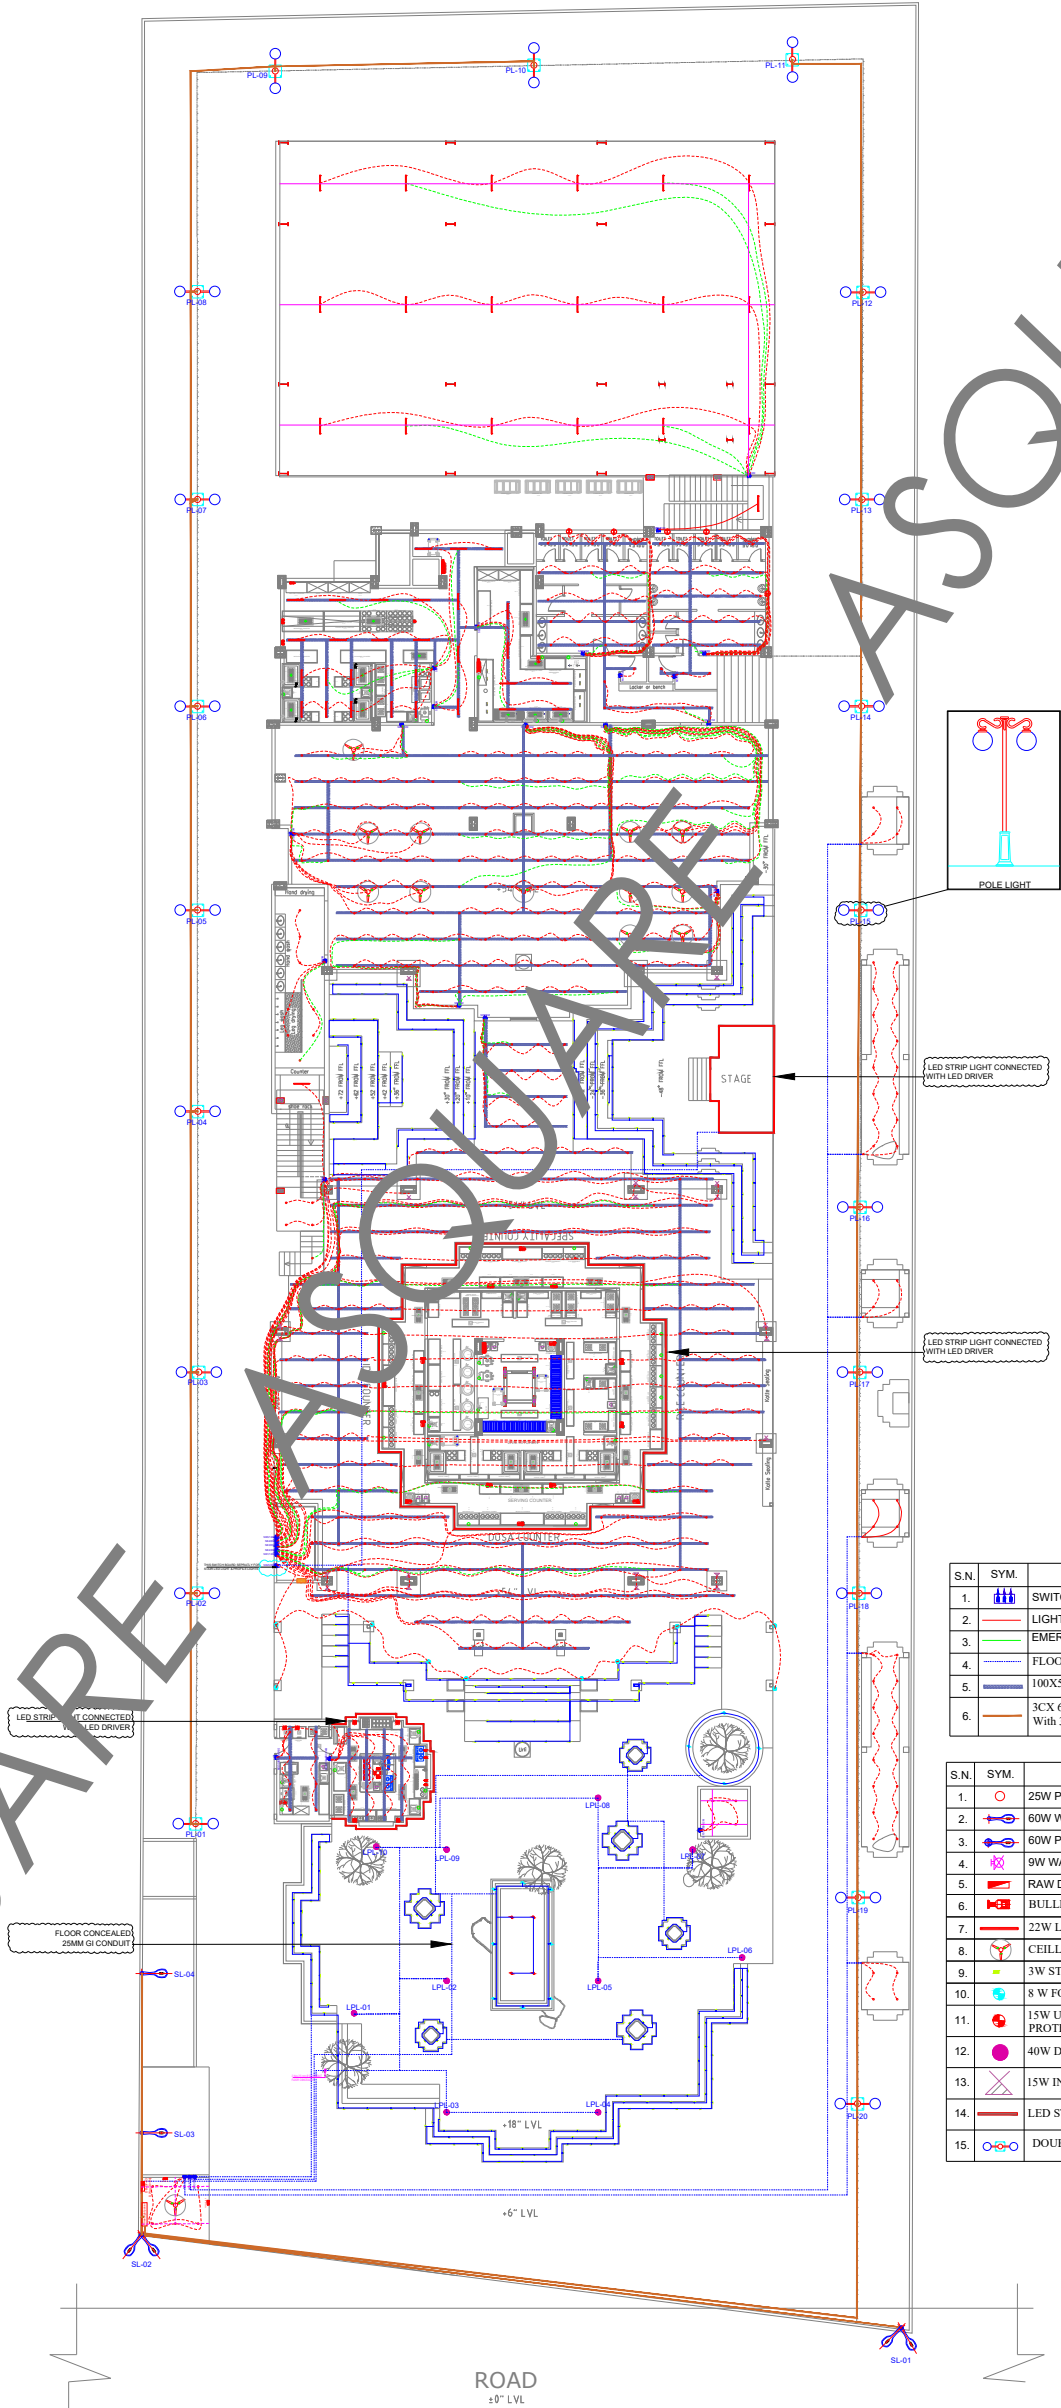

| S.N. | SYM. | DESCRIPTION                                      |
|------|------|--------------------------------------------------|
| 1.   |      | SWITCH BOARD                                     |
| 2.   |      | LIGHTING LOOPING                                 |
| 3.   |      | EMERGENCY LIGHTING LOOPING                       |
| 4.   |      | FLOOR CONCEALED 20MM GI CONDUIT                  |
| 5.   |      | 100X50MM GI CABLE TRAY                           |
| 6.   |      | 3X 60MM AL XLPE AR CABLE With 32MM Dia HDPE Pipe |

| S.N. | SYM. | DESCRIPTION                                     |
|------|------|-------------------------------------------------|
| 1.   |      | 25W PENDENT LED LIGHT                           |
| 2.   |      | 60W WALL MOUNTED LED STREET LIGHT               |
| 3.   |      | 60W POLE LED STREET LIGHT                       |
| 4.   |      | 9W WALL LIGHT/MIRROR LIGHT                      |
| 5.   |      | RAW DISTRIBUTION BOARD                          |
| 6.   |      | BULLET CAMERA WITH WATER PROOF                  |
| 7.   |      | 22W LED TUBE LIGHT                              |
| 8.   |      | CEILING FAN                                     |
| 9.   |      | 3W STAIR CASE LED LIGHT AS PER SITE LOC.        |
| 10.  |      | 8 W FOCUS LIGHT                                 |
| 11.  |      | 15W UNDER WATER LED LIGHT WITH IP 68 PROTECTION |
| 12.  |      | 40W DOUBLE ARM POLE LIGHT                       |
| 13.  |      | 15W INLAY LIGHT                                 |
| 14.  |      | LED STRIP LIGHT 6W PER METER                    |
| 15.  |      | DOUBLE ARM POLE LIGHT 60W                       |

MEP CONSULTANTS:



1st Floor, APR & MRS ARCADE,  
Vijayapura Road, Devanahalli,  
BENGALURU INDIA , 562110

A-SQUARE MEP Consultants (hereafter referred to as "A-SQUARE") retains all copyright and other proprietary rights to the drawings created by A-SQUARE. All drawings created by A-SQUARE are protected by Indian and international copyright laws. Any unauthorized reproduction, distribution, or modification of A-SQUARE's drawings is strictly prohibited. A-SQUARE reserves the right to take legal action against any unauthorized use of its drawings. A-SQUARE grants clients a limited, non-exclusive, non-transferable license to use the drawings for the specific project or purpose for which they were created. Clients may not use the drawings for any other purpose without the express written consent of A-SQUARE. Clients may not modify, reproduce, distribute, transmit, display, perform, publish, license, create derivative works from, transfer, or sell any of A-SQUARE's drawings without the prior written consent of A-SQUARE. Clients may not use any of A-SQUARE's drawings as a basis for the design or construction of any other project without the express written consent of A-SQUARE. Clients may not disclose any of A-SQUARE's drawings to any third party without the prior written consent of A-SQUARE. kindly visit our web-site, to know more.

#### GENERAL NOTES

- All dimensions are in millimeters (mm); follow written dimensions, do not scale.
- Drawings must be coordinated across all disciplines; report discrepancies before execution.
- Designs comply with NBC, ASHRAE, NEC, IPC, NFPA, and other applicable architectural & MEP standards.
- Use only the latest issued drawings; verify all dimensions and site conditions before execution.

#### VERSION CHART

| VERSION NO. | VERSION DATE |
|-------------|--------------|
| GFC         | 20-MAR-2025  |
|             |              |
|             |              |
|             |              |

ISSUED FOR:

GOOD FOR CONSTRUCTION

ARCHITECT / INTERIOR CONSULTANTS:

STUDIO  
ELEVAE

PROJECT:



Bommasandra Industrial Area, Bommasandra  
Village, Anekal TK, Bengaluru (Bangalore)  
Urban, Karnataka, Bangalore, 560099

CLIENT:

DR. VIKRAM  
Dhyan Dishes LLP

ISSUED DATE:

20-MAR-2025

DRAWN BY:

DA

CHECKED BY:

SK

APPROVED BY

AA

SHEET TITLE:


GROUND FLOOR LIGHTING POINT WIRING AND  
CABLE TREY LAYOUT

SHEET SIZE:

A3

DRAWING NO:

ASC-ELE-TRC-003

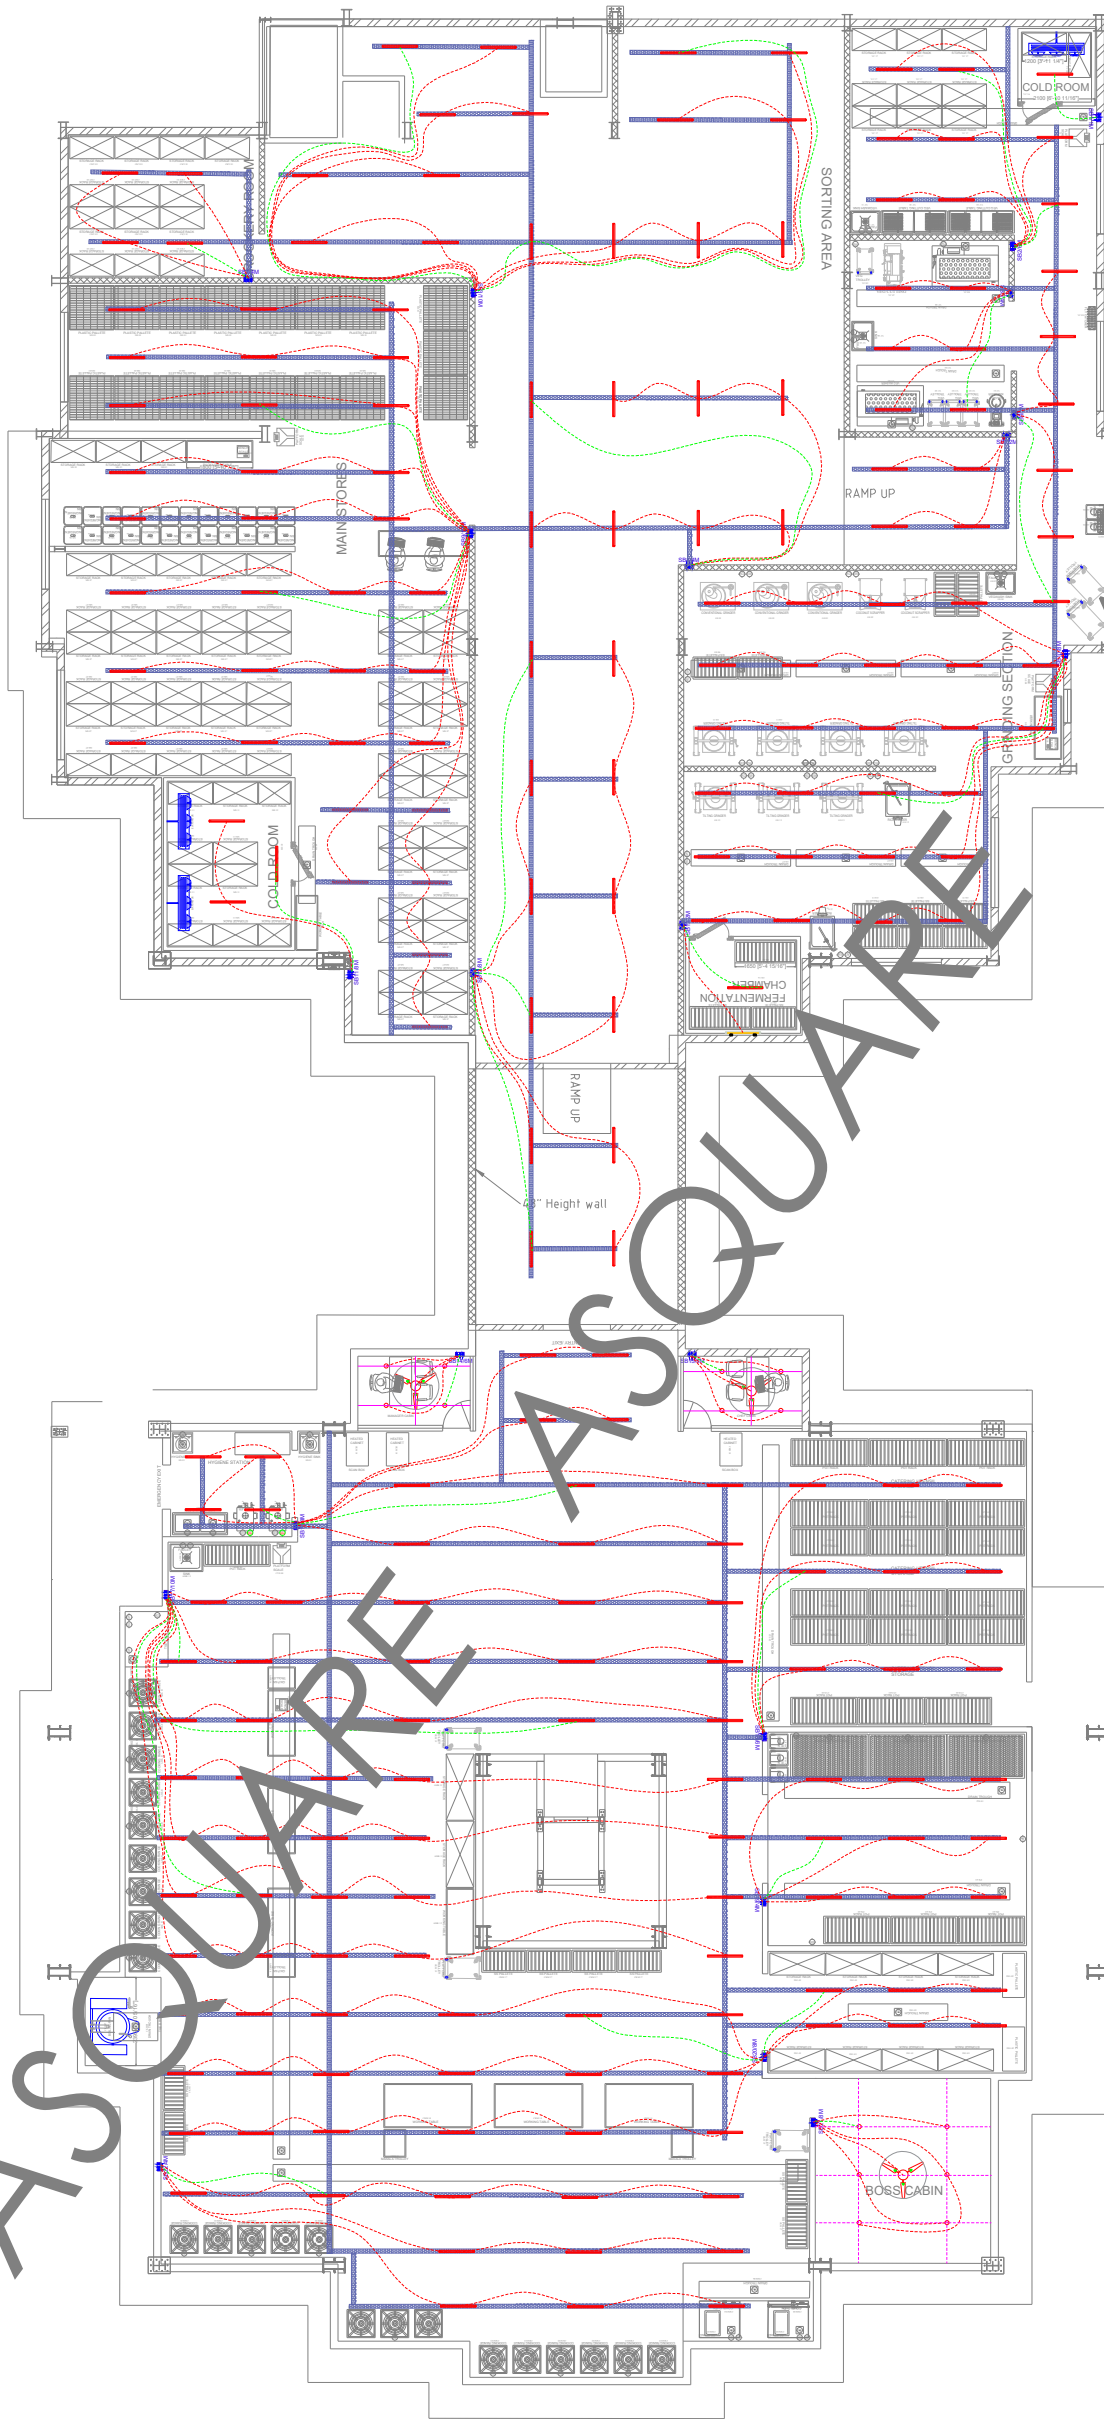

| S.N. | SYM. | DESCRIPTION                |
|------|------|----------------------------|
| 1.   |      | Switch Board               |
| 2.   |      | Lighting Looping           |
| 3.   |      | Emergency Lighting Looping |
| 4.   |      | 25MM PVC Conduit           |
| 5.   |      | 100x50mm GI Cable Tray     |

| S.N. | SYM. | DESCRIPTION                |
|------|------|----------------------------|
| 1.   |      | 20W Pendant LED Light      |
| 2.   |      | 22W LED Tube Light         |
| 3.   |      | Ceiling Fan                |
| 4.   |      | Wall Mounted Led TubeLight |
| 5.   |      | 100x50mm GI Cable Tray     |

MEP CONSULTANTS:



1st Floor, APR & MRS ARCADE,  
Vijayapura Road, Devanahalli,  
BENGALURU INDIA , 562110

A-SQUARE MEP Consultants (hereafter referred to as "A-SQUARE") retains all copyright and other proprietary rights to the drawings created by A-SQUARE. All drawings created by A-SQUARE are protected by Indian and international copyright laws. Any unauthorized reproduction, distribution, or modification of A-SQUARE's drawings is strictly prohibited. A-SQUARE reserves the right to take legal action against any unauthorized use of its drawings. A-SQUARE grants clients a limited, non-exclusive, non-transferable license to use the drawings for the specific project or purpose for which they were created. Clients may not use the drawings for any other purpose without the express written consent of A-SQUARE. Clients may not modify, reproduce, distribute, transmit, display, perform, publish, license, create derivative works from, transfer, or sell any of A-SQUARE's drawings without the prior written consent of A-SQUARE. Clients may not use any of A-SQUARE's drawings as a basis for the design or construction of any other project without the express written consent of A-SQUARE. Clients may not disclose any of A-SQUARE's drawings to any third party without the prior written consent of A-SQUARE. kindly visit our web-site, to know more.

GENERAL NOTES

- All dimensions are in millimeters (mm); follow written dimensions, do not scale.
- Drawings must be coordinated across all disciplines; report discrepancies before execution.
- Designs comply with NBC, ASHRAE, NEC, IPC, NFPA, and other applicable architectural & MEP standards.
- Use only the latest issued drawings; verify all dimensions and site conditions before execution.

VERSION CHART

| VERSION NO. | VERSION DATE |
|-------------|--------------|
| GFC         | 20-MAR-2025  |
|             |              |
|             |              |
|             |              |

ISSUED FOR:

GOOD FOR CONSTRUCTION

ARCHITECT / INTERIOR CONSULTANTS:

STUDIO  
ELEVATE

PROJECT:



Bommasandra Industrial Area, Bommasandra  
Village, Anekal TK, Bengaluru (Bangalore)  
Urban, Karnataka, Bangalore, 560099

CLIENT:

DR. VIKRAM  
Dhyan Dishes LLP

ISSUED DATE:

20-MAR-2025

DRAWN BY:

DA

CHECKED BY:

SK

APPROVED BY

AA

SHEET TITLE:


FIRST FLOOR LIGHTING POINT WIRING AND  
CABLE TREY LAYOUT

SHEET SIZE:

A3

DRAWING NO:

ASC-ELE-TRC-003-A

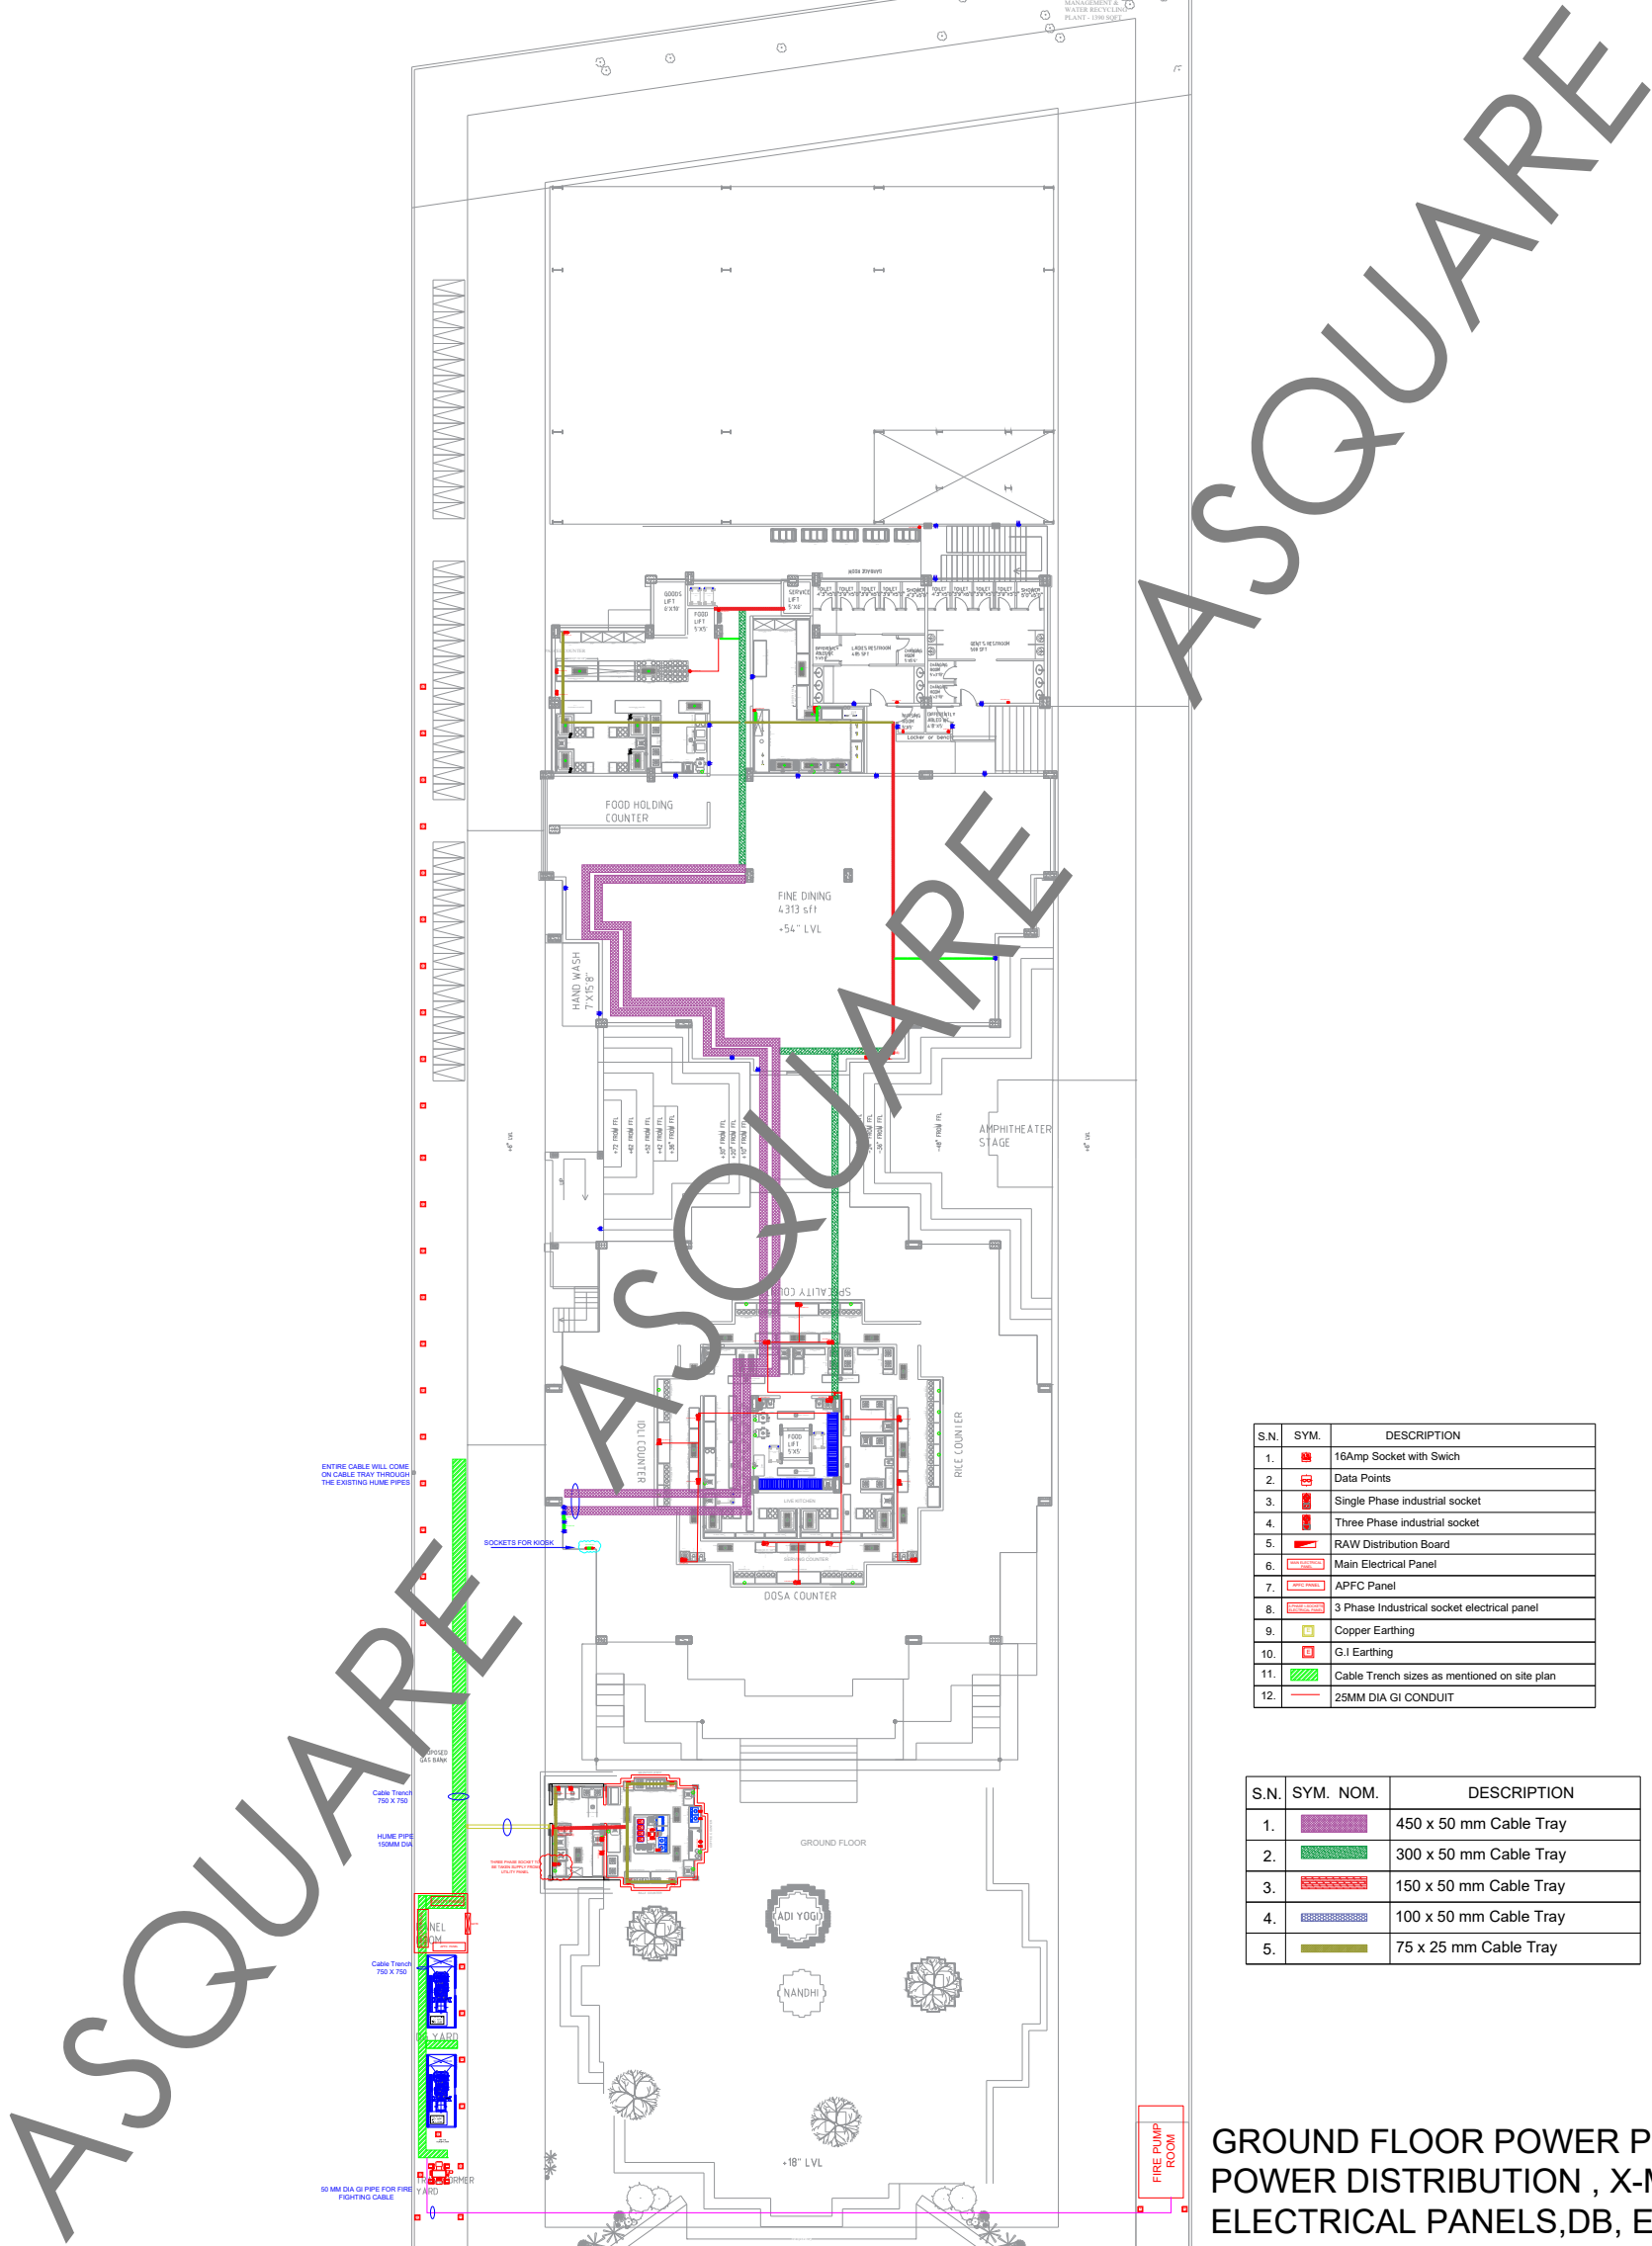

| S.N. | SYM. | DESCRIPTION                                  |
|------|------|----------------------------------------------|
| 1.   |      | 16Amp Socket with Switch                     |
| 2.   |      | Data Points                                  |
| 3.   |      | Single Phase industrial socket               |
| 4.   |      | Three Phase industrial socket                |
| 5.   |      | RAW Distribution Board                       |
| 6.   |      | Main Electrical Panel                        |
| 7.   |      | APFC Panel                                   |
| 8.   |      | 3 Phase Industrial socket electrical panel   |
| 9.   |      | Copper Earthing                              |
| 10.  |      | G.I Earthing                                 |
| 11.  |      | Cable Trench sizes as mentioned on site plan |
| 12.  |      | 25MM DIA GI CONDUIT                          |

| S.N. | SYM. | NOM. | DESCRIPTION            |
|------|------|------|------------------------|
| 1.   |      |      | 450 x 50 mm Cable Tray |
| 2.   |      |      | 300 x 50 mm Cable Tray |
| 3.   |      |      | 150 x 50 mm Cable Tray |
| 4.   |      |      | 100 x 50 mm Cable Tray |
| 5.   |      |      | 75 x 25 mm Cable Tray  |

GROUND FLOOR POWER POINT & POWER DISTRIBUTION , X-MER ,DG, ELECTRICAL PANELS,DB, EARTHINGS, CABLE TRENCH & CABLE TRAY LAYOUT

MEP CONSULTANTS:



1st Floor,APR & MRS ARCADE,  
Vijayapura Road,Devanahalli,  
BENGALURU INDIA , 562110

A-SQUARE MEP Consultants (hereafter referred to as "A-SQUARE") retains all copyright and other proprietary rights to the drawings created by A-SQUARE. All drawings created by A-SQUARE are protected by Indian and international copyright laws. Any unauthorized reproduction, distribution, or modification of A-SQUARE's drawings is strictly prohibited. A-SQUARE reserves the right to take legal action against any unauthorized use of its drawings. A-SQUARE grants clients a limited, non-exclusive, non-transferable license to use the drawings for the specific project or purpose for which they were created. Clients may not use the drawings for any other purpose without the express written consent of A-SQUARE. Clients may not modify, reproduce, distribute, transmit, display, perform, publish, license, create derivative works from, transfer, or sell any of A-SQUARE's drawings without the prior written consent of A-SQUARE. Clients may not use any of A-SQUARE's drawings as a basis for the design or construction of any other project without the express written consent of A-SQUARE. Clients may not disclose any of A-SQUARE's drawings to any third party without the prior written consent of A-SQUARE. kindly visit our web-site, to know more.

GENERAL NOTES

- All dimensions are in millimeters (mm); follow written dimensions, do not scale.
- Drawings must be coordinated across all disciplines; report discrepancies before execution.
- Designs comply with NBC, ASHRAE, NEC, IPC, NFPA, and other applicable architectural & MEP standards.
- Use only the latest issued drawings; verify all dimensions and site conditions before execution.

VERSION CHART

| VERSION NO. | VERSION DATE |
|-------------|--------------|
| GFC         | 20-MAR-2025  |
|             |              |
|             |              |
|             |              |

ISSUED FOR:

GOOD FOR CONSTRUCTION

ARCHITECT / INTERIOR CONSULTANTS:



PROJECT:



Bommasandra Industrial Area, Bommasandra  
Village, Anekal TK, Bengaluru (Bangalore)  
Urban, Karnataka, Bangalore, 560099

CLIENT:

DR. VIKRAM  
Dhyan Dishes LLP

ISSUED DATE:

20-MAR-2025

DRAWN BY:

DA

CHECKED BY:

SK

APPROVED BY

AA

SHEET TITLE:

GROUND FLOOR POWER POINT & POWER  
DISTRIBUTION , X-MER ,DG, ELECTRICAL  
PANELS,DB, EARTHINGS, CABLE TRENCH CABLE  
TRAY LAYOUT


SHEET SIZE:

A3

DRAWING NO:

ASC-ELE-TRC-004



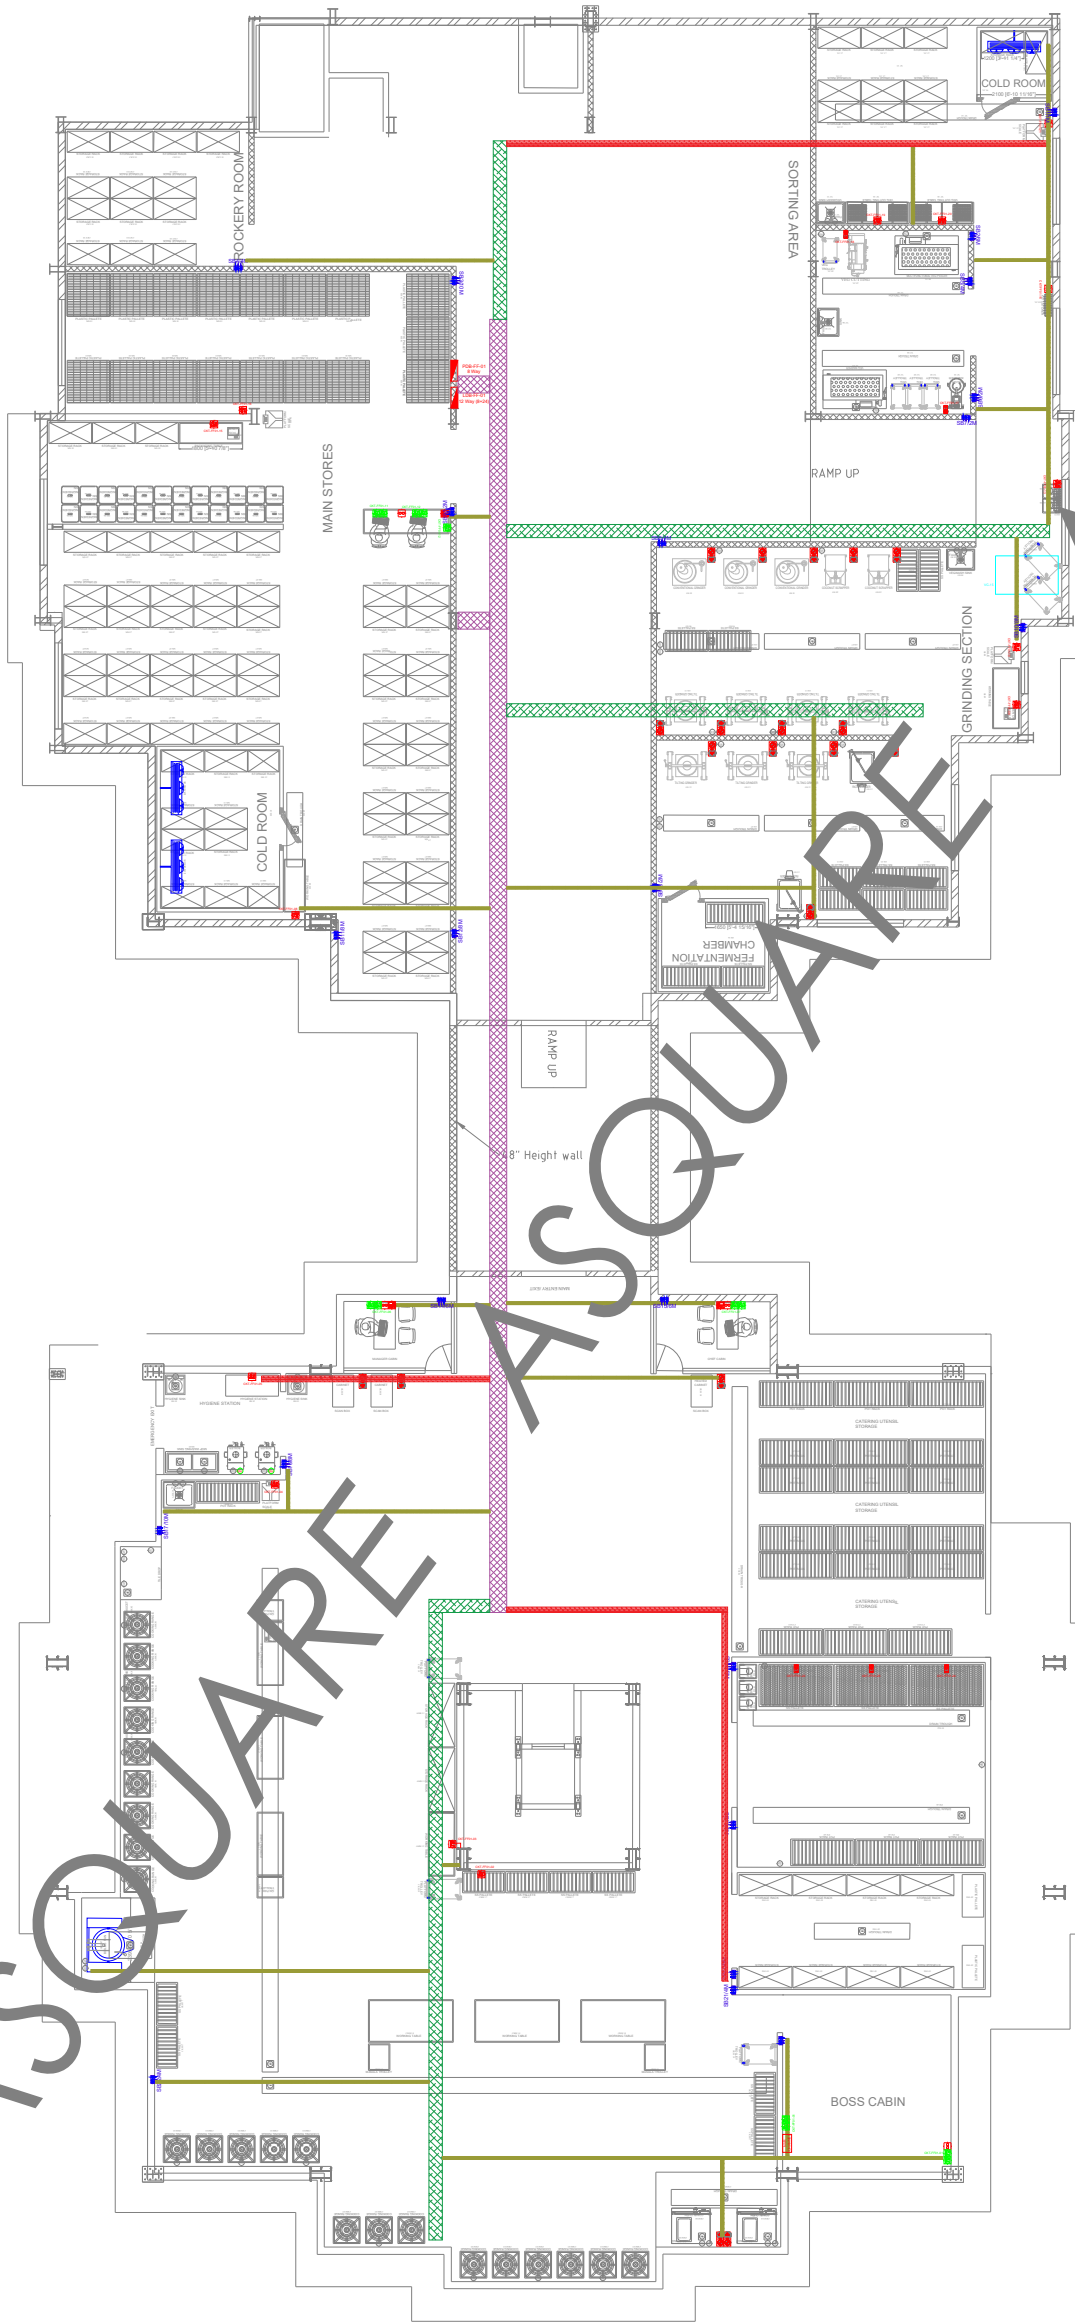

| S.N. | SYM. | DESCRIPTION                    |
|------|------|--------------------------------|
| 1.   |      | 16Amp Socket with Swich        |
| 2.   |      | Data Points                    |
| 3.   |      | Single Phase industrial socket |
| 4.   |      | Three Phase industrial socket  |
| 5.   |      | RAW Distribution Board         |

| S.N. | SYM. | NOM. | DESCRIPTION            |
|------|------|------|------------------------|
| 1.   |      |      | 450 x 50 mm Cable Tray |
| 2.   |      |      | 300 x 50 mm Cable Tray |
| 3.   |      |      | 150 x 50 mm Cable Tray |
| 4.   |      |      | 100 x 50 mm Cable Tray |
| 5.   |      |      | 75 x 25 mm Cable Tray  |

FIRST FLOOR POWER POINT  
&POWER DISTRIBUTION, DB,  
CABLE TRAY LAYOUT

MEP CONSULTANTS:



1st Floor,APR & MRS ARCADE,  
Vijayapura Road,Devanahalli,  
BENGALURU INDIA , 562110

A-SQUARE MEP Consultants (hereafter referred to as "A-SQUARE") retains all copyright and other proprietary rights to the drawings created by A-SQUARE. All drawings created by A-SQUARE are protected by Indian and international copyright laws. Any unauthorized reproduction, distribution, or modification of A-SQUARE's drawings is strictly prohibited. A-SQUARE reserves the right to take legal action against any unauthorized use of its drawings. A-SQUARE grants clients a limited, non-exclusive, non-transferable license to use the drawings for the specific project or purpose for which they were created. Clients may not use the drawings for any other purpose without the express written consent of A-SQUARE. Clients may not modify, reproduce, distribute, transmit, display, perform, publish, license, create derivative works from, transfer, or sell any of A-SQUARE's drawings without the prior written consent of A-SQUARE. Clients may not use any of A-SQUARE's drawings as a basis for the design or construction of any other project without the express written consent of A-SQUARE. Clients may not disclose any of A-SQUARE's drawings to any third party without the prior written consent of A-SQUARE. kindly visit our web-site, to know more.

GENERAL NOTES

- All dimensions are in millimeters (mm); follow written dimensions, do not scale.
- Drawings must be coordinated across all disciplines; report discrepancies before execution.
- Designs comply with NBC, ASHRAE, NEC, IPC, NFPA, and other applicable architectural & MEP standards.
- Use only the latest issued drawings; verify all dimensions and site conditions before execution.

VERSION CHART

| VERSION NO. | VERSION DATE |
|-------------|--------------|
| GFC         | 20-MAR-2025  |
|             |              |
|             |              |
|             |              |

ISSUED FOR:

GOOD FOR CONSTRUCTION

ARCHITECT / INTERIOR CONSULTANTS:



PROJECT:



Bommasandra Industrial Area, Bommasandra  
Vilage, Anekal TK, Bengaluru (Bangalore)  
Urban, Karnataka, Bangalore, 560099

CLIENT:

DR. VIKRAM  
Dhyan Dishes LLP

ISSUED DATE:

20-MAR-2025

DRAWN BY:

DA

CHECKED BY:

SK

APPROVED BY

AA

SHEET TITLE:

FIRST FLOOR POWER POINT & POWER  
DISTRIBUTION, DB, CABLE TRAY LAYOUT



SHEET SIZE:

A3

DRAWING NO:


ASC-ELE-TRC-004-A



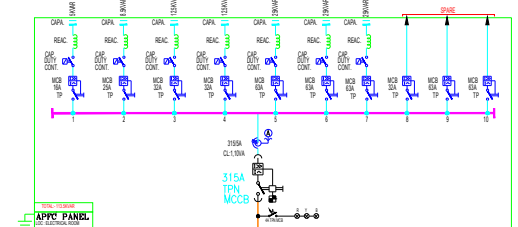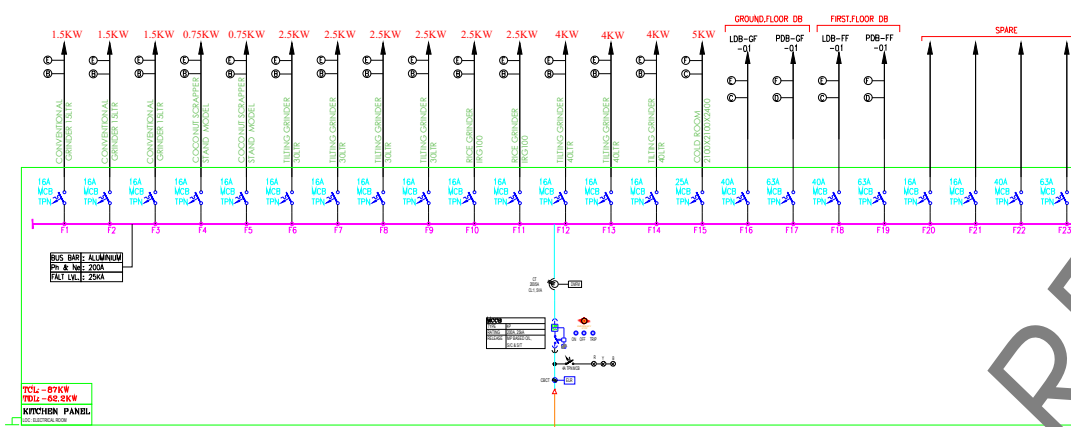

| CABLE LEGEND |                                       |
|--------------|---------------------------------------|
| Ⓐ            | 3CX6 SQMM FALT CU, MULTI STRAND CABLE |
| Ⓑ            | 4CX4 SQMM CU,XLPE,AR,CABLE            |
| Ⓒ            | 4CX6 SQMM CU,XLPE,AR,CABLE            |
| Ⓓ            | 4CX10 SQMM CU,XLPE,AR,CABLE           |
| Ⓔ            | 1CX2.5 SQMM CU,XLPE,AR,CABLE          |
| Ⓕ            | 1CX4 SQMM CU,XLPE,AR,CABLE            |
| Ⓖ            | 3.5CX50 SQMM AL,XLPE,AR,CABLE         |
| Ⓗ            | 3CX6 SQMM CU,XLPE,AR,CABLE            |
| Ⓘ            | 3CX10 SQMM CU,XLPE,AR,CABLE           |
| Ⓚ            | 3.5CX185 SQMM AL,XLPE,AR,CABLE        |
| Ⓛ            | 3CX4 SQMM AL,XLPE,AR,CABLE            |
| Ⓜ            | 3.5CX150 SQMM AL,XLPE,AR,CABLE        |

| LEGEND AND ABBREVIATIONS.                                                           |                                                                     |
|-------------------------------------------------------------------------------------|---------------------------------------------------------------------|
|  | MOULDED CASE CIRCUIT BREAKER (MCCB)                                 |
|  | CURRENT TRANSFORMER (CT) RESIN CAST                                 |
|  | MOTOR PROTECTION CIRCUIT BREAKER (MPCB)                             |
|  | VOLTMETER WITH SELECTOR SWITCH (DIGITAL)                            |
|  | EMERGENCY SWITCH                                                    |
|  | PHASE FAILURE RELAY OVER AND UNDER VOLTAGE PROTECTION RELAY ( PFR ) |
|  | MINIATURE CIRCUIT BREAKER (MCCB)                                    |
|  | INDICATING LAMP (R,Y,B)                                             |
|  | DIGITAL MULTI FUNCTION METER( V,I,R,KW etc )                        |
|  | DIRECT ONLINE STARTER                                               |
|  | AUTOMATIC TRANSFER SWITCH                                           |
|  | SURGE PROTECTION DEVICE                                             |
|  | STAR DELTA STARTER                                                  |

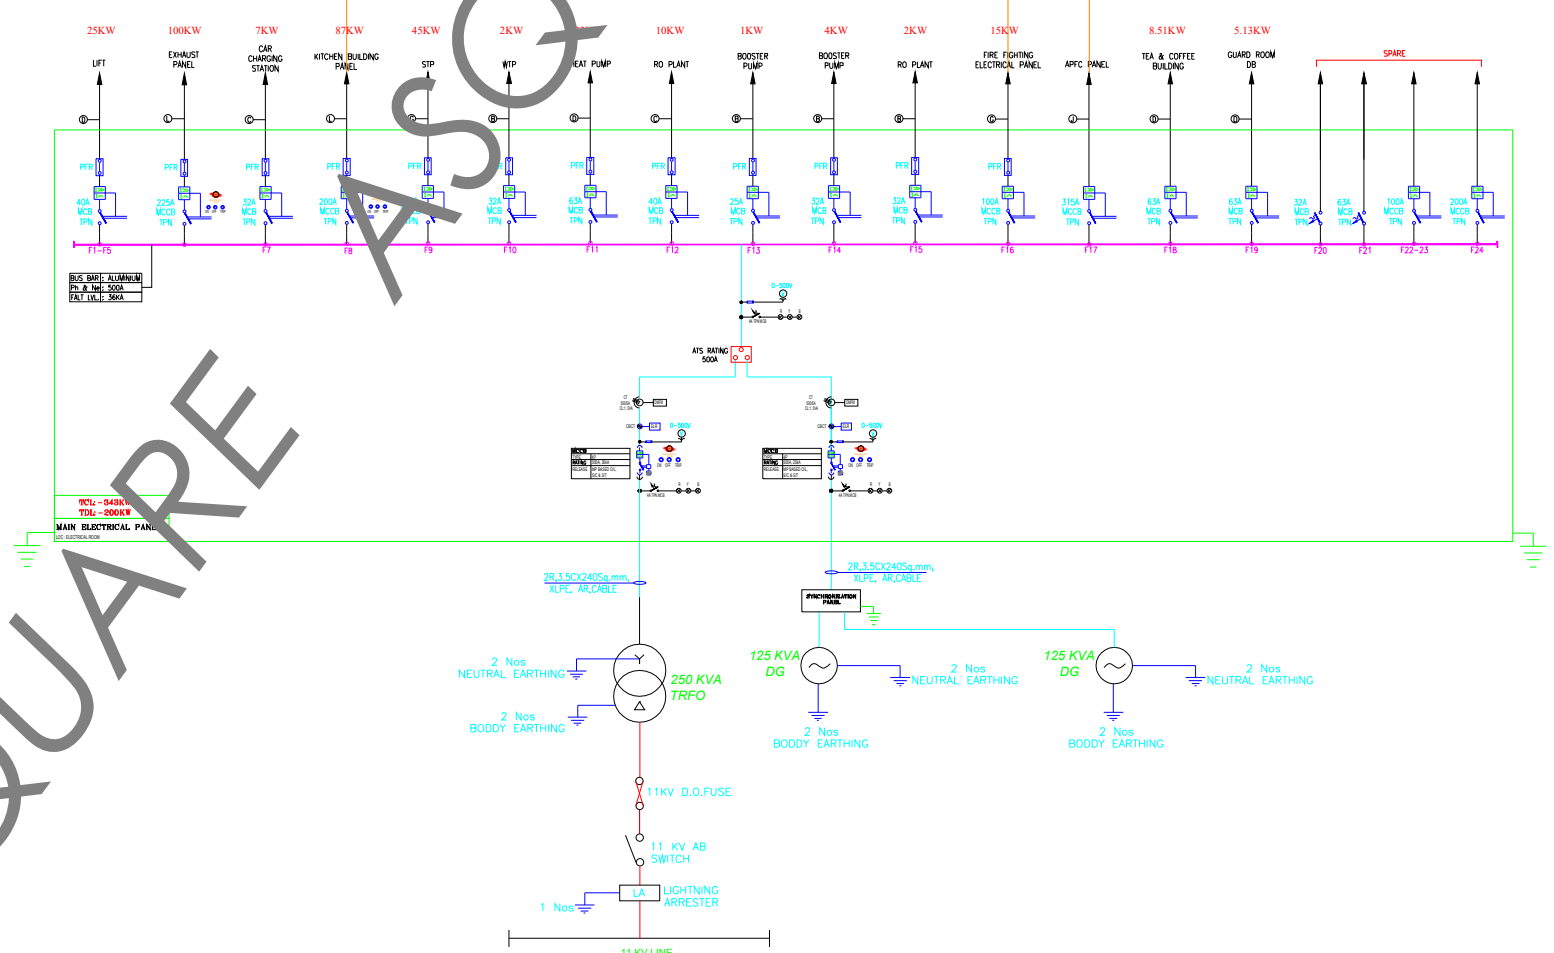

## MAIN ELECTRICAL PANEL SLD



A-SQUARE MEP Consultants (hereafter referred to as "A-SQUARE") retains all copyright and other proprietary rights to the drawings created by A-SQUARE. All drawings created by A-SQUARE are protected by Indian and international copyright laws. Any unauthorized reproduction, distribution, or modification of A-SQUARE's drawings is strictly prohibited. A-SQUARE reserves the right to take legal action against any unauthorized use of its drawings. A-SQUARE grants clients a limited, non-exclusive, non-transferable license to use the drawings for the specific project or purpose stated in the contract. This license does not extend to creating any other drawings without the express written consent of A-SQUARE. Clients may not modify, reproduce, distribute, transmit, display, perform, publish, license, create derivative works from, transfer, or sell any of A-SQUARE's drawings without the prior written consent of A-SQUARE. Clients may not use any of A-SQUARE's drawings as a basis for the design or construction of any other project without the express written consent of A-SQUARE. Clients may not disclose any of A-SQUARE's drawings to any third party without the prior written consent of A-SQUARE. kindly visit our web-site, to know more.

1. All dimensions are in millimeters (mm); follow written dimensions, do not scale.
2. Drawings must be coordinated across all disciplines; report discrepancies before execution.
3. Designs comply with NBC, ASHRAE, NEC, IPC, NFPA, and other applicable architectural & MEP standards.
4. Use only the latest issued drawings; verify all dimensions and site conditions before execution.

| VERSION CHART |              |
|---------------|--------------|
| VERSION NO.   | VERSION DATE |
| GFC           | 20-MAR-2025  |
|               |              |
|               |              |
|               |              |

STUDIO  
**ELEVATE**



THE  
RAMESHWARAM

CLIENT: **DR. VIKRAM  
Dhyan Dishes LLP**

20-MAR-2025

|             |    |
|-------------|----|
| CHECKED BY: | SK |
|-------------|----|

SHEET TITLE:

ELECTRICAL SLD

DRAWING NO:  
**ASC-ELE-TRC-002**

LDB GROUND FLOOR  
Loc. GROUND FLOOR

Ⓑ—(2x2.5Sq.mm + 1x1.5 Sq.mm) Copper Wire

8 Way  
Double Door  
TPN MCB DB

MEP CONSULTANTS:



1st Floor, APR & MRS ARCADE,  
Vijayapura Road, Devanahalli,  
BENGALURU INDIA , 562110

A-SQUARE MEP Consultants (hereafter referred to as "A-SQUARE") retains all copyright and other proprietary rights to the drawings created by A-SQUARE. All drawings created by A-SQUARE are protected by Indian and international copyright laws. Any unauthorized reproduction, distribution, or modification of A-SQUARE's drawings is strictly prohibited. A-SQUARE reserves the right to take legal action against any unauthorized use of its drawings. A-SQUARE grants clients a limited, non-exclusive, non-transferable license to use the drawings for the specific project or purpose for which they were created. Clients may not use the drawings for any other purpose without the express written consent of A-SQUARE. Clients may not modify, reproduce, distribute, transmit, display, perform, publish, license, create derivative works from, transfer, or sell any of A-SQUARE's drawings without the prior written consent of A-SQUARE. Clients may not use any of A-SQUARE's drawings as a basis for the design or construction of any other project without the express written consent of A-SQUARE. Clients may not disclose any of A-SQUARE's drawings to any third party without the prior written consent of A-SQUARE. kindly visit our web-site, to know more.

GENERAL NOTES

- All dimensions are in millimeters (mm); follow written dimensions, do not scale.
- Drawings must be coordinated across all disciplines; report discrepancies before execution.
- Designs comply with NBC, ASHRAE, NEC, IPS, and other applicable architectural & MEP standards.
- Use only the latest issued drawings; verify all dimensions and site conditions before execution.

VERSION CHART

| VERSION NO. | VERSION DATE |
|-------------|--------------|
| GFC         | 20-MAR-2025  |
|             |              |
|             |              |
|             |              |
|             |              |

ARCHITECT / INTERIOR CONSULTANTS:



PROJECT:



Bommasandra Industrial Area, Bommasandra Village, Anekal TK,  
Bengaluru (Bangalore) Urban, Karnataka, Bangalore, 560099

CLIENT:

DR. VIKRAM  
Dhyan Dishes LLP

ISSUED FOR:

GOOD FOR CONSTRUCTION

ISSUED DATE:

20-MAR-2025

DRAWN BY:

DA

CHECKED BY:

SK

APPROVED BY

AA

SHEET TITLE:

GROUND FLOOR LIGHTING  
DISTRIBUTION BOARD  
SLD

SHEET SIZE:


A3

DRAWING NO:

ASC-ELE-TRC-002-A

SUPPLY FROM  
KITCHEN PANEL

40A FP  
RCBO  
30mA

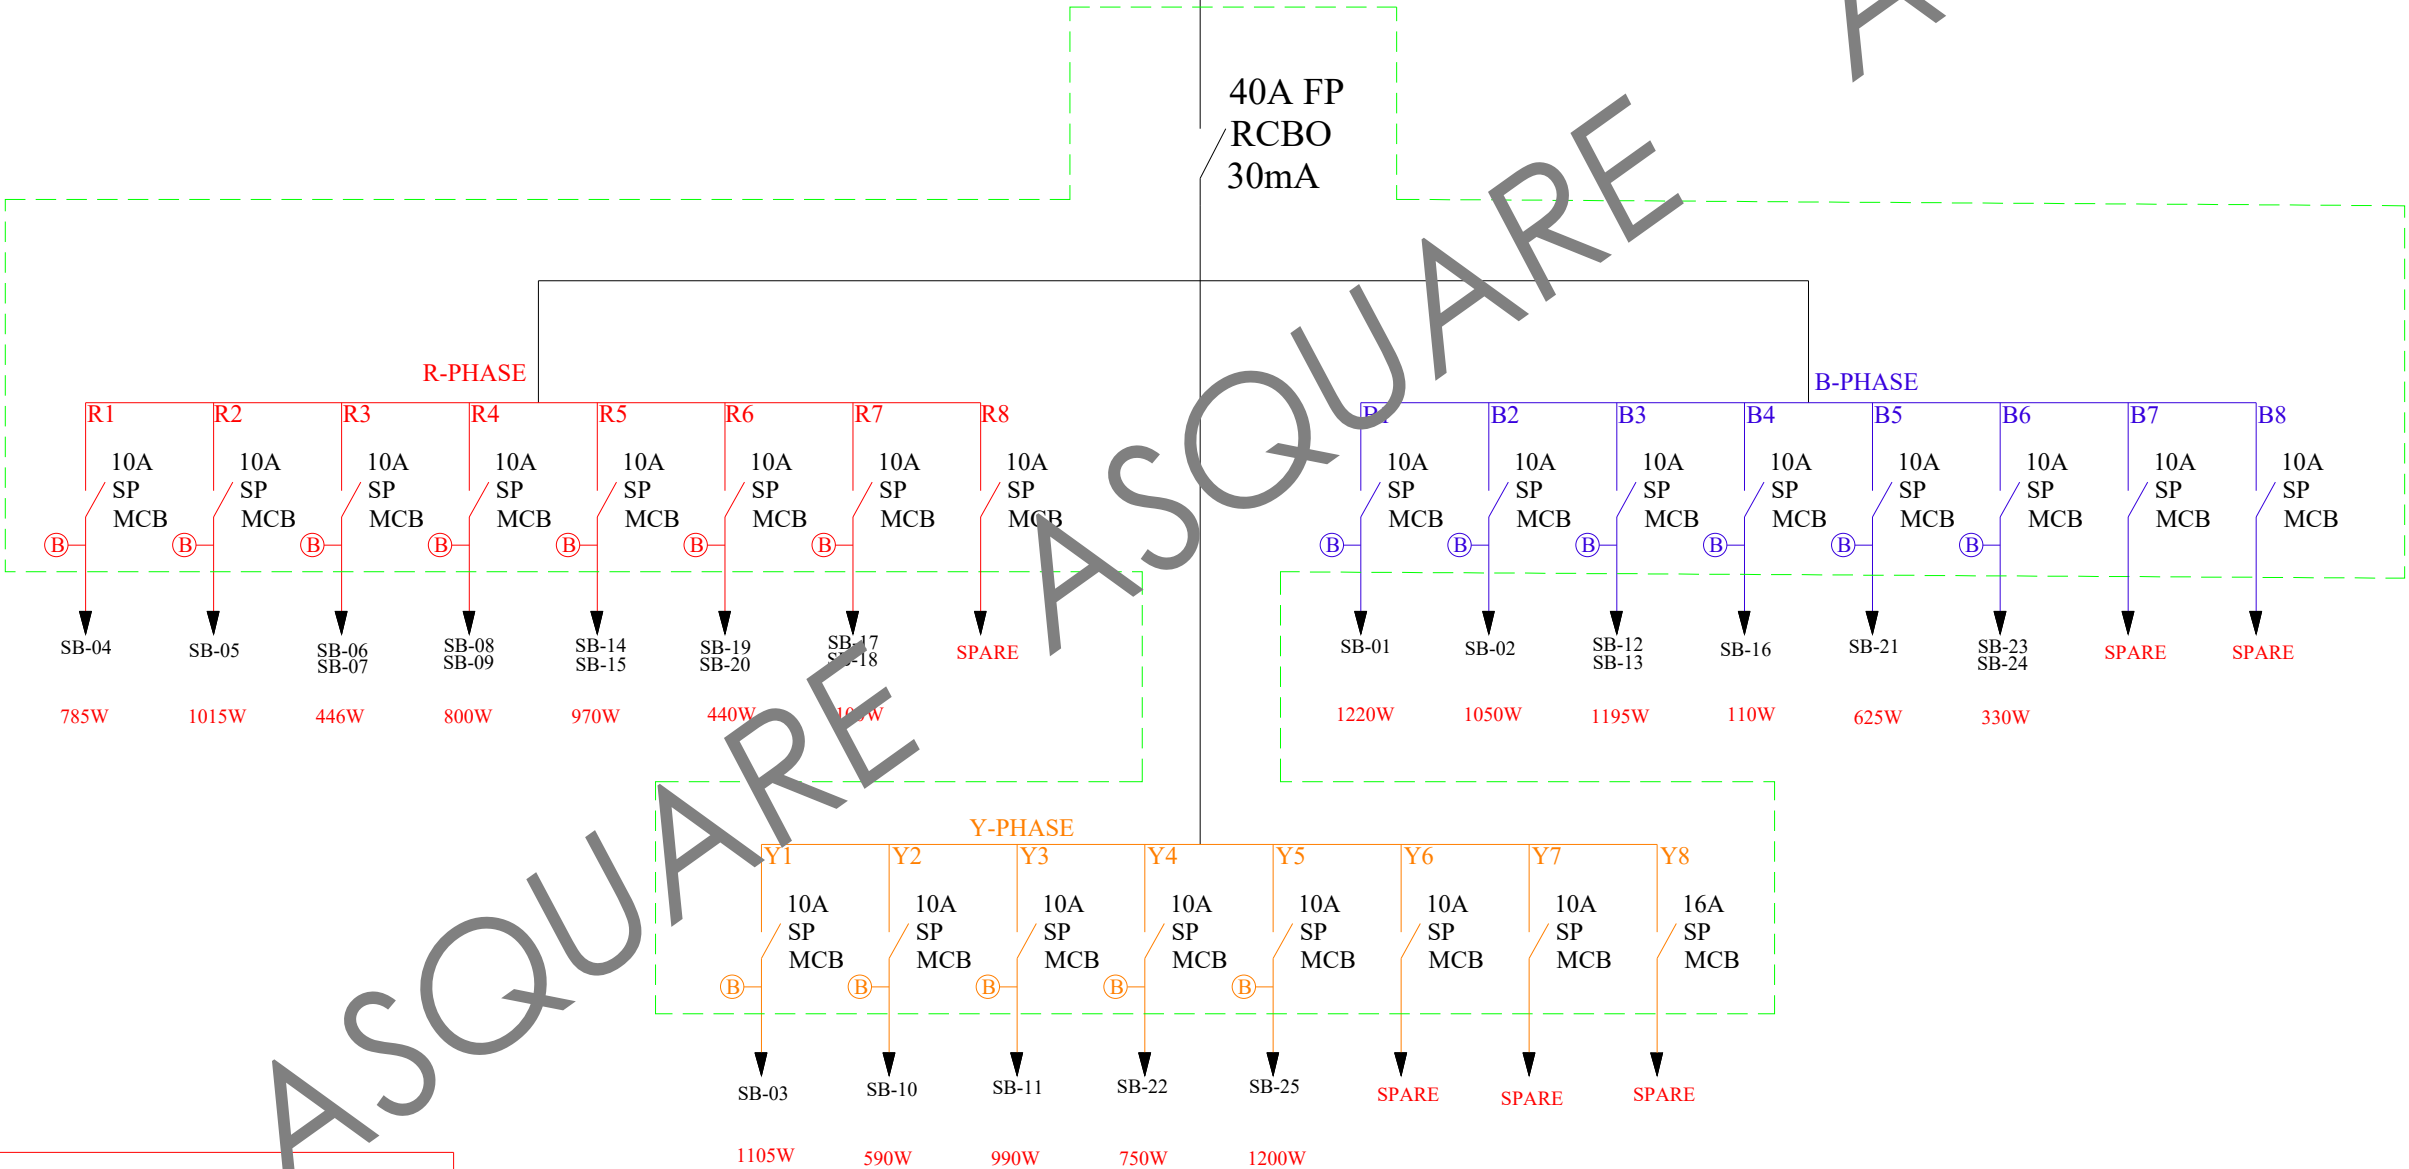

R-PHASE:- 4.55 KW

Y-PHASE:- 4.63 KW

B-PHASE:- 4.53KW

T.C.L :- 13.721 KW

T.D.L :- 10.977 KW

LDB FIRST FLOOR  
Loc. FIRST FLOOR

Ⓑ—(2x2.5Sq.mm + 1x1.5 Sq.mm) Copper Wire

6 Way  
Double Door  
TPN MCB DB

SUPPLY FROM  
KITCHEN PANEL

40A FP  
RCBO  
30mA

R-PHASE

B-PHASE

Y-PHASE

R1 10A SP MCB  
R2 10A SP MCB  
R3 10A SP MCB  
R4 10A SP MCB  
R5 10A SP MCB  
R6 10A SP MCB

B1 10A SP MCB  
B2 10A SP MCB  
B3 10A SP MCB  
B4 10A SP MCB  
B5 10A SP MCB  
B6 10A SP MCB

Y1 10A SP MCB  
Y2 10A SP MCB  
Y3 10A SP MCB  
Y4 10A SP MCB  
Y5 10A SP MCB  
Y6 10A SP MCB

SB-02 131W  
SB-06 SB-07 220W  
SB-10 505W  
SB-15 135W  
SB-20 505W  
SB-21 160W

SB-03 285W  
SB-08 153W  
SB-09 682W  
SB-16 285W  
SB-22 241W  
SPARE

SB-04 SB-05 175W  
SB-11 SB-12 SB-13 305W  
SB-14 135W  
SB-17 703W  
SB-18 175W  
SB-19 175W

R-PHASE:- 1.65 KW

Y-PHASE:- 1.66 KW

B-PHASE:- 1.64KW

T.C.L :- 4.970KW

T.D.L :- 3.976KW

MEP CONSULTANTS:



1st Floor, APR & MRS ARCADE,  
Vijayapura Road, Devanahalli,  
BENGALURU INDIA , 562110

A-SQUARE MEP Consultants (hereafter referred to as "A-SQUARE") retains all copyright and other proprietary rights to the drawings created by A-SQUARE. All drawings created by A-SQUARE are protected by Indian and international copyright laws. Any unauthorized reproduction, distribution, or modification of A-SQUARE's drawings is strictly prohibited. A-SQUARE reserves the right to take legal action against any unauthorized use of its drawings. A-SQUARE grants clients a limited, non-exclusive, non-transferable license to use the drawings for the specific project or purpose for which they were created. Clients may not use the drawings for any other purpose without the express written consent of A-SQUARE. Clients may not modify, reproduce, distribute, transmit, display, perform, publish, license, create derivative works from, transfer, or sell any of A-SQUARE's drawings without the prior written consent of A-SQUARE. Clients may not use any of A-SQUARE's drawings as a basis for the design or construction of any other project without the express written consent of A-SQUARE. Clients may not disclose any of A-SQUARE's drawings to any third party without the prior written consent of A-SQUARE. kindly visit our web-site, to know more.

GENERAL NOTES

- All dimensions are in millimeters (mm); follow written dimensions, do not scale.
- Drawings must be coordinated across all disciplines; report discrepancies before execution.
- Designs comply with NBC, ASHRAE, NEC, IPS, and other applicable architectural & MEP standards.
- Use only the latest issued drawings; verify all dimensions and site conditions before execution.

VERSION CHART

| VERSION NO. | VERSION DATE |
|-------------|--------------|
| GFC         | 20-MAR-2025  |
|             |              |
|             |              |
|             |              |
|             |              |

ARCHITECT / INTERIOR CONSULTANTS:

STUDIO  
ELEVATE

PROJECT:



Bommasandra Industrial Area, Bommasandra Village, Anekal TK,  
Bengaluru (Bangalore) Urban, Karnataka, Bangalore, 560099

CLIENT:

DR. VIKRAM  
Dhyan Dishes LLP

ISSUED FOR:

GOOD FOR CONSTRUCTION

ISSUED DATE:

20-MAR-2025

DRAWN BY:

DA

CHECKED BY:

SK

APPROVED BY

AA

SHEET TITLE:

FIRST FLOOR LIGHTING  
DISTRIBUTION BOARD  
SLD

SHEET SIZE:

A3

DRAWING NO:

ASC-ELE-TRC-002-B



UPS LDB&PDB  
Loc.LIVING AREA

Ⓑ-(2x2.5Sq.mm + 1x1.5 Sq.mm) Copper Wire  
Ⓐ-(2x4Sq.mm + 2x1.5 Sq.mm) Copper Wire

16 Way  
Double Door  
SPN MCB DB

MEP CONSULTANTS:



1st Floor,APR & MRS ARCADE,  
Vijayapura Road,Devanahalli,  
BENGALURU INDIA , 562110

A-SQUARE MEP Consultants (hereafter referred to as "A-SQUARE") retains all copyright and other proprietary rights to the drawings created by A-SQUARE. All drawings created by A-SQUARE are protected by Indian and international copyright laws. Any unauthorized reproduction, distribution, or modification of A-SQUARE's drawings is strictly prohibited. A-SQUARE reserves the right to take legal action against any unauthorized use of its drawings. A-SQUARE grants clients a limited, non-exclusive, non-transferable license to use the drawings for the specific project or purpose for which they were created. Clients may not use the drawings for any other purpose without the express written consent of A-SQUARE. Clients may not modify, reproduce, distribute, transmit, display, perform, publish, license, create derivative works from, transfer, or sell any of A-SQUARE's drawings without the prior written consent of A-SQUARE. Clients may not use any of A-SQUARE's drawings as a basis for the design or construction of any other project without the express written consent of A-SQUARE. Clients may not disclose any of A-SQUARE's drawings to any third party without the prior written consent of A-SQUARE. kindly visit our web-site, to know more.

GENERAL NOTES

- All dimensions are in millimeters (mm); follow written dimensions, do not scale.
- Drawings must be coordinated across all disciplines; report discrepancies before execution.
- Designs comply with NBC, ASHRAE, NEC, IPS, and other applicable architectural & MEP standards.
- Use only the latest issued drawings; verify all dimensions and site conditions before execution.

VERSION CHART

| VERSION NO. | VERSION DATE |
|-------------|--------------|
| GFC         | 20-MAR-2025  |
|             |              |
|             |              |
|             |              |
|             |              |

ARCHITECT / INTERIOR CONSULTANTS:



PROJECT:



Bommasandra Industrial Area, Bommasandra Village, Anekal TK,  
Bengaluru (Bangalore) Urban, Karnataka, Bangalore, 560099

CLIENT:

DR. VIKRAM  
Dhyan Dishes LLP

ISSUED FOR:

GOOD FOR CONSTRUCTION

ISSUED DATE:

20-MAR-2025

DRAWN BY:

DA

CHECKED BY:

SK

APPROVED BY

AA

SHEET TITLE:

UPS POWER & LIGHTING  
DISTRIBUTION BOARD  
SLD

SHEET SIZE:

A3

DRAWING NO:

ASC-ELE-TRC-002-C


SUPPLY FROM  
GROUND FLOOR PDB

UPS  
5 KVA

40A DP  
MCB

ENCLOSURE

40A DP  
RCBO  
100mA

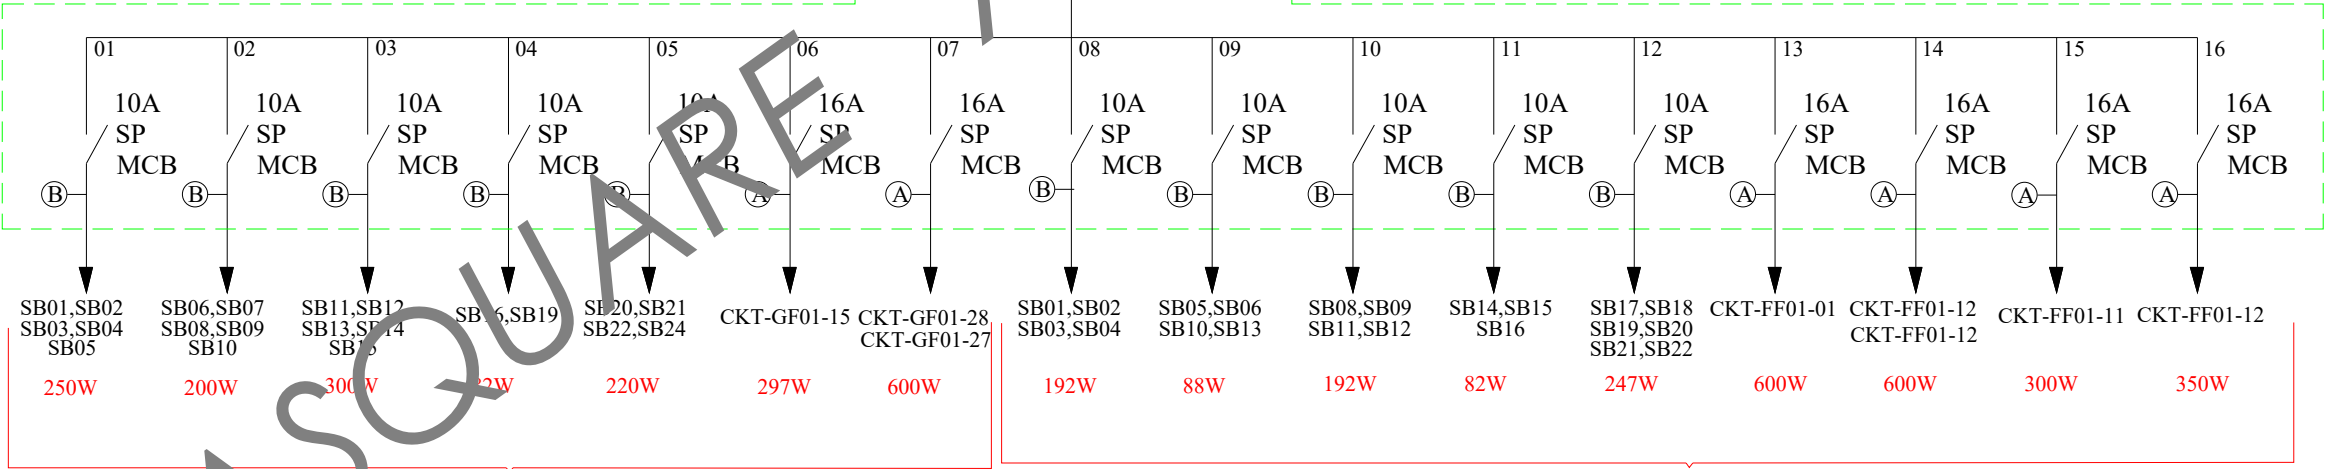

GROUND FLOOR

FIRST FLOOR

T.C.L :- 4.60KW

T.D.L :- 3.50 KW

PDB GROUND FLOOR-01  
Loc. GROUND FLOOR

Ⓐ-(2x4Sq.mm + 1x2.5 Sq.mm) Copper Wire

12 Way  
Double Door  
TPN MCB DB

MEP CONSULTANTS:



1st Floor,APR & MRS ARCADE,  
Vijayapura Road,Devanahalli,  
BENGALURU INDIA , 562110

A-SQUARE MEP Consultants (hereafter referred to as "A-SQUARE") retains all copyright and other proprietary rights to the drawings created by A-SQUARE. All drawings created by A-SQUARE are protected by Indian and international copyright laws. Any unauthorized reproduction, distribution, or modification of A-SQUARE's drawings is strictly prohibited. A-SQUARE reserves the right to take legal action against any unauthorized use of its drawings. A-SQUARE grants clients a limited, non-exclusive, non-transferable license to use the drawings for the specific project or purpose for which they were created. Clients may not use the drawings for any other purpose without the express written consent of A-SQUARE. Clients may not modify, reproduce, distribute, transmit, display, perform, publish, license, create derivative works from, transfer, or sell any of A-SQUARE's drawings without the prior written consent of A-SQUARE. Clients may not use any of A-SQUARE's drawings as a basis for the design or construction of any other project without the express written consent of A-SQUARE. Clients may not disclose any of A-SQUARE's drawings to any third party without the prior written consent of A-SQUARE. kindly visit our web-site, to know more.

GENERAL NOTES

- All dimensions are in millimeters (mm); follow written dimensions, do not scale.
- Drawings must be coordinated across all disciplines; report discrepancies before execution.
- Designs comply with NBC, ASHRAE, NEC, IPS, and other applicable architectural & MEP standards.
- Use only the latest issued drawings; verify all dimensions and site conditions before execution.

VERSION CHART

| VERSION NO. | VERSION DATE |
|-------------|--------------|
| GFC         | 20-MAR-2025  |
|             |              |
|             |              |
|             |              |
|             |              |

ARCHITECT / INTERIOR CONSULTANTS:



PROJECT:



Bommasandra Industrial Area, Bommasandra Village, Anekal TK,  
Bengaluru (Bangalore) Urban, Karnataka, Bangalore, 560099

CLIENT:

DR. VIKRAM  
Dhyan Dishes LLP

ISSUED FOR:

GOOD FOR CONSTRUCTION

ISSUED DATE:

20-MAR-2025

DRAWN BY:

DA

CHECKED BY:

SK

APPROVED BY

AA

SHEET TITLE:

GROUND FLOOR POWER  
DISTRIBUTION BOARD  
SLD

SHEET SIZE:


A3

DRAWING NO:

ASC-ELE-TRC-002-D

SUPPLY FROM  
KITCHEN PANEL

63A EP  
RCBO  
100mA

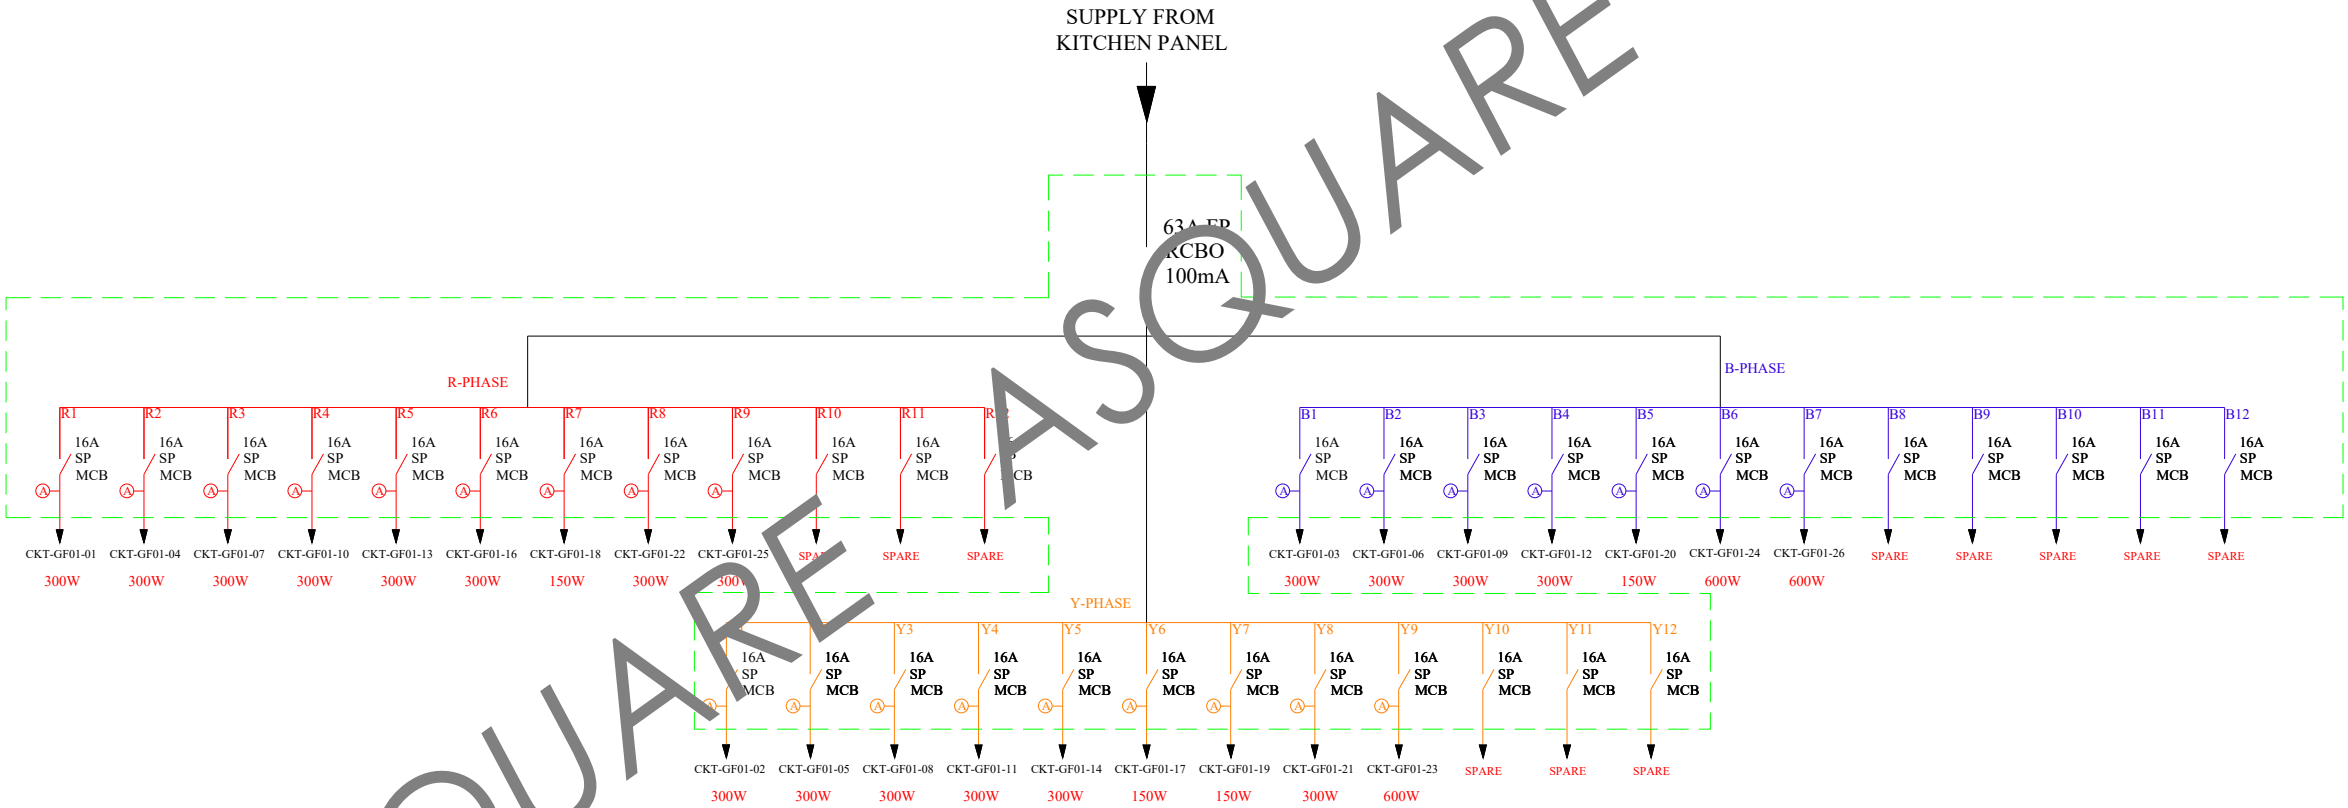

R-PHASE:- 2.55 KW

Y-PHASE:- 2.70 KW

B-PHASE:- 2.54 KW


T.C.L :- 7.80 KW

T.D.L :- 5.46 KW

PDB FIRST FLOOR-01  
Loc. FIRST FLOOR

Ⓐ (2x4Sq.mm + 1x2.5 Sq.mm) Copper Wire

8 Way  
Double Door  
TPN MCB DB

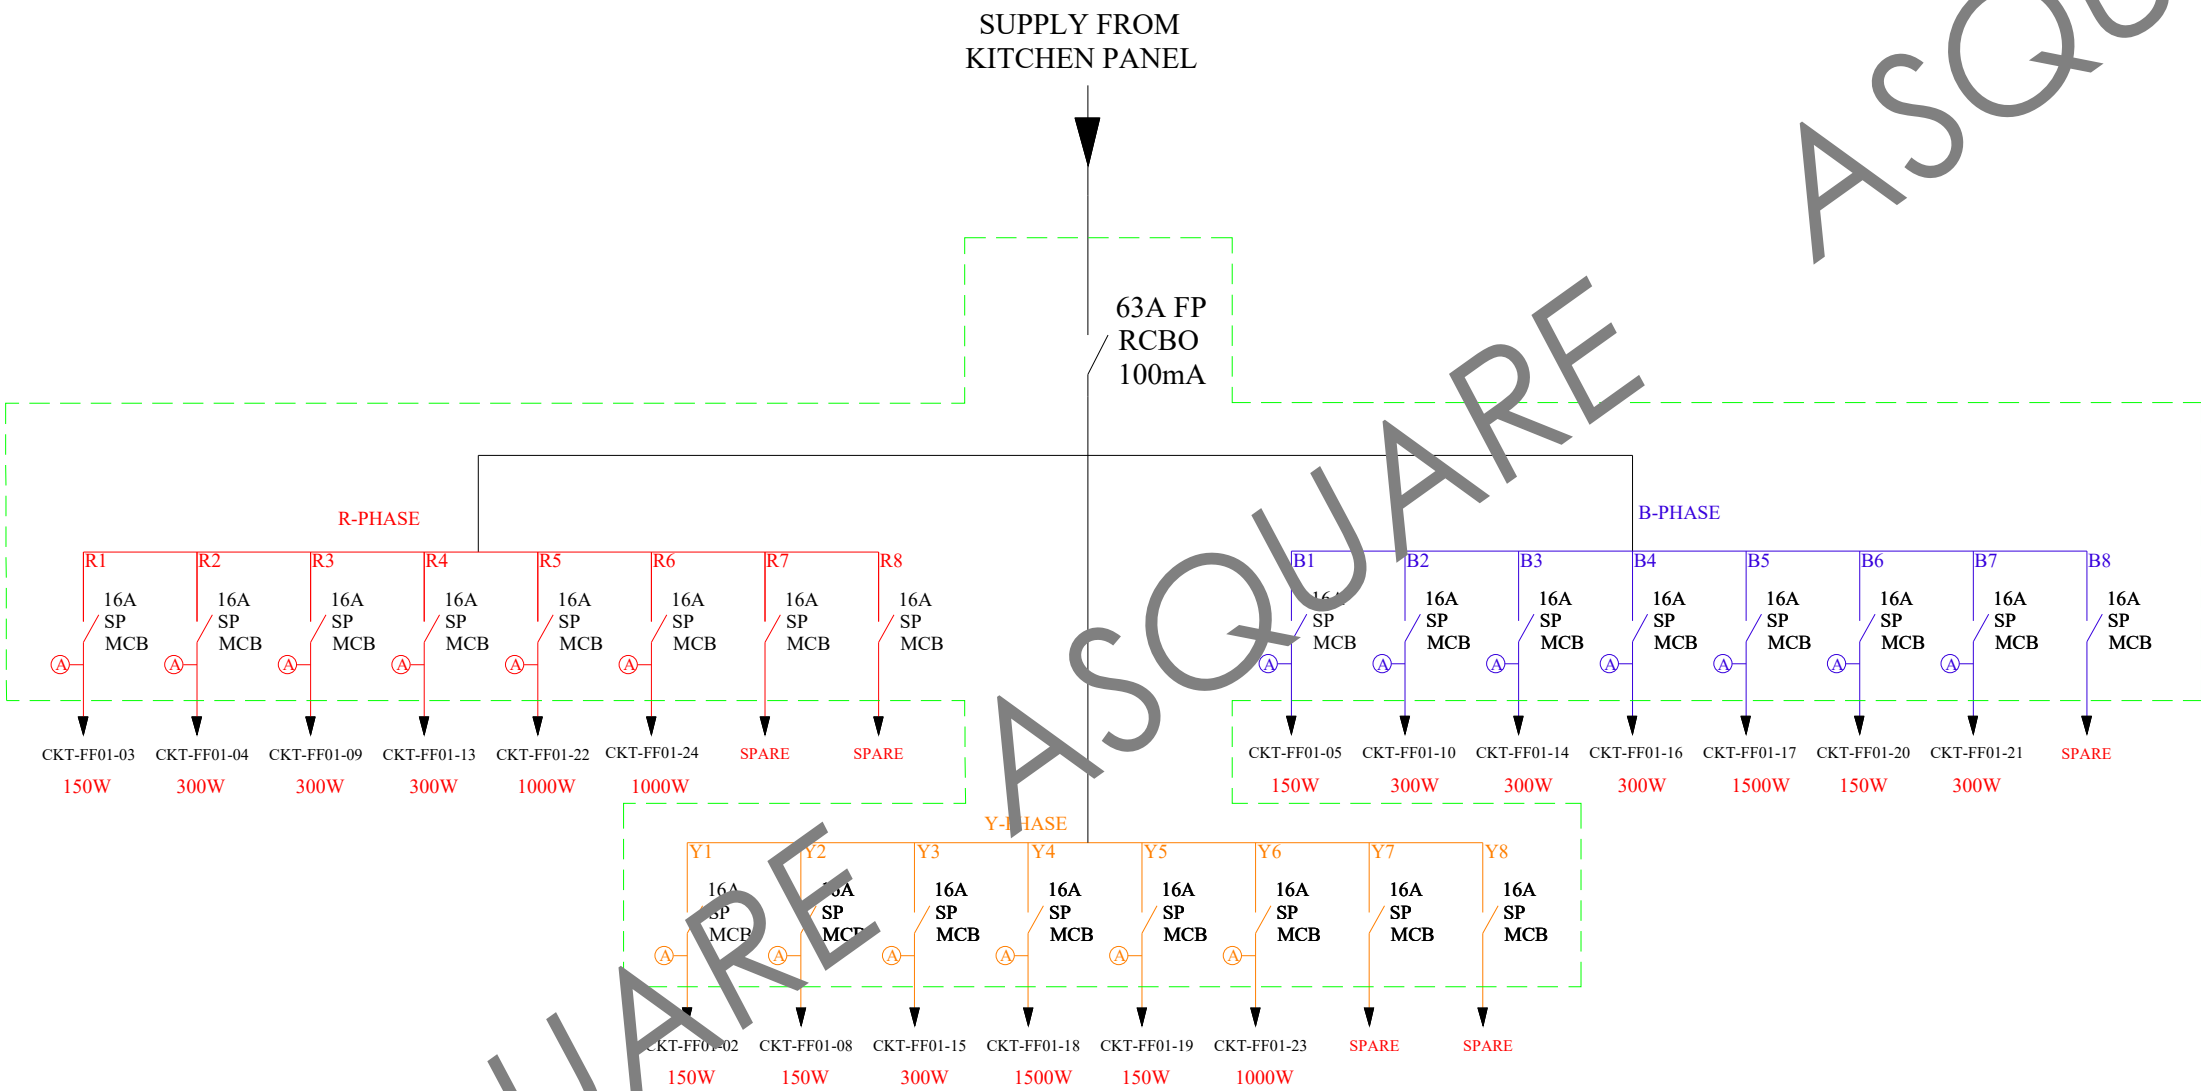

R-PHASE:- 3.05 KW  
Y-PHASE:- 3.24 KW  
B-PHASE:- 3.00 KW  
T.C.L :- 9.29 KW  
T.D.L :- 6.51 KW

MEP CONSULTANTS:



1st Floor, APR & MRS ARCADE,  
Vijayapura Road, Devanahalli,  
BENGALURU INDIA , 562110

A-SQUARE MEP Consultants (hereafter referred to as "A-SQUARE") retains all copyright and other proprietary rights to the drawings created by A-SQUARE. All drawings created by A-SQUARE are protected by Indian and international copyright laws. Any unauthorized reproduction, distribution, or modification of A-SQUARE's drawings is strictly prohibited. A-SQUARE reserves the right to take legal action against any unauthorized use of its drawings. A-SQUARE grants clients a limited, non-exclusive, non-transferable license to use the drawings for the specific project or purpose for which they were created. Clients may not use the drawings for any other purpose without the express written consent of A-SQUARE. Clients may not modify, reproduce, distribute, transmit, display, perform, publish, license, create derivative works from, transfer, or sell any of A-SQUARE's drawings without the prior written consent of A-SQUARE. Clients may not use any of A-SQUARE's drawings as a basis for the design or construction of any other project without the express written consent of A-SQUARE. Clients may not disclose any of A-SQUARE's drawings to any third party without the prior written consent of A-SQUARE. kindly visit our web-site, to know more.

GENERAL NOTES

- All dimensions are in millimeters (mm); follow written dimensions, do not scale.
- Drawings must be coordinated across all disciplines; report discrepancies before execution.
- Designs comply with NBC, ASHRAE, NEC, IPS, and other applicable architectural & MEP standards.
- Use only the latest issued drawings; verify all dimensions and site conditions before execution.

VERSION CHART

| VERSION NO. | VERSION DATE |
|-------------|--------------|
| GFC         | 20-MAR-2025  |
|             |              |
|             |              |
|             |              |
|             |              |

ARCHITECT / INTERIOR CONSULTANTS:

STUDIO  
ELEVATE

PROJECT:



Bommasandra Industrial Area, Bommasandra Village, Anekal TK,  
Bengaluru (Bangalore) Urban, Karnataka, Bangalore, 560099

CLIENT:

DR. VIKRAM  
Dhyan Dishes LLP

ISSUED FOR:

GOOD FOR CONSTRUCTION

ISSUED DATE:

20-MAR-2025

DRAWN BY:

DA

CHECKED BY:

SK

APPROVED BY

AA

SHEET TITLE:

FIRST FLOOR POWER  
DISTRIBUTION BOARD  
SLD

SHEET SIZE:

A3

DRAWING NO:

ASC-ELE-TRC-002-E

LDB&PDB GROUND FLOOR-02  
Loc.COFFEE COUNTER

- Ⓐ—(2x4Sq.mm + 1x2.5 Sq.mm) Copper Wire  
Ⓑ—(2x2.5Sq.mm + 1x1.5 Sq.mm) Copper Wire

6 Way  
SINGLE DOOR  
TPN MCB DB

MEP CONSULTANTS:



1st Floor, APR & MRS ARCADE,  
Vijayapura Road, Devanahalli,  
BENGALURU INDIA , 562110

A-SQUARE MEP Consultants (hereafter referred to as "A-SQUARE") retains all copyright and other proprietary rights to the drawings created by A-SQUARE. All drawings created by A-SQUARE are protected by Indian and international copyright laws. Any unauthorized reproduction, distribution, or modification of A-SQUARE's drawings is strictly prohibited. A-SQUARE reserves the right to take legal action against any unauthorized use of its drawings. A-SQUARE grants clients a limited, non-exclusive, non-transferable license to use the drawings for the specific project or purpose for which they were created. Clients may not use the drawings for any other purpose without the express written consent of A-SQUARE. Clients may not modify, reproduce, distribute, transmit, display, perform, publish, license, create derivative works from, transfer, or sell any of A-SQUARE's drawings without the prior written consent of A-SQUARE. Clients may not use any of A-SQUARE's drawings as a basis for the design or construction of any other project without the express written consent of A-SQUARE. Clients may not disclose any of A-SQUARE's drawings to any third party without the prior written consent of A-SQUARE. kindly visit our web-site, to know more.

GENERAL NOTES

- All dimensions are in millimeters (mm); follow written dimensions, do not scale.
- Drawings must be coordinated across all disciplines; report discrepancies before execution.
- Designs comply with NBC, ASHRAE, NEC, IPS, and other applicable architectural & MEP standards.
- Use only the latest issued drawings; verify all dimensions and site conditions before execution.

VERSION CHART

| VERSION NO. | VERSION DATE |
|-------------|--------------|
| GFC         | 20-MAR-2025  |
|             |              |
|             |              |
|             |              |
|             |              |

ARCHITECT / INTERIOR CONSULTANTS:



PROJECT:



Bommasandra Industrial Area, Bommasandra Village, Anekal TK,  
Bengaluru (Bangalore) Urban, Karnataka, Bangalore, 560099

CLIENT:

DR. VIKRAM  
Dhyan Dishes LLP

ISSUED FOR:

GOOD FOR CONSTRUCTION

ISSUED DATE:

20-MAR-2025

DRAWN BY:

DA

CHECKED BY:

SK

APPROVED BY

AA

SHEET TITLE:

GROUND FLOOR-02  
POWER&LIGHTING  
DISTRIBUTION BOARD SLD

SHEET SIZE:


A3

DRAWING NO:

ASC-ELE-TRC-002-F

SUPPLY FROM  
KITCHEN PANEL

63A FP  
RCBO  
100mA

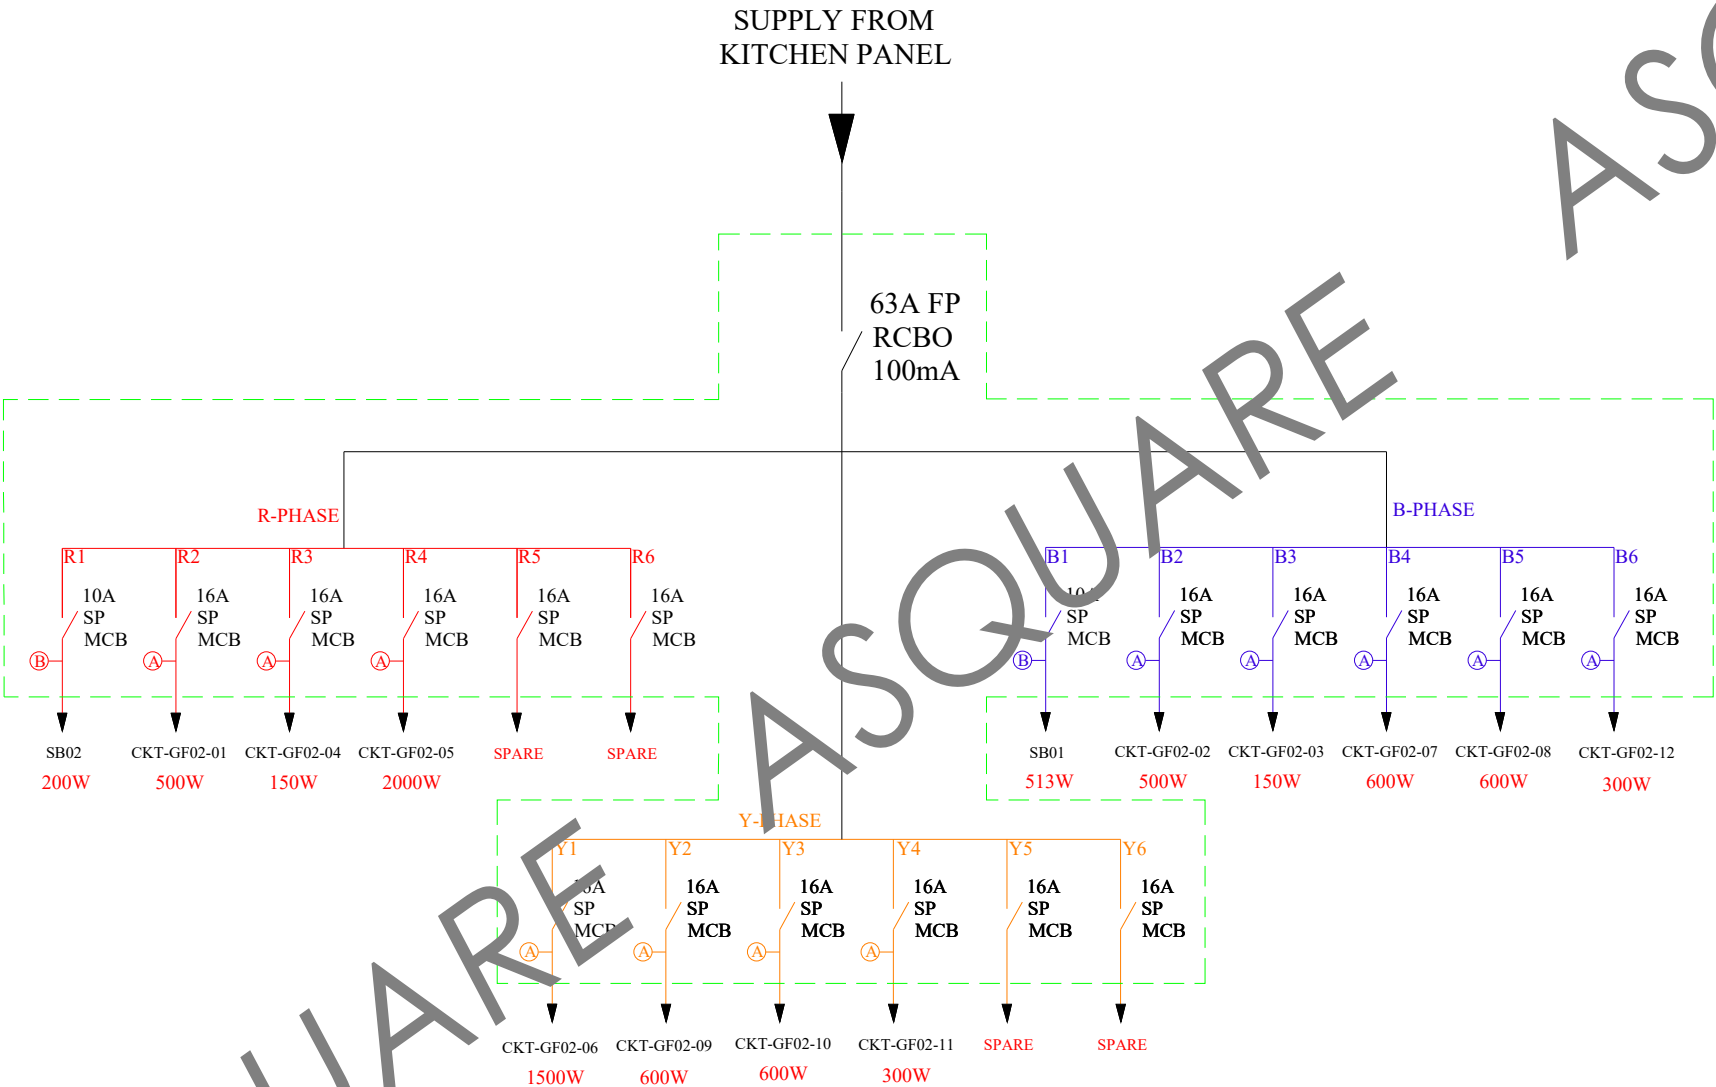

R-PHASE:- 2.85 KW  
Y-PHASE:- 3.00 KW  
B-PHASE:- 2.66 KW  
T.C.L :- 8.51 KW  
T.D.L :- 6.38 KW



LDB&PDB GROUND FLOOR-03  
Loc.SECURITY CABIN

- Ⓐ—(2x4Sq.mm + 1x2.5 Sq.mm) Copper Wire  
Ⓑ—(2x2.5Sq.mm + 1x1.5 Sq.mm) Copper Wire

6 Way  
SINGLE DOOR  
TPN MCB DB

MEP CONSULTANTS:  
  
1st Floor, APR & MRS ARCADE,  
Vijayapura Road, Devanahalli,  
BENGALURU INDIA , 562110

A-SQUARE MEP Consultants (hereafter referred to as "A-SQUARE") retains all copyright and other proprietary rights to the drawings created by A-SQUARE. All drawings created by A-SQUARE are protected by Indian and international copyright laws. Any unauthorized reproduction, distribution, or modification of A-SQUARE's drawings is strictly prohibited. A-SQUARE reserves the right to take legal action against any unauthorized use of its drawings. A-SQUARE grants clients a limited, non-exclusive, non-transferable license to use the drawings for the specific project or purpose for which they were created. Clients may not use the drawings for any other purpose without the express written consent of A-SQUARE. Clients may not modify, reproduce, distribute, transmit, display, perform, publish, license, create derivative works from, transfer, or sell any of A-SQUARE's drawings without the prior written consent of A-SQUARE. Clients may not use any of A-SQUARE's drawings as a basis for the design or construction of any other project without the express written consent of A-SQUARE. Clients may not disclose any of A-SQUARE's drawings to any third party without the prior written consent of A-SQUARE. kindly visit our web-site, to know more.

GENERAL NOTES

- All dimensions are in millimeters (mm); follow written dimensions, do not scale.
- Drawings must be coordinated across all disciplines; report discrepancies before execution.
- Designs comply with NBC, ASHRAE, NEC, IPS, and other applicable architectural & MEP standards.
- Use only the latest issued drawings; verify all dimensions and site conditions before execution.

VERSION CHART

| VERSION NO. | VERSION DATE |
|-------------|--------------|
| GFC         | 20-MAR-2025  |
|             |              |
|             |              |
|             |              |
|             |              |

ARCHITECT / INTERIOR CONSULTANTS:

STUDIO  
ELEVATE

PROJECT:



Bommasandra Industrial Area, Bommasandra Vilage, Anekal TK,  
Bengaluru (Bangalore) Urban, Karnataka, Bangalore, 560099

CLIENT:

DR. VIKRAM  
Dhyan Dishes LLP

ISSUED FOR:

GOOD FOR CONSTRUCTION

ISSUED DATE:

20-MAR-2025

DRAWN BY:

DA

CHECKED BY:

SK

APPROVED BY

AA

SHEET TITLE:


GROUND FLOOR-03  
POWER&LIGHTING  
DISTRIBUTION BOARD SLD

SHEET SIZE:


A3

DRAWING NO:

ASC-ELE-TRC-002-G

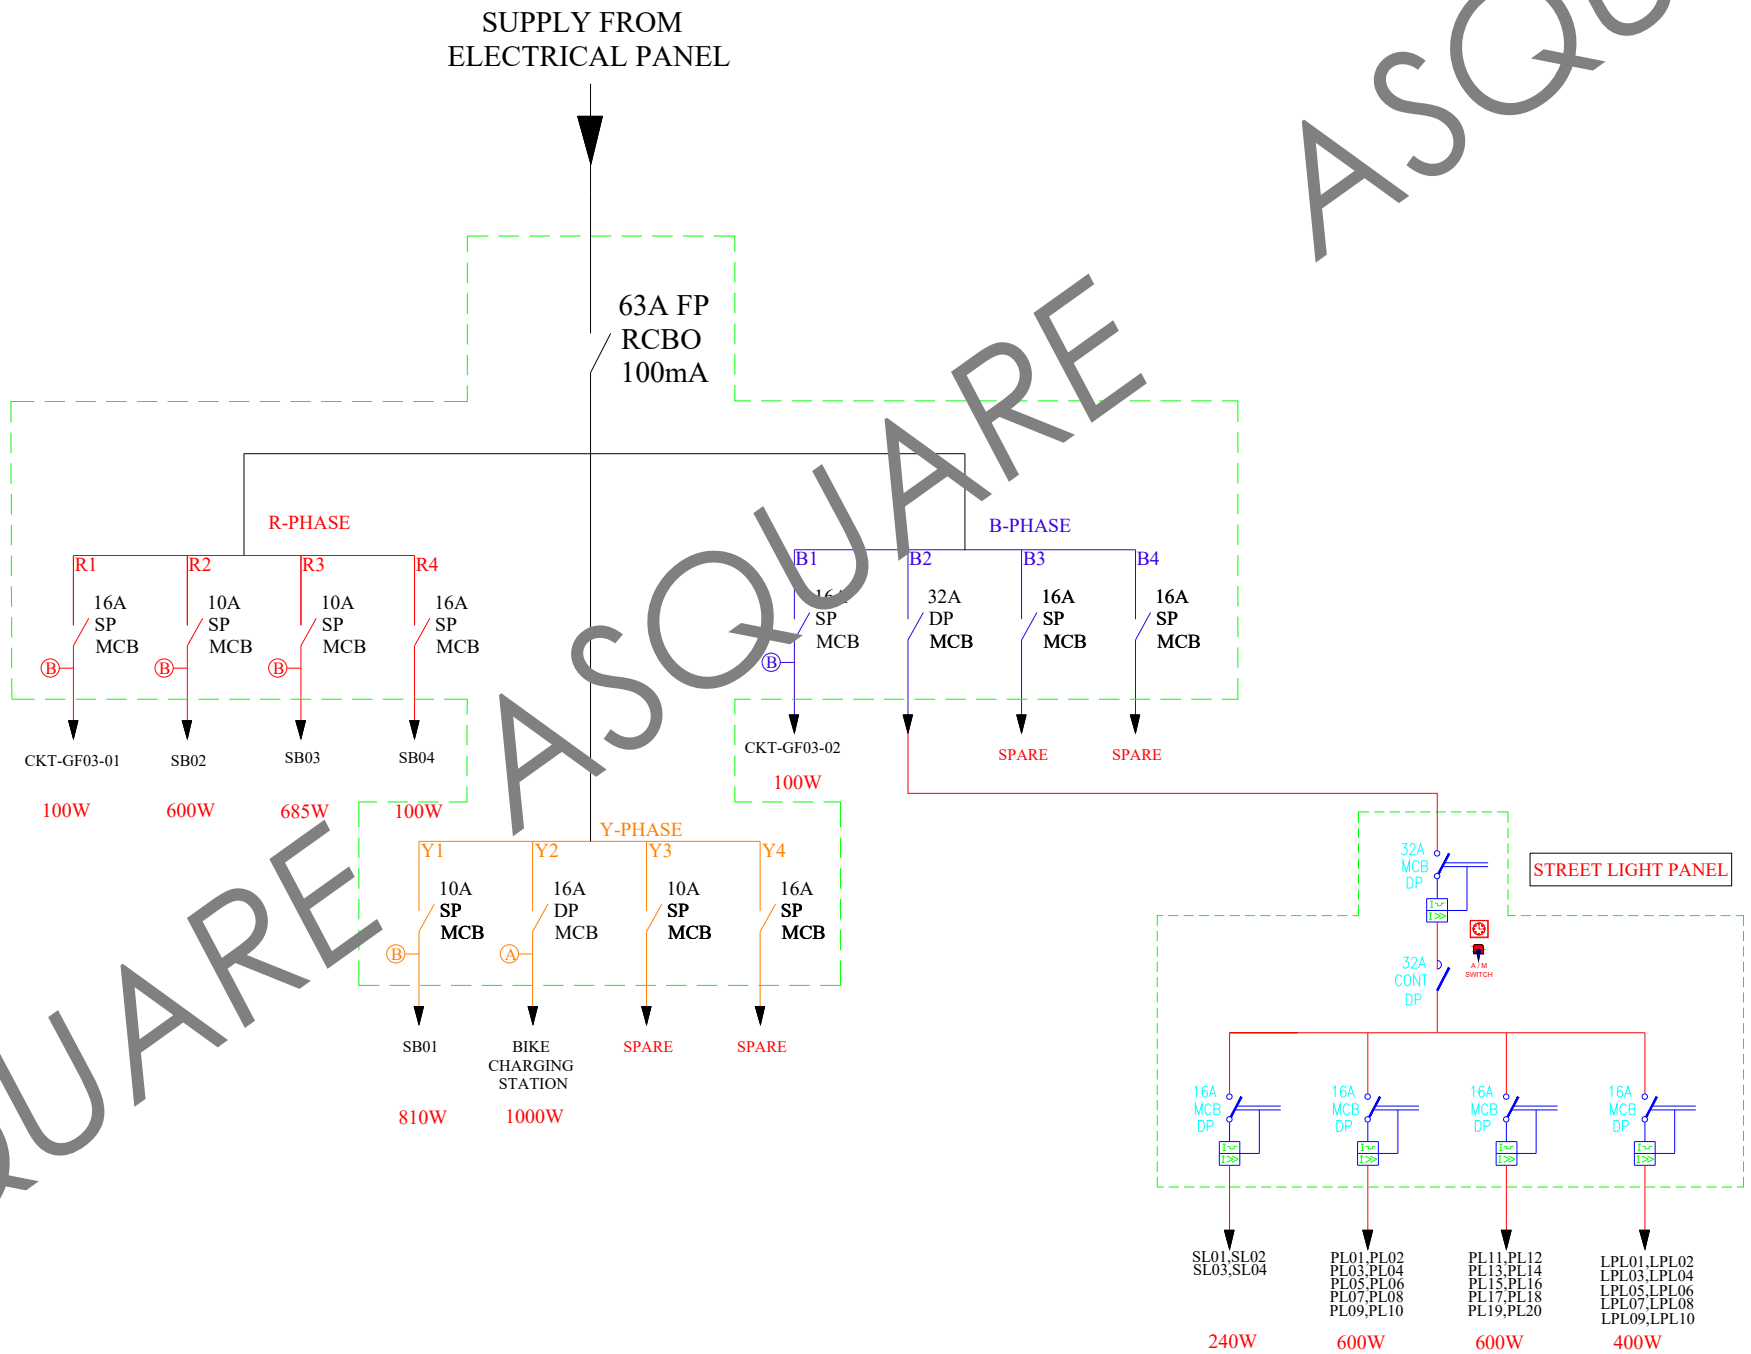

R-PHASE:- 1.48 KW  
Y-PHASE:- 1.81 KW  
B-PHASE:- 1.94 KW  
T.C.L :- 5.13KW  
T.D.L :- 4.10KW

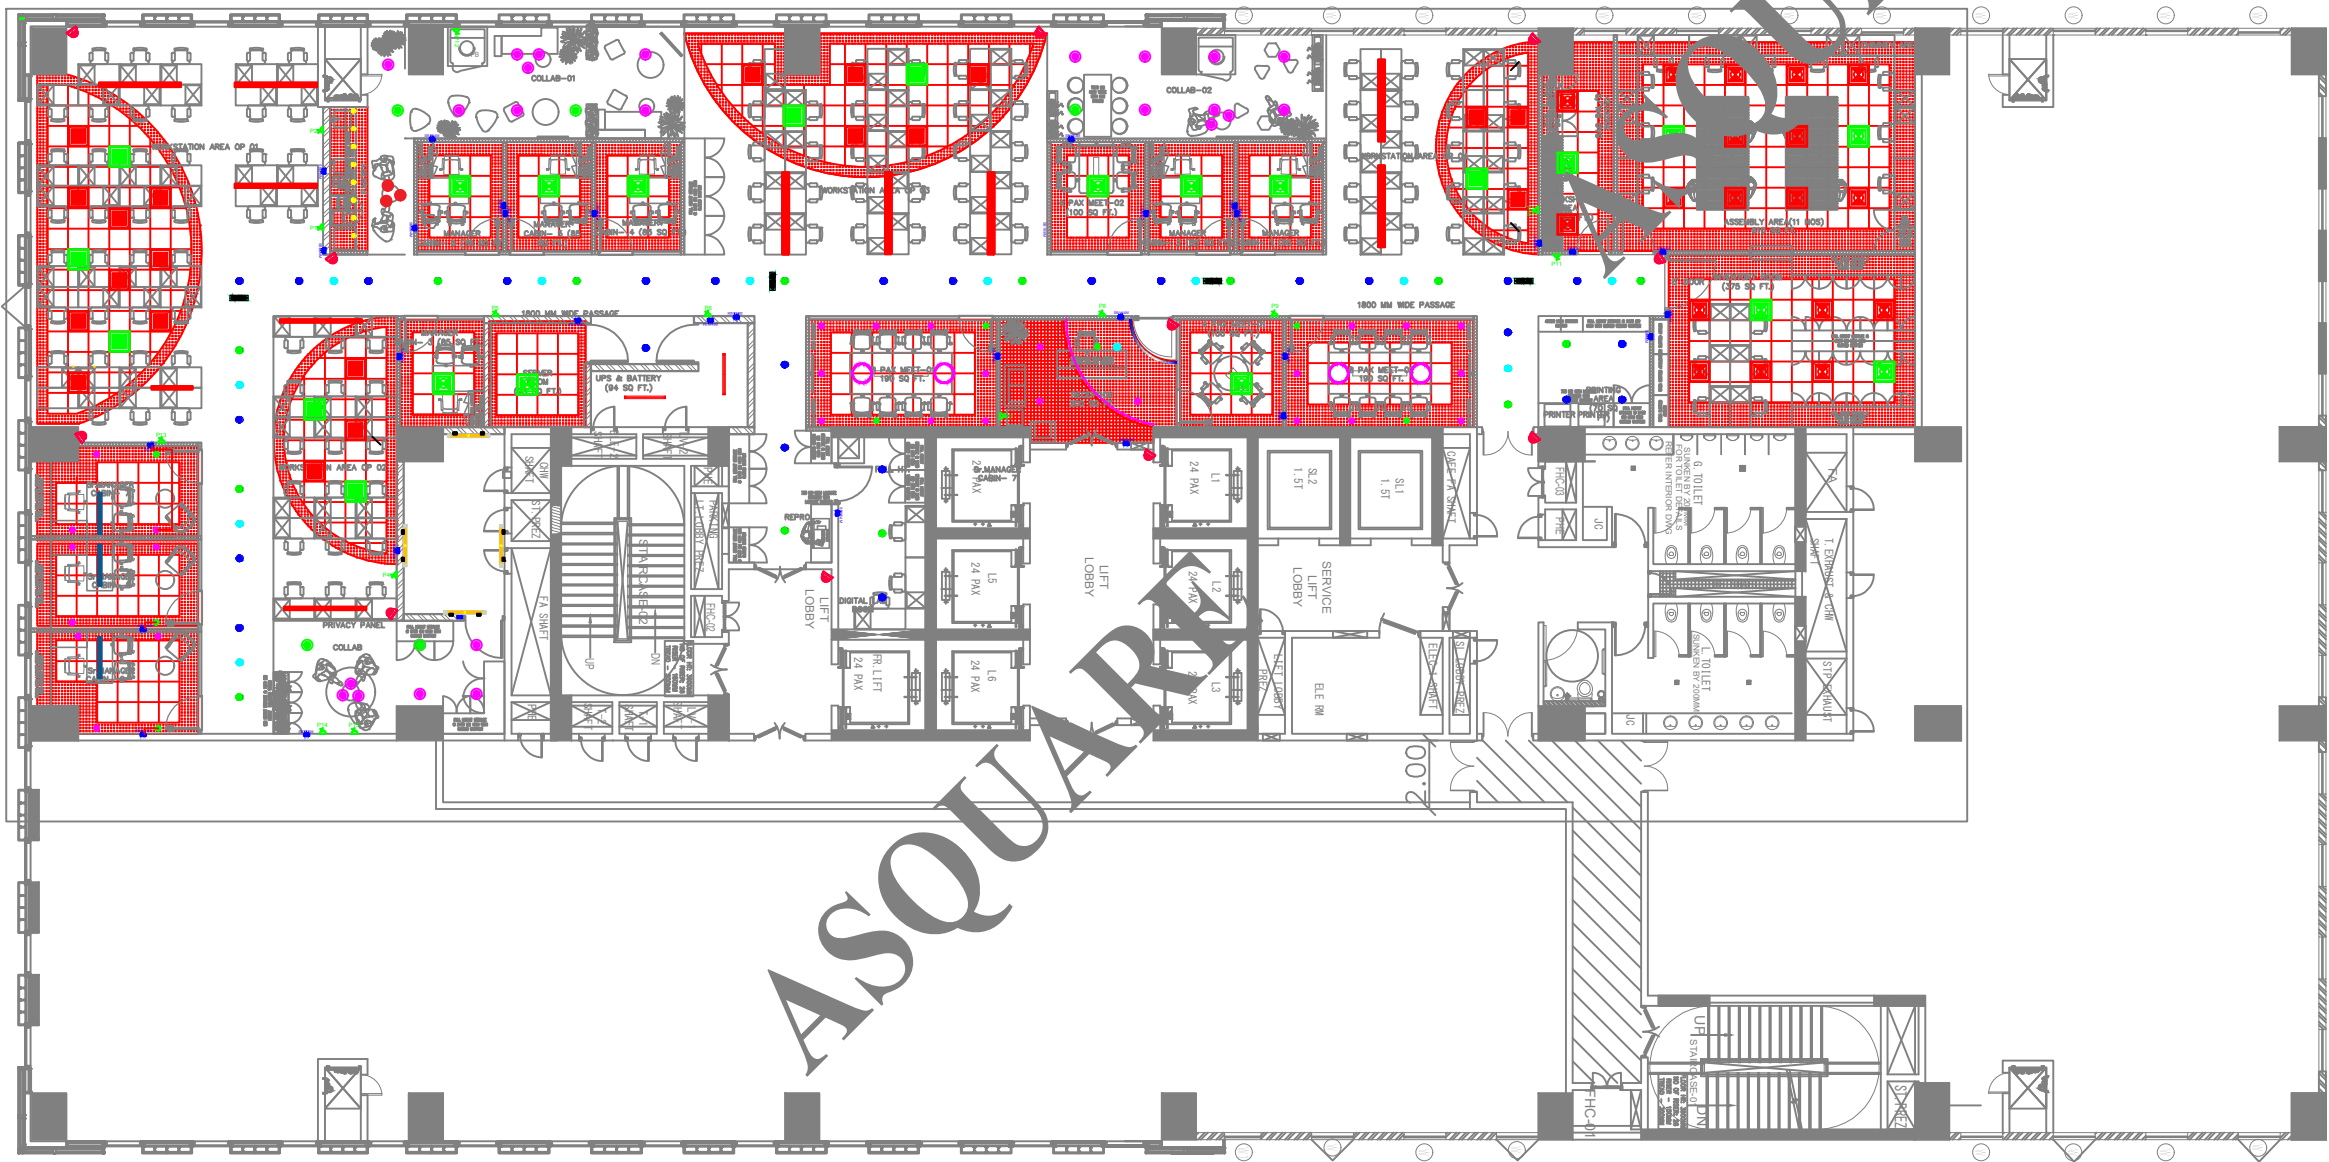

NOTE:-  
1. 6 Amp Single socket to be looped to the nearby Switchboard

| ELECTRICAL LIGHT LEGEND |        |                                           |
|-------------------------|--------|-------------------------------------------|
| S.N.                    | LEGEND | DESCRIPTION                               |
| 1.                      |        | -60W LED 2'X2' LIGHT                      |
| 2.                      |        | -60W LED 2'X2' LIGHT (EMERGENCY)          |
| 3.                      |        | -36W LED 2'X2' LIGHT                      |
| 4.                      |        | -36W LED 2'X2' LIGHT (EMERGENCY)          |
| 5.                      |        | -15W RECESSED LED DOWN LIGHT              |
| 6.                      |        | -15W RECESSED LED DOWN LIGHT (EMERGENCY)  |
| 7.                      |        | -15W PENDENT LED DOWN LIGHT               |
| 8.                      |        | -15W PENDENT LED DOWN LIGHT (EMERGENCY)   |
| 9.                      |        | -8W RECESSED LED DOWN LIGHT               |
| 10.                     |        | -SWITCH BOARD                             |
| 11.                     |        | -6W CEILING SPEAKER                       |
| 12.                     |        | -22W CEILING TUBE LIGHT                   |
| 13.                     |        | -22W WALL TUBE LIGHT                      |
| 14.                     |        | -10WIM LED STRIP COVE LIGHT               |
| 15.                     |        | - DOME HANGING LAMP LIGHT                 |
| 16.                     |        | - DOME HANGING LAMP LIGHT (EMERGENCY)     |
| 17.                     |        | - BAMBOO HANGING LAMP LIGHT               |
| 18.                     |        | - BAMBOO HANGING LAMP LIGHT (EMERGENCY)   |
| 19.                     |        | -40W LED ROUND HANGING PENDENT LIGHT      |
| 20.                     |        | -10WIM LED STRIP COVE LIGHT               |
| 21.                     |        | -2 Nos 45W LED LINEAR SUSPENDED LED LIGHT |
| 22.                     |        | -1 Nos 45W LED LINEAR SUSPENDED LED LIGHT |

LOW VOLTAGE LEGEND

| S.N. | LEGEND | DESCRIPTION                               | QTY. |
|------|--------|-------------------------------------------|------|
| 1.   |        | -6W CEILING SPEAKER                       |      |
| 2.   |        | -20mm dia PVC Conduit for Ceiling Speaker |      |

LOW VOLTAGE LEGEND

| S.N. | LEGEND | DESCRIPTION                    | QTY. |
|------|--------|--------------------------------|------|
| 1.   |        | -Network Video Recorder        |      |
| 2.   |        | -25mm dia PVC Conduit for CCTV |      |
| 3.   |        | -IP Dome CCTV                  |      |

MEP CONSULTANTS:



1st Floor, APR & MRS ARCADE,  
Vijayapura Road, Devanahalli,  
BENGALURU INDIA , 562110

A-SQUARE MEP Consultants (hereafter referred to as "A-SQUARE") retains all copyright and other proprietary rights to the drawings created by A-SQUARE. All drawings created by A-SQUARE are protected by Indian and international copyright laws. Any unauthorized reproduction, distribution, or modification of A-SQUARE's drawings is strictly prohibited. A-SQUARE reserves the right to take legal action against any unauthorized use of its drawings. A-SQUARE grants clients a limited, non-exclusive, non-transferable license to use the drawings for the specific project or purpose for which they were created. Clients may not use the drawings for any other purpose without the express written consent of A-SQUARE. Clients may not modify, reproduce, distribute, transmit, display, perform, publish, license, create derivative works from, transfer, or sell any of A-SQUARE's drawings without the prior written consent of A-SQUARE. Clients may not use any of A-SQUARE's drawings as a basis for the design or construction of any other project without the express written consent of A-SQUARE. Clients may not disclose any of A-SQUARE's drawings to any third party without the prior written consent of A-SQUARE. kindly visit our web-site, to know more.

GENERAL NOTES

- All dimensions are in millimeters (mm); follow written dimensions, do not scale.
- Drawings must be coordinated across all disciplines; report discrepancies before execution.
- Designs comply with NBC, ASHRAE, NEC, IPS, and other applicable architectural & MEP standards.
- Use only the latest issued drawings; verify all dimensions and site conditions before execution.

VERSION CHART

| VERSION NO. | VERSION DATE |
|-------------|--------------|
| APPROVAL-01 | 08-MAR-2025  |
| GFC         | 27-MAR-2025  |
|             |              |
|             |              |
|             |              |

ARCHITECT / INTERIOR CONSULTANT:



#12, 3RD FLOOR, 60FT ROAD,  
6TH BLOCK, KORMANGALA,  
BENGALURU 560034, INDIA

PROJECT:

ASTROME  
BRIGADE DECCAN HEIGHTS

CLIENT:

ASTROME TECHNOLOGIES

ISSUED FOR:

GOOD FOR CONSTRUCTION

ISSUED DATE:

27-MAR-2025

DRAWN BY:

DA

CHECKED BY:

SK

APPROVED BY

AA

SHEET TITLE:


ELECTRICAL COORDINATION  
WITH RCP LAYOUT

SHEET SIZE:

A3

DRAWING NO:

ASC-ELE-ATM-001

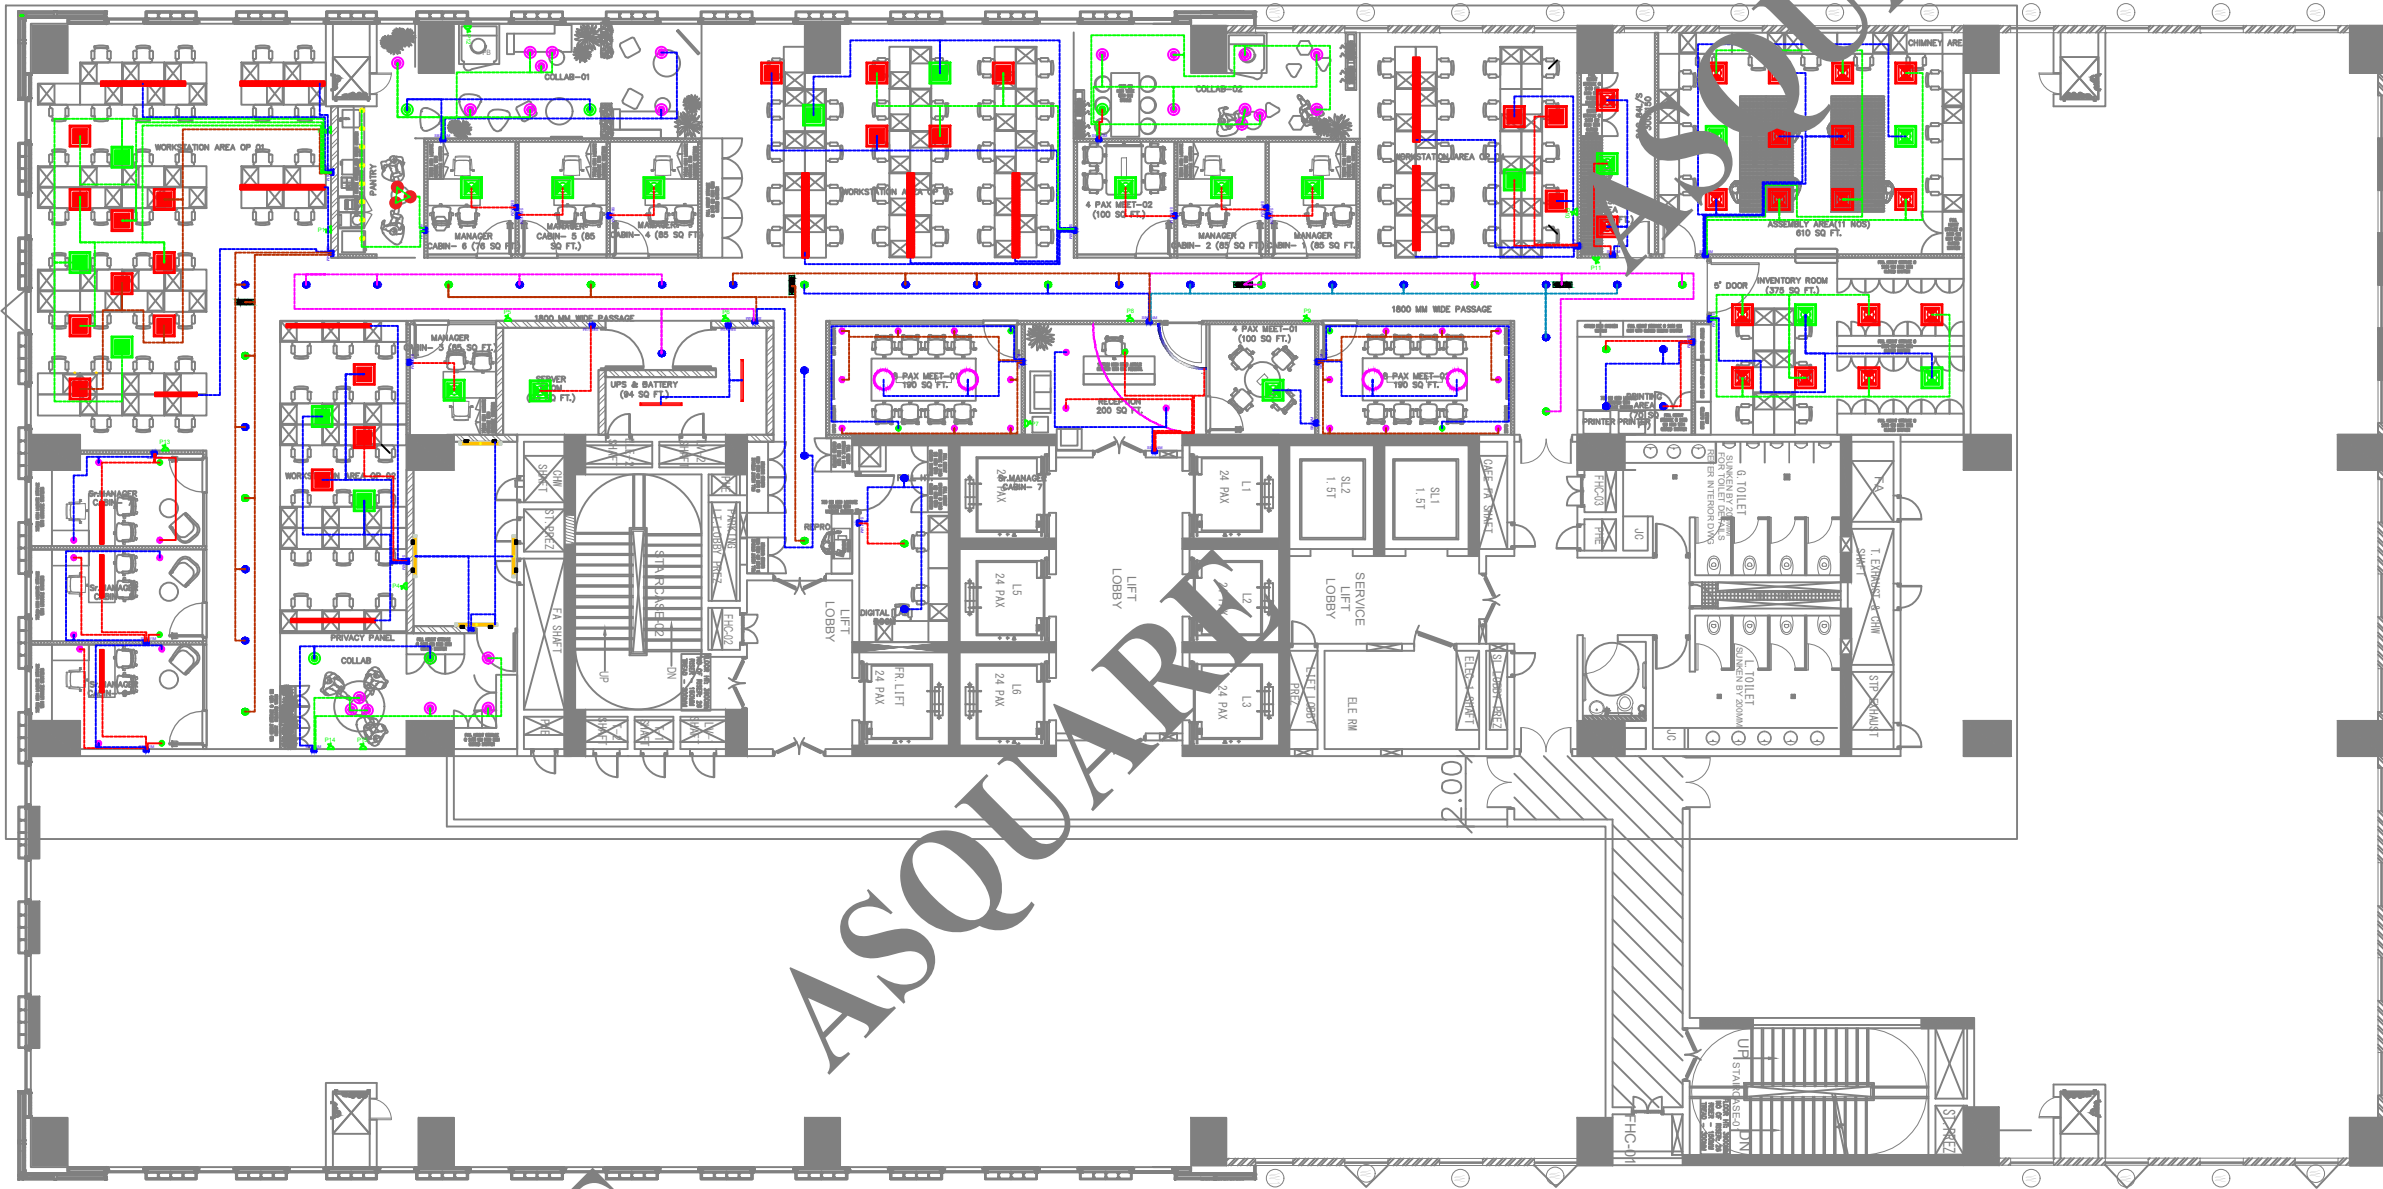

NOTE:-  
1. 6 Amp Single socket to be looped to the nearby Switchboard

| S.N. | DESCRIPTION           |
|------|-----------------------|
| 1.   | SWITCH TO 1 FITTING   |
| 2.   | 1 SWITCH TO 2 FITTING |
| 3.   | 1 SWITCH TO 3 FITTING |
| 4.   | 1 SWITCH TO 4 FITTING |
| 5.   | 1 SWITCH TO 5 FITTING |
| 6.   | 1 SWITCH TO 6 FITTING |

| S.N. | LEGEND          | DESCRIPTION                                | QTY |
|------|-----------------|--------------------------------------------|-----|
| 1.   | [Red Square]    | -60W LED 2'X2' LIGHT                       |     |
| 2.   | [Green Square]  | -60W LED 2'X2' LIGHT (EMERGENCY)           |     |
| 3.   | [Blue Square]   | -36W LED 2'X2' LIGHT                       |     |
| 4.   | [Yellow Square] | -36W LED 2'X2' LIGHT (EMERGENCY)           |     |
| 5.   | [Pink Circle]   | -15W RECESSED LED DOWN LIGHT               |     |
| 6.   | [Green Circle]  | -15W RECESSED LED DOWN LIGHT (EMERGENCY)   |     |
| 7.   | [Blue Circle]   | -15W PENDENT LED DOWN LIGHT                |     |
| 8.   | [Yellow Circle] | -15W PENDENT LED DOWN LIGHT (EMERGENCY)    |     |
| 9.   | [Orange Circle] | -8W RECESSED LED DOWN LIGHT                |     |
| 10.  | [Blue Square]   | -SWITCH BOARD                              |     |
| 11.  | [Blue Circle]   | -6W CEILING SPEAKER                        |     |
| 12.  | [Red Line]      | -22W CEILING TUBE LIGHT                    |     |
| 13.  | [Yellow Line]   | -22W WALL TUBE LIGHT                       |     |
| 14.  | [Blue Line]     | -10WIM LED STRIP COVE LIGHT                |     |
| 15.  | [Pink Circle]   | - DOME HANGING LAMP LIGHT                  |     |
| 16.  | [Green Circle]  | - DOME HANGING LAMP LIGHT (EMERGENCY)      |     |
| 17.  | [Red Circle]    | - BAMBO HANGING LAMP LIGHT                 |     |
| 18.  | [Yellow Circle] | - BAMBO HANGING LAMP LIGHT (EMERGENCY)     |     |
| 19.  | [Pink Circle]   | - 40W LED ROUND HANGING PENDENT LIGHT      |     |
| 20.  | [Blue Line]     | - 10WIM LED STRIP COVE LIGHT               |     |
| 21.  | [Red Line]      | - 2 Nos 45W LED LINEAR SUSPENDED LED LIGHT |     |
| 22.  | [Blue Line]     | - 1 Nos 45W LED LINEAR SUSPENDED LED LIGHT |     |

MEP CONSULTANTS:



1st Floor, APR & MRS ARCADE,  
Vijayapura Road, Devanahalli,  
BENGALURU INDIA , 562110

A-SQUARE MEP Consultants (hereafter referred to as "A-SQUARE") retains all copyright and other proprietary rights to the drawings created by A-SQUARE. All drawings created by A-SQUARE are protected by Indian and international copyright laws. Any unauthorized reproduction, distribution, or modification of A-SQUARE's drawings is strictly prohibited. A-SQUARE reserves the right to take legal action against any unauthorized use of its drawings. A-SQUARE grants clients a limited, non-exclusive, non-transferable license to use the drawings for the specific project or purpose for which they were created. Clients may not use the drawings for any other purpose without the express written consent of A-SQUARE. Clients may not modify, reproduce, distribute, transmit, display, perform, publish, license, create derivative works from, transfer, or sell any of A-SQUARE's drawings without the prior written consent of A-SQUARE. Clients may not use any of A-SQUARE's drawings as a basis for the design or construction of any other project without the express written consent of A-SQUARE. Clients may not disclose any of A-SQUARE's drawings to any third party without the prior written consent of A-SQUARE. kindly visit our web-site, to know more.

#### GENERAL NOTES

- All dimensions are in millimeters (mm); follow written dimensions, do not scale.
- Drawings must be coordinated across all disciplines; report discrepancies before execution.
- Designs comply with NBC, ASHRAE, NEC, IPS, and other applicable architectural & MEP standards.
- Use only the latest issued drawings; verify all dimensions and site conditions before execution.

#### VERSION CHART

| VERSION NO. | VERSION DATE |
|-------------|--------------|
| APPROVAL-01 | 08-MAR-2025  |
| GFC         | 27-MAR-2025  |
|             |              |
|             |              |
|             |              |

ARCHITECT / INTERIOR CONSULTANT:



#12, 3RD FLOOR, 60FT ROAD,  
6TH BLOCK, KORMANGALA,  
BENGALURU 560034, INDIA

PROJECT:

**ASTROME  
BRIGADE DECCAN HEIGHTS**

**ASTROME TECHNOLOGIES**

ISSUED FOR:

**GOOD FOR CONSTRUCTION**

ISSUED DATE:

**27-MAR-2025**

DRAWN BY:

**DA**

CHECKED BY:

**SK**

APPROVED BY

**AA**

SHEET TITLE:

**LOOPING LAYOUT**


SHEET SIZE:

**A3**

DRAWING NO:

**ASC-ELE-ATM-003**



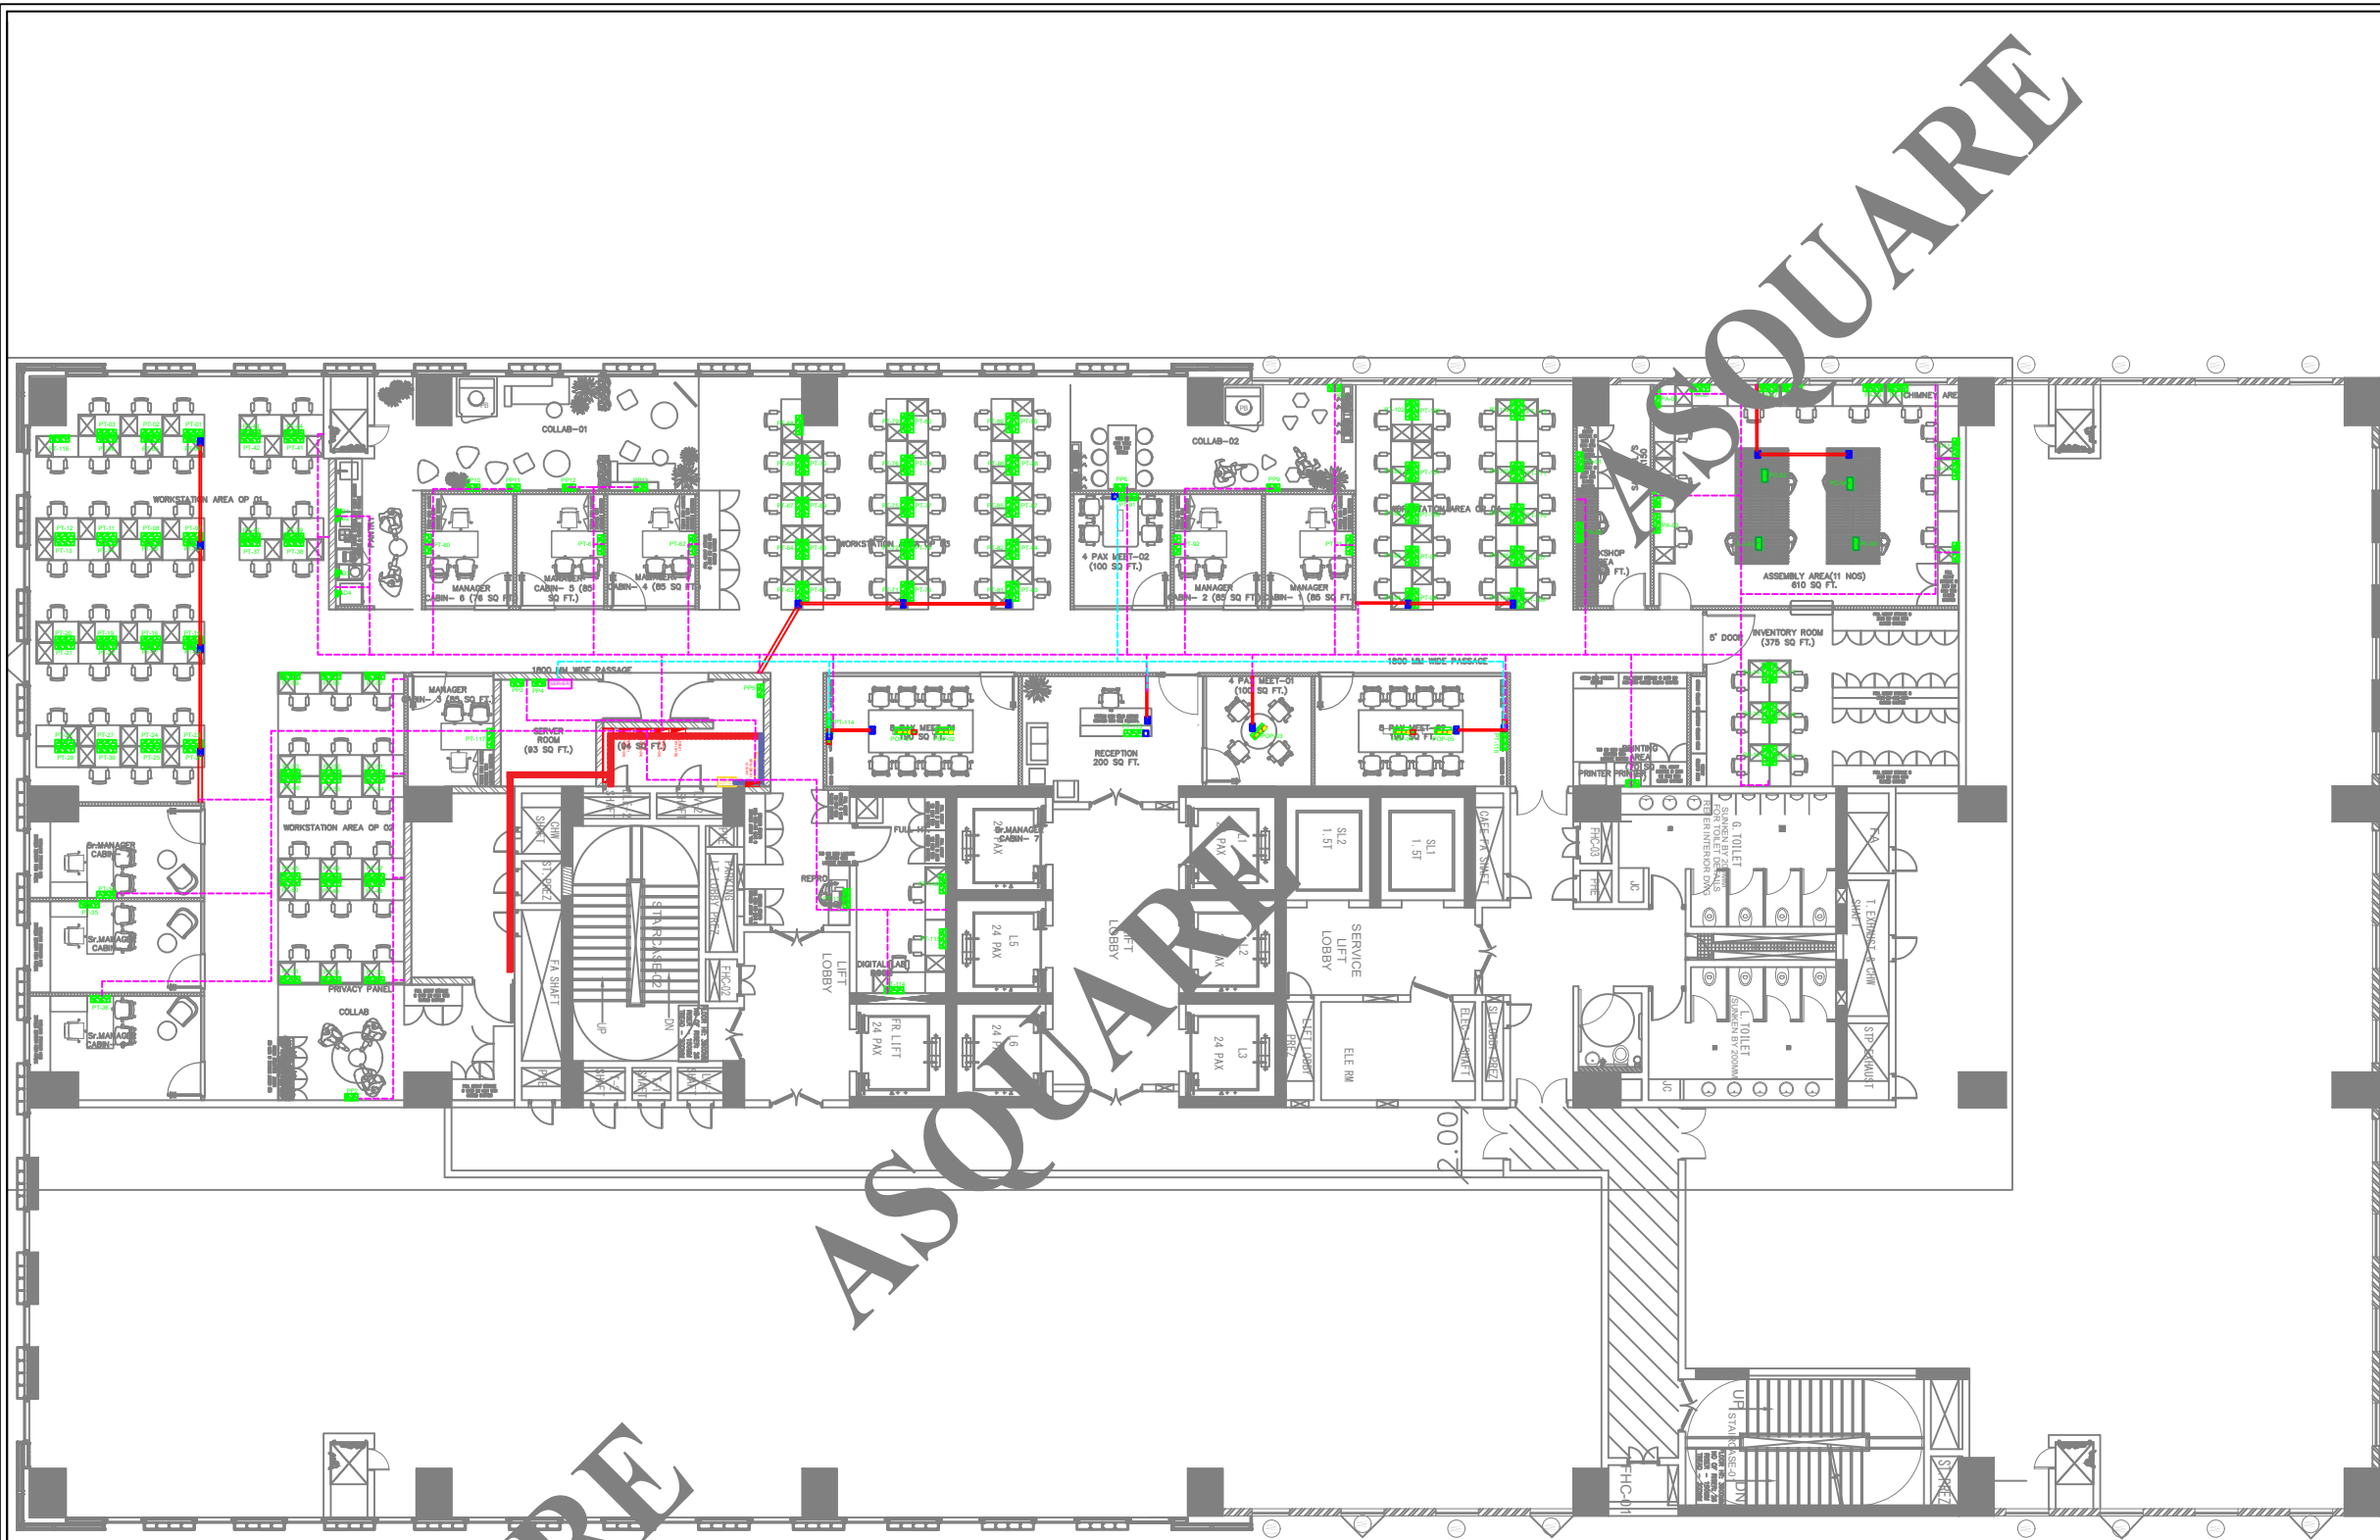

| S.N. | SYM. | NOM. | DESCRIPTION                                                      |
|------|------|------|------------------------------------------------------------------|
| 1.   |      | P    | 6Amp Socket with Switch                                          |
| 2.   |      | D    | 16Amp Socket with Switch                                         |
| 3.   |      | PP   | 2 Nos 6Amp Socket + 2 Nos 6Amp Switch                            |
| 4.   |      | PC   | 2 Nos 16Amp Socket + 2 Nos 16Amp Switch                          |
| 5.   |      | PT   | 3 Nos 6Amp Socket + 2 Nos 6Amp Switch                            |
| 6.   |      | PA   | 2 Nos 6Amp Socket + 1 Nos 6Amp Switch & 16Amp Socket with Switch |
| 7.   |      | POP  | Pop Up Box with 3 Nos 6Amp Socket + 3 Nos 6Amp Switch            |
| 8.   |      |      | Uninterruptible Power Supply                                     |
| 9.   |      |      | Electrical Panel                                                 |
| 10.  |      |      | MCB TPN Single door DB                                           |
| 11.  |      |      | 20MM DIA PVC Conduit for power circuit                           |
| 12.  |      |      | 25MM DIA PVC Conduit for data points                             |
| 13.  |      |      | Under Floor Raceway                                              |
| 14.  |      |      | Data point & hdmi socket as per location                         |
| 15.  |      |      | Power point raceway junction box                                 |

MEP CONSULTANTS:



1st Floor, APR & MRS ARCADE,  
Vijayapura Road, Devanahalli,  
BENGALURU INDIA , 562110

A-SQUARE MEP Consultants (hereafter referred to as "A-SQUARE") retains all copyright and other proprietary rights to the drawings created by A-SQUARE. All drawings created by A-SQUARE are protected by Indian and international copyright laws. Any unauthorized reproduction, distribution, or modification of A-SQUARE's drawings is strictly prohibited. A-SQUARE reserves the right to take legal action against any unauthorized use of its drawings. A-SQUARE grants clients a limited, non-exclusive, non-transferable license to use the drawings for the specific project or purpose for which they were created. Clients may not use the drawings for any other purpose without the express written consent of A-SQUARE. Clients may not modify, reproduce, distribute, transmit, display, perform, publish, license, create derivative works from, transfer, or sell any of A-SQUARE's drawings without the prior written consent of A-SQUARE. Clients may not use any of A-SQUARE's drawings as a basis for the design or construction of any other project without the express written consent of A-SQUARE. Clients may not disclose any of A-SQUARE's drawings to any third party without the prior written consent of A-SQUARE. kindly visit our web-site, to know more.

GENERAL NOTES

- All dimensions are in millimeters (mm); follow written dimensions, do not scale.
- Drawings must be coordinated across all disciplines; report discrepancies before execution.
- Designs comply with NBC, ASHRAE, NEC, IPS, and other applicable architectural & MEP standards.
- Use only the latest issued drawings; verify all dimensions and site conditions before execution.

VERSION CHART

| VERSION NO. | VERSION DATE |
|-------------|--------------|
| APPROVAL-01 | 08-MAR-2025  |
| GFC         | 27-MAR-2025  |
|             |              |
|             |              |
|             |              |

ARCHITECT / INTERIOR CONSULTANT:



#12, 3RD FLOOR, 60FT ROAD,  
6TH BLOCK, KORMANGALA,  
BENGALURU 560034, INDIA

PROJECT:

ASTROME  
BRIGADE DECCAN HEIGHTS

ASTROME TECHNOLOGIES

ISSUED FOR:

GOOD FOR CONSTRUCTION

ISSUED DATE:

27-MAR-2025

DRAWN BY:

DA

CHECKED BY:

SK

APPROVED BY

AA

SHEET TITLE:

POWER POINT,DB & CABLE TRAY LAYOUT


SHEET SIZE:

A3

DRAWING NO:

ASC-ELE-ATM-005



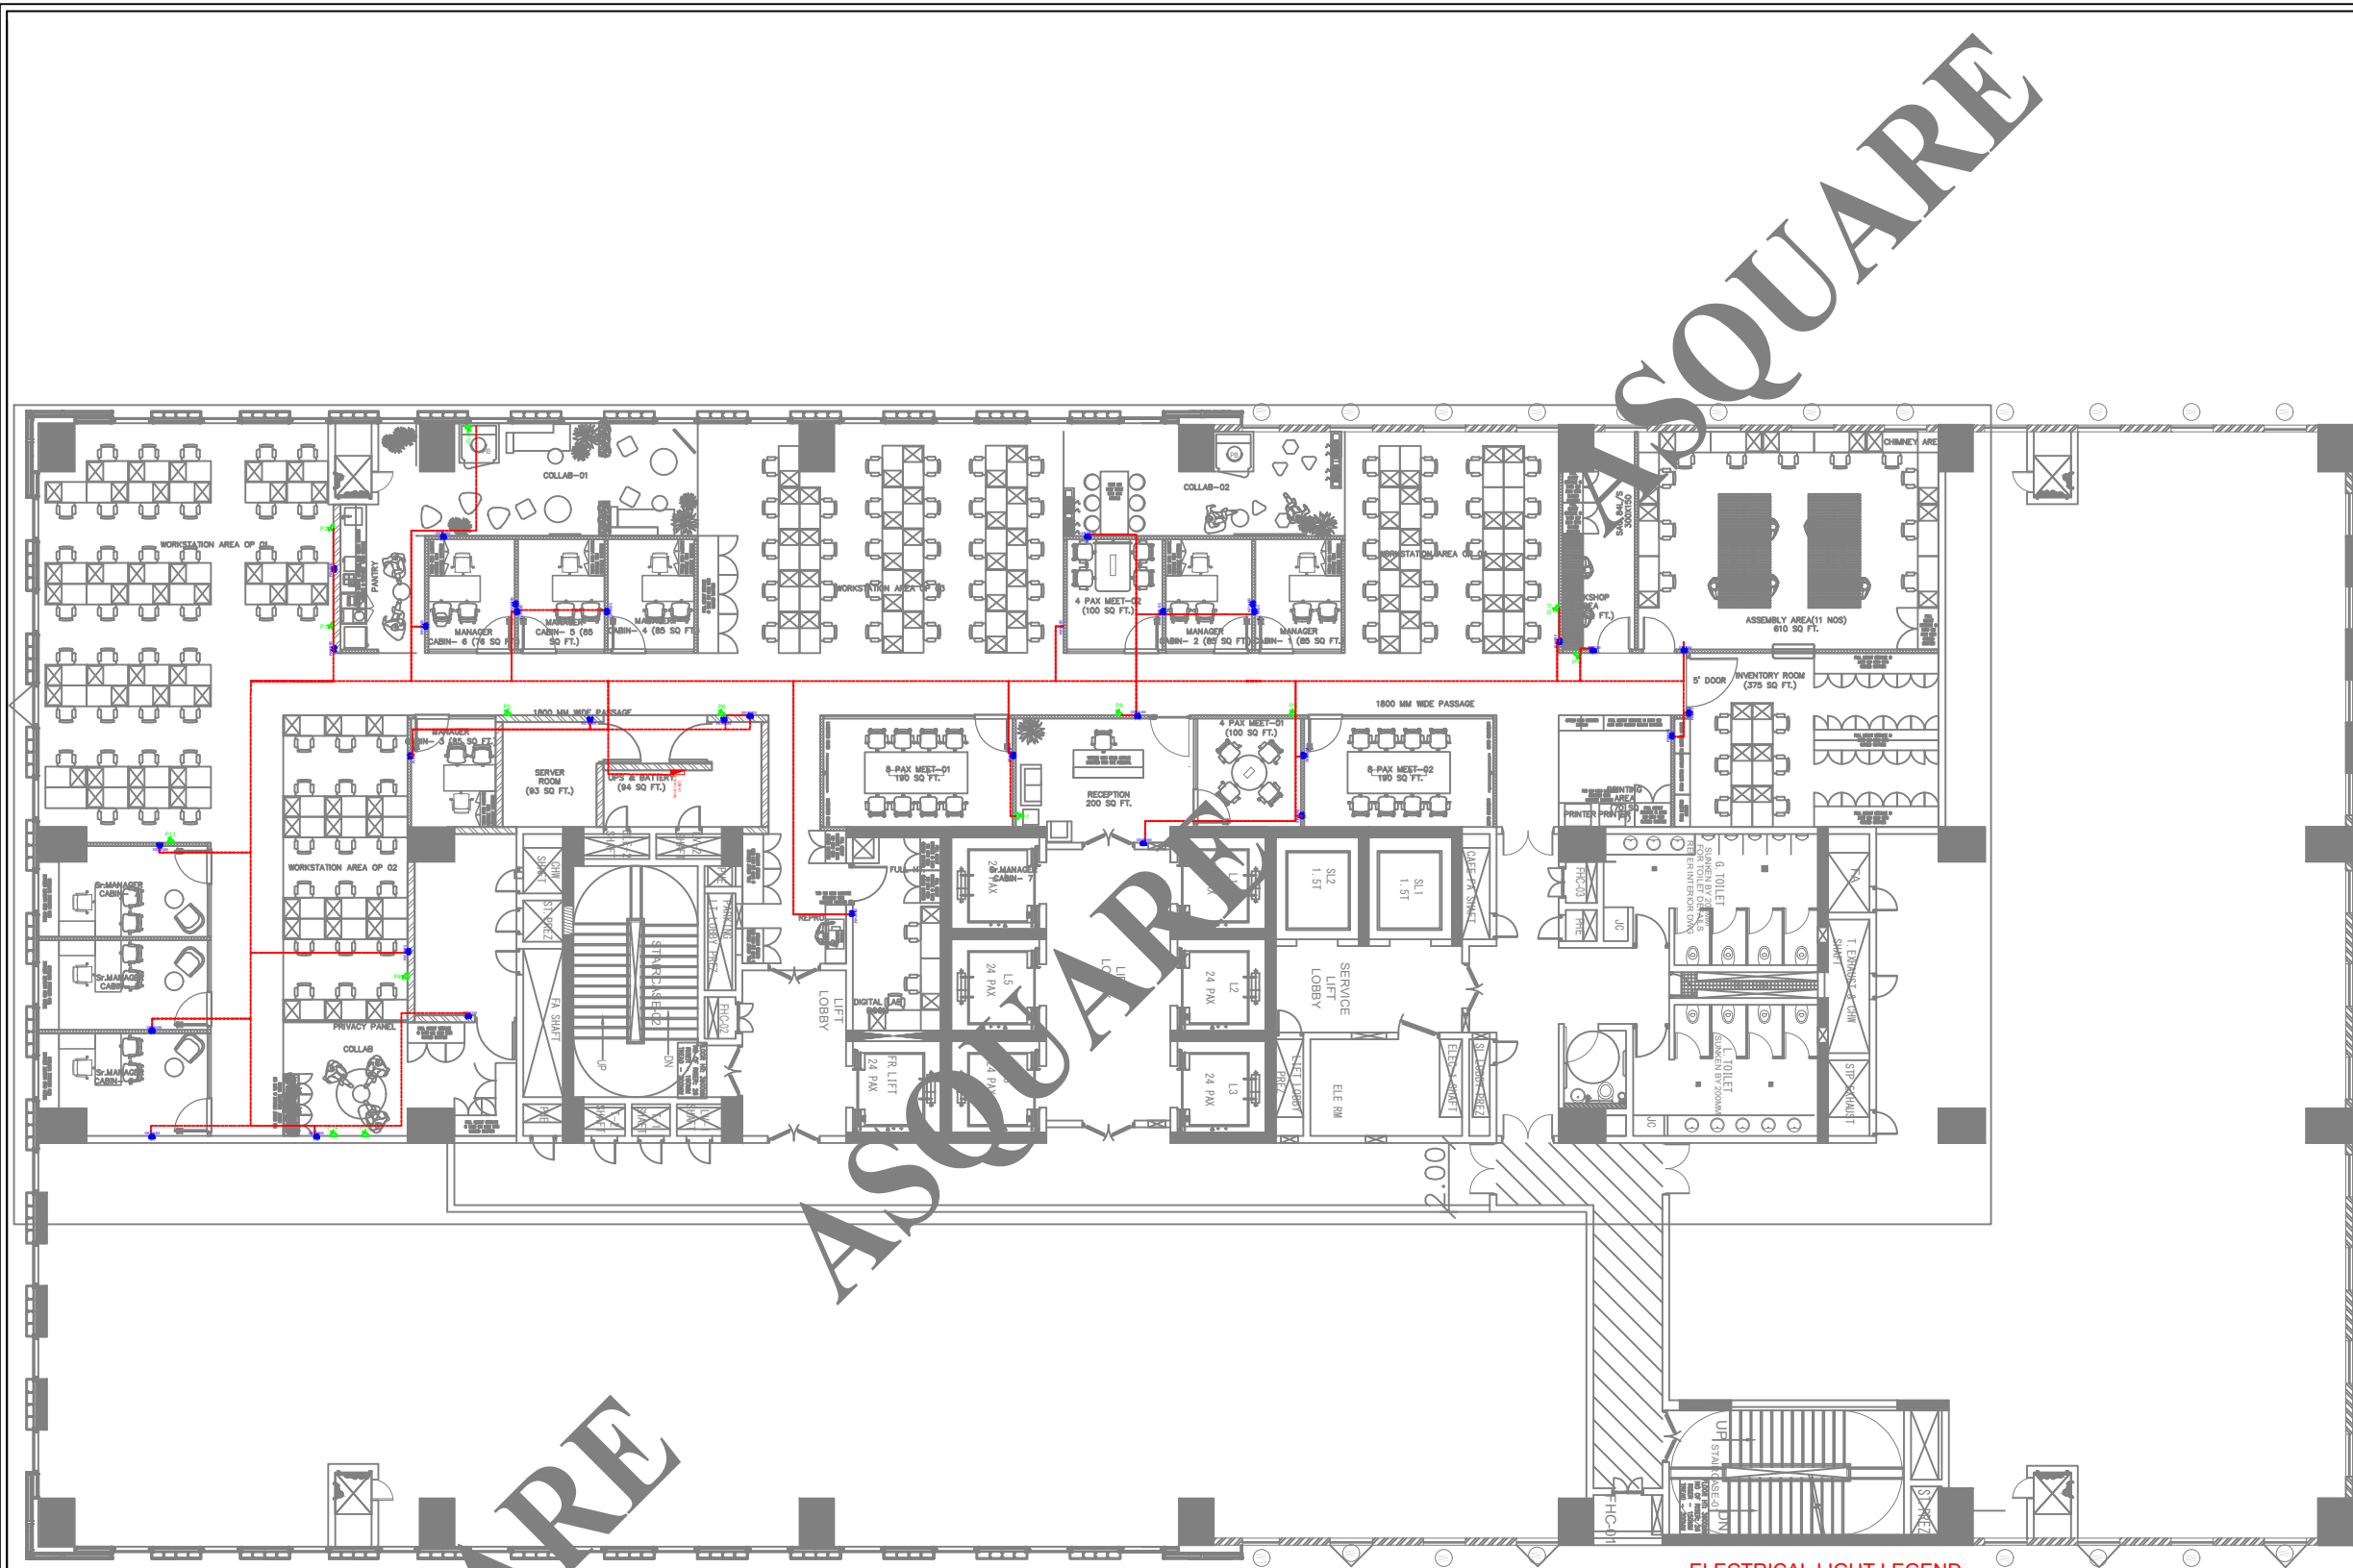

NOTE:-  
1. 6 Amp Single socket to be looped to the nearby Switchboard

ELECTRICAL LIGHT LEGEND

| S.N. | LEGEND | DESCRIPTION             | QTY. |
|------|--------|-------------------------|------|
| 1.   |        | -SWITCH BOARD           |      |
| 2.   |        | -6AMP SOCKET WITH SWICH |      |
| 2.   |        | 25MM PVC CONDUIT        |      |

MEP CONSULTANTS:



1st Floor, APR & MRS ARCADE,  
Vijayapura Road, Devanahalli,  
BENGALURU INDIA , 562110

A-SQUARE MEP Consultants (hereafter referred to as "A-SQUARE") retains all copyright and other proprietary rights to the drawings created by A-SQUARE. All drawings created by A-SQUARE are protected by Indian and international copyright laws. Any unauthorized reproduction, distribution, or modification of A-SQUARE's drawings is strictly prohibited. A-SQUARE reserves the right to take legal action against any unauthorized use of its drawings. A-SQUARE grants clients a limited, non-exclusive, non-transferable license to use the drawings for the specific project or purpose for which they were created. Clients may not use the drawings for any other purpose without the express written consent of A-SQUARE. Clients may not modify, reproduce, distribute, transmit, display, perform, publish, license, create derivative works from, transfer, or sell any of A-SQUARE's drawings without the prior written consent of A-SQUARE. Clients may not use any of A-SQUARE's drawings as a basis for the design or construction of any other project without the express written consent of A-SQUARE. Clients may not disclose any of A-SQUARE's drawings to any third party without the prior written consent of A-SQUARE. kindly visit our web-site, to know more.

GENERAL NOTES

- All dimensions are in millimeters (mm); follow written dimensions, do not scale.
- Drawings must be coordinated across all disciplines; report discrepancies before execution.
- Designs comply with NBC, ASHRAE, NEC, IPS, and other applicable architectural & MEP standards.
- Use only the latest issued drawings; verify all dimensions and site conditions before execution.

VERSION CHART

| VERSION NO. | VERSION DATE |
|-------------|--------------|
| APPROVAL-01 | 08-MAR-2025  |
| GFC         | 27-MAR-2025  |
|             |              |
|             |              |

ARCHITECT / INTERIOR CONSULTANT:



#12, 3RD FLOOR, 60FT ROAD,  
6TH BLOCK, KORMANGALA,  
BENGALURU 560034, INDIA

PROJECT:

ASTROME  
BRIGADE DECCAN HEIGHTS

ASTROME TECHNOLOGIES

ISSUED FOR:

GOOD FOR CONSTRUCTION

ISSUED DATE:

27-MAR-2025

DRAWN BY:

DA

CHECKED BY:

SK

APPROVED BY

AA

SHEET TITLE:

SUBMAIN LAYOUT

SHEET SIZE:

A3

DRAWING NO:

ASC-ELE-ATM-004

PDB -01  
Loc. DB PANEL ROOM


Ⓐ—(2x4Sq.mm + 1x2.5 Sq.mm) Copper Wire

8 Way  
Single Door  
TPN MCB DB

POWER DB SLD-01

SUPPLY FROM  
ELECTRICAL PANEL

40A FP  
RCBO  
100mA

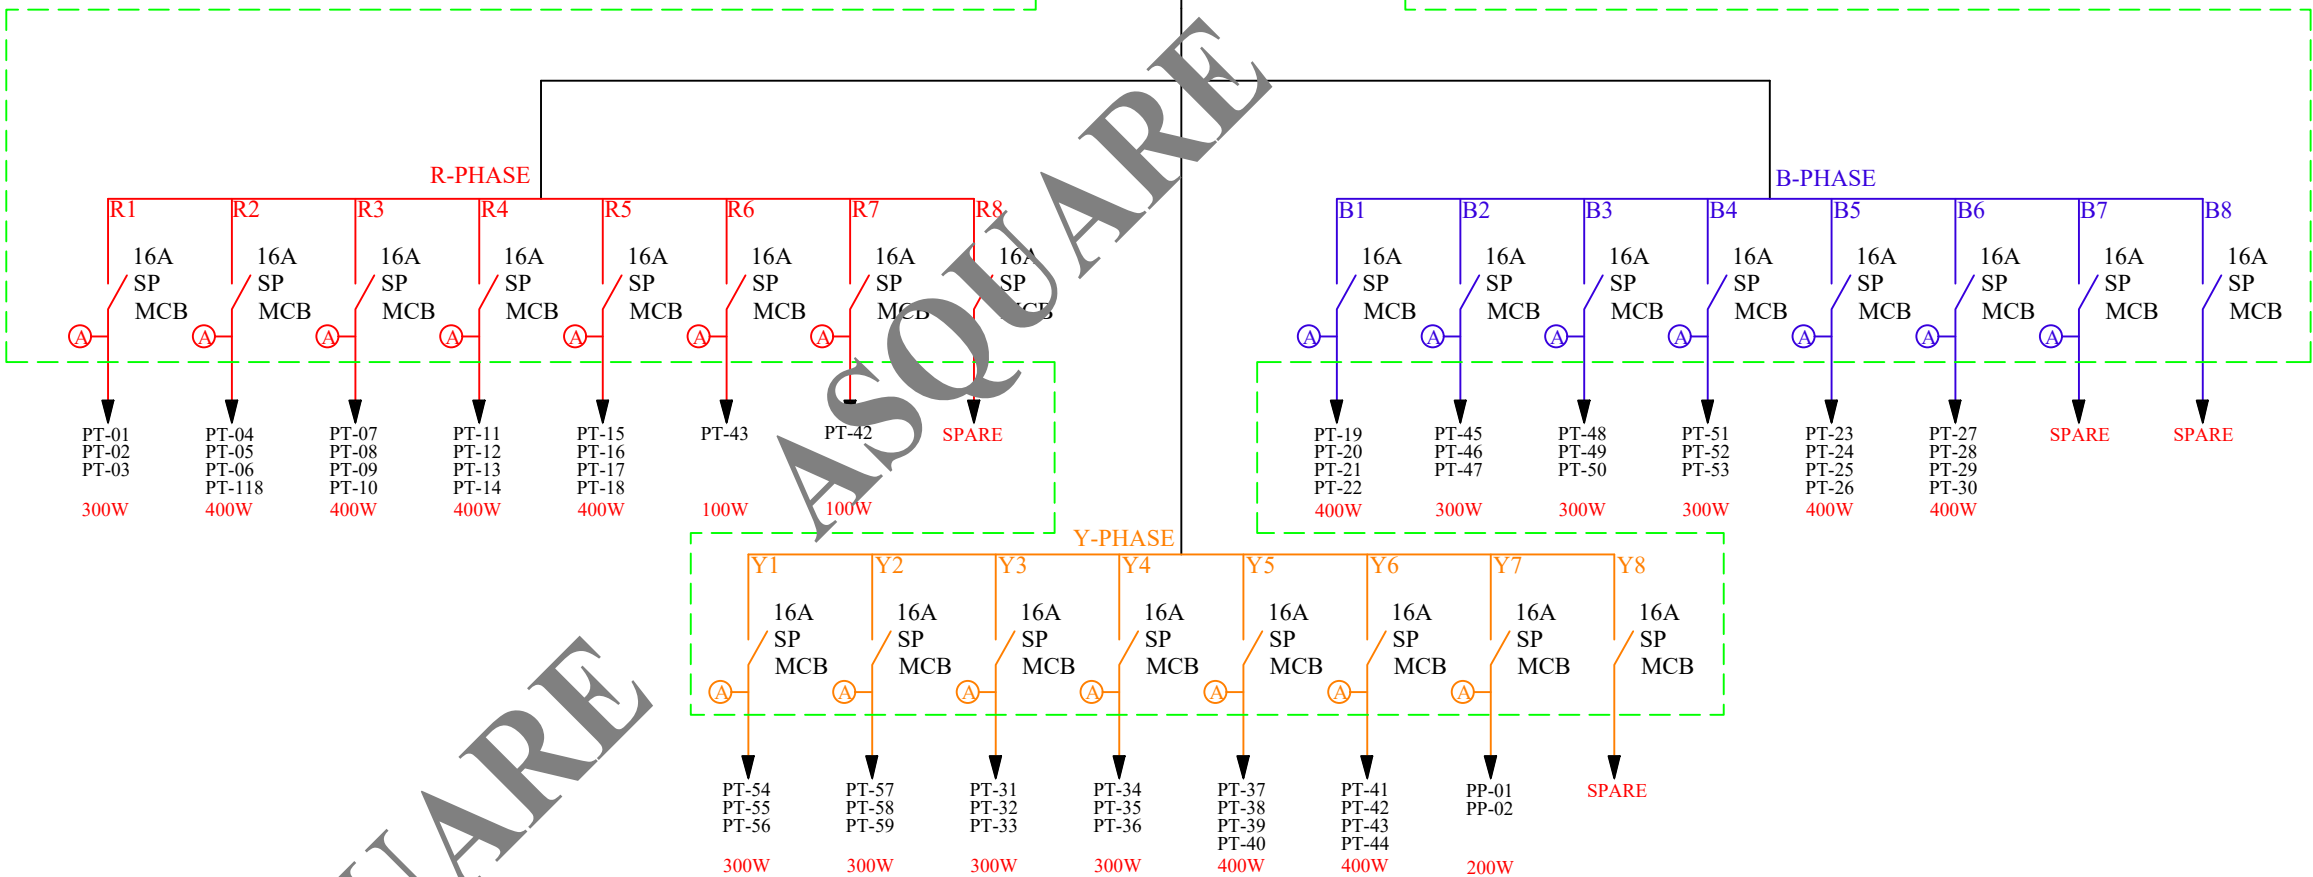

R-PHASE:- 2.10 KW  
Y-PHASE:- 2.20 KW  
B-PHASE:- 2.10 KW  
T.C.L :- 6.4 KW

MEP CONSULTANTS:



1st Floor, APR & MRS ARCADE,  
Vijayapura Road, Devanahalli,  
BENGALURU INDIA , 562110

A-SQUARE MEP Consultants (hereafter referred to as "A-SQUARE") retains all copyright and other proprietary rights to the drawings created by A-SQUARE. All drawings created by A-SQUARE are protected by Indian and international copyright laws. Any unauthorized reproduction, distribution, or modification of A-SQUARE's drawings is strictly prohibited. A-SQUARE reserves the right to take legal action against any unauthorized use of its drawings. A-SQUARE grants clients a limited, non-exclusive, non-transferable license to use the drawings for the specific project or purpose for which they were created. Clients may not use the drawings for any other purpose without the express written consent of A-SQUARE. Clients may not modify, reproduce, distribute, transmit, display, perform, publish, license, create derivative works from, transfer, or sell any of A-SQUARE's drawings without the prior written consent of A-SQUARE. Clients may not use any of A-SQUARE's drawings as a basis for the design or construction of any other project without the express written consent of A-SQUARE. Clients may not disclose any of A-SQUARE's drawings to any third party without the prior written consent of A-SQUARE. kindly visit our web-site, to know more.

GENERAL NOTES

- All dimensions are in millimeters (mm); follow written dimensions, do not scale.
- Drawings must be coordinated across all disciplines; report discrepancies before execution.
- Designs comply with NBC, ASHRAE, NEC, IPS, and other applicable architectural & MEP standards.
- Use only the latest issued drawings; verify all dimensions and site conditions before execution.

VERSION CHART

| VERSION NO. | VERSION DATE |
|-------------|--------------|
| APPROVAL-01 | 08-MAR-2025  |
| GFC         | 27-MAR-2025  |
|             |              |
|             |              |
|             |              |

ARCHITECT / INTERIOR CONSULTANT:



#12, 3RD FLOOR, 60FT ROAD,  
6TH BLOCK, KORMANGALA,  
BENGALURU 560034, INDIA

PROJECT:

ASTROME  
BRIGADE DECCAN HEIGHTS

ASTROME TECHNOLOGIES

ISSUED FOR:

GOOD FOR CONSTRUCTION

ISSUED DATE:

27-MAR-2025

DRAWN BY:

DA

CHECKED BY:

SK

APPROVED BY

AA

SHEET TITLE:

POWER DISTRIBUTION BAORD-01 SLD

SHEET SIZE:

A3

DRAWING NO:

ASC-ELE-ATM-008

PDB -03  
Loc. DB PANEL ROOM


Ⓐ—(2x4Sq.mm + 1x2.5 Sq.mm) Copper Wire

POWER DB SLD-02

8 Way  
Single Door  
TPN MCB DB

SUPPLY FROM  
ELECTRICAL PANEL

40A FP  
RCBO  
100mA

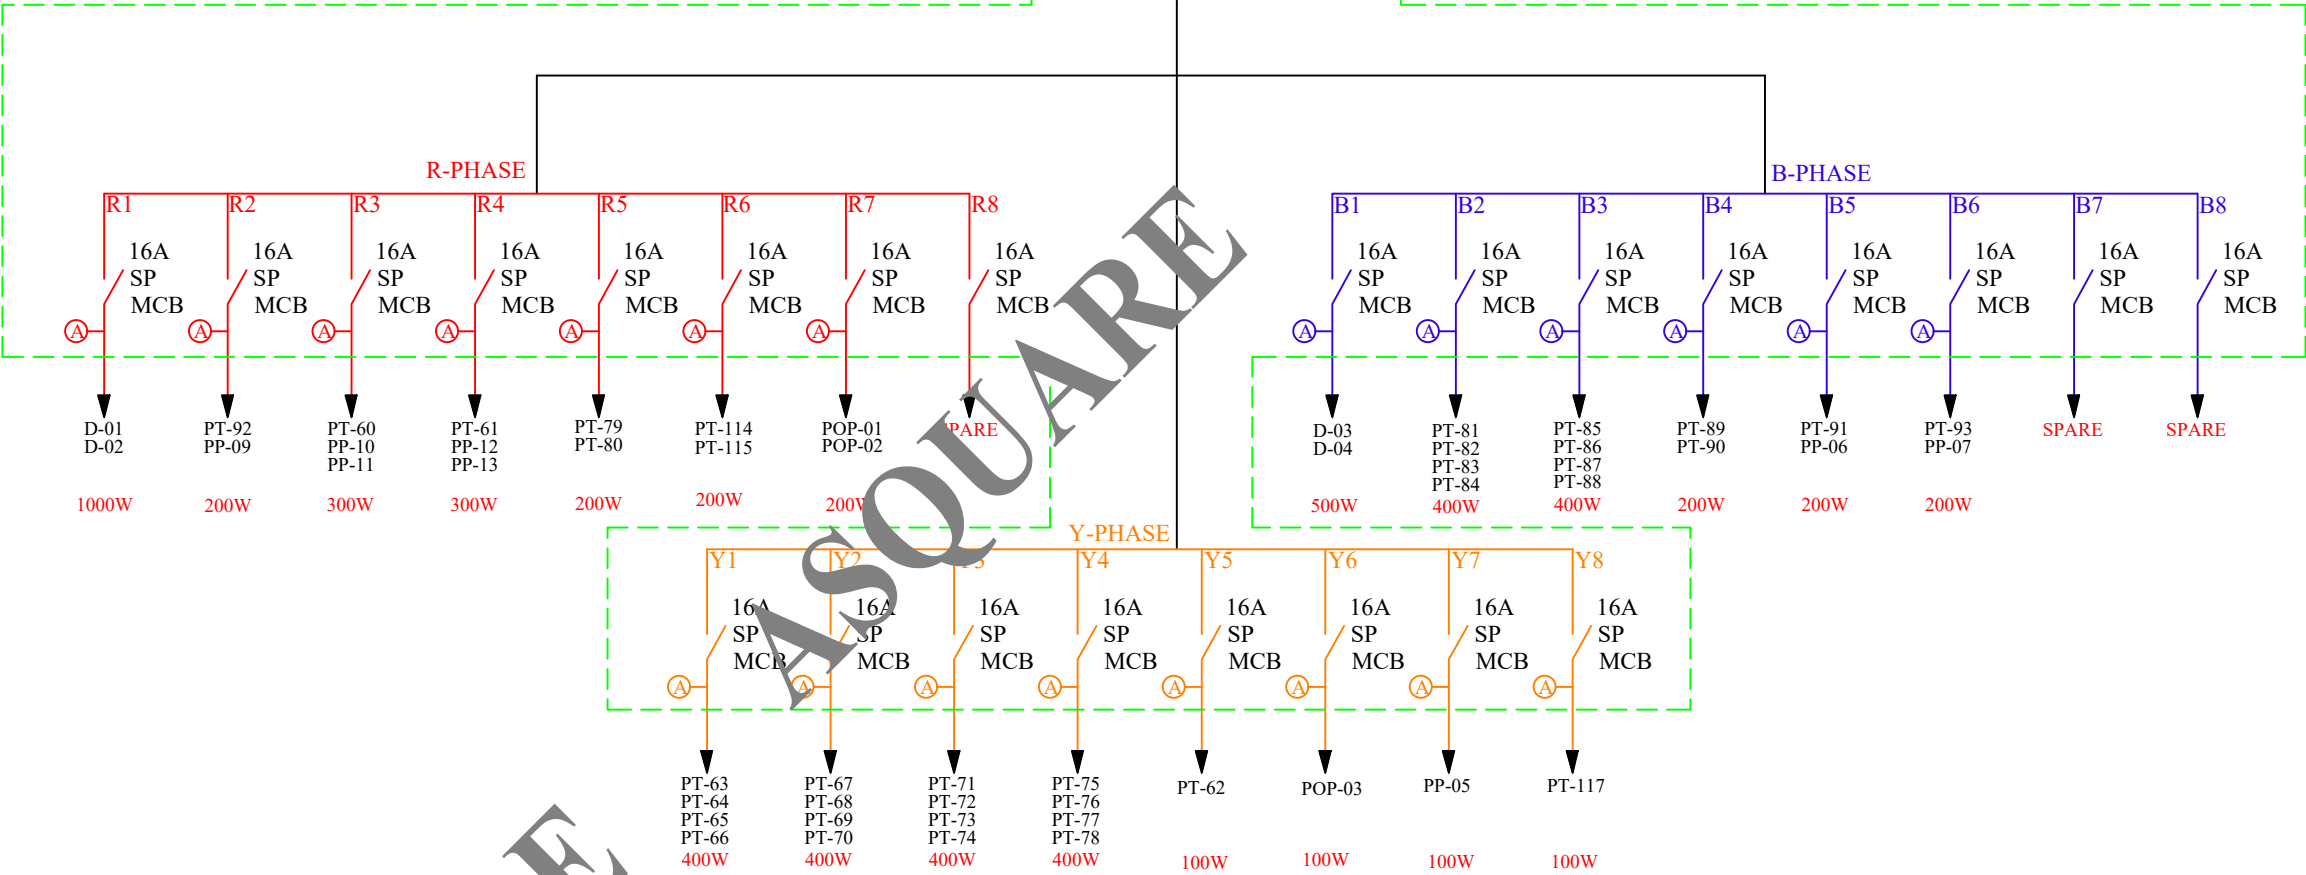

R-PHASE:- 1.90 KW  
Y-PHASE:- 2.00 KW  
B-PHASE:- 1.90 KW  
T.C.L :- 5.8 KW

MEP CONSULTANTS:



1st Floor, APR & MRS ARCADE,  
Vijayapura Road, Devanahalli,  
BENGALURU INDIA , 562110

A-SQUARE MEP Consultants (hereafter referred to as "A-SQUARE") retains all copyright and other proprietary rights to the drawings created by A-SQUARE. All drawings created by A-SQUARE are protected by Indian and international copyright laws. Any unauthorized reproduction, distribution, or modification of A-SQUARE's drawings is strictly prohibited. A-SQUARE reserves the right to take legal action against any unauthorized use of its drawings. A-SQUARE grants clients a limited, non-exclusive, non-transferable license to use the drawings for the specific project or purpose for which they were created. Clients may not use the drawings for any other purpose without the express written consent of A-SQUARE. Clients may not modify, reproduce, distribute, transmit, display, perform, publish, license, create derivative works from, transfer, or sell any of A-SQUARE's drawings without the prior written consent of A-SQUARE. Clients may not use any of A-SQUARE's drawings as a basis for the design or construction of any other project without the express written consent of A-SQUARE. Clients may not disclose any of A-SQUARE's drawings to any third party without the prior written consent of A-SQUARE. kindly visit our web-site, to know more.

GENERAL NOTES

- All dimensions are in millimeters (mm); follow written dimensions, do not scale.
- Drawings must be coordinated across all disciplines; report discrepancies before execution.
- Designs comply with NBC, ASHRAE, NEC, IPS, and other applicable architectural & MEP standards.
- Use only the latest issued drawings; verify all dimensions and site conditions before execution.

VERSION CHART

| VERSION NO. | VERSION DATE |
|-------------|--------------|
| APPROVAL-01 | 08-MAR-2025  |
| GFC         | 27-MAR-2025  |
|             |              |
|             |              |
|             |              |

ARCHITECT / INTERIOR CONSULTANT:



#12, 3RD FLOOR, 60FT ROAD,  
6TH BLOCK, KORMANGALA,  
BENGALURU 560034, INDIA

PROJECT:

ASTROME  
BRIGADE DECCAN HEIGHTS

ASTROME TECHNOLOGIES

ISSUED FOR:

GOOD FOR CONSTRUCTION

ISSUED DATE:

27-MAR-2025

DRAWN BY:

DA

CHECKED BY:

SK

APPROVED BY

AA

SHEET TITLE:

POWER DISTRIBUTION BAORD-02 SLD

SHEET SIZE:

A3

DRAWING NO:

ASC-ELE-ATM-008-A

PDB -03  
Loc. DB PANEL ROOM


Ⓐ—(2x4Sq.mm + 1x2.5 Sq.mm) Copper Wire

## POWER DB SLD-03

SUPPLY FROM  
ELECTRICAL PANEL

40A FP  
RCBO  
100mA

8 Way  
Single Door  
TPN MCB DB

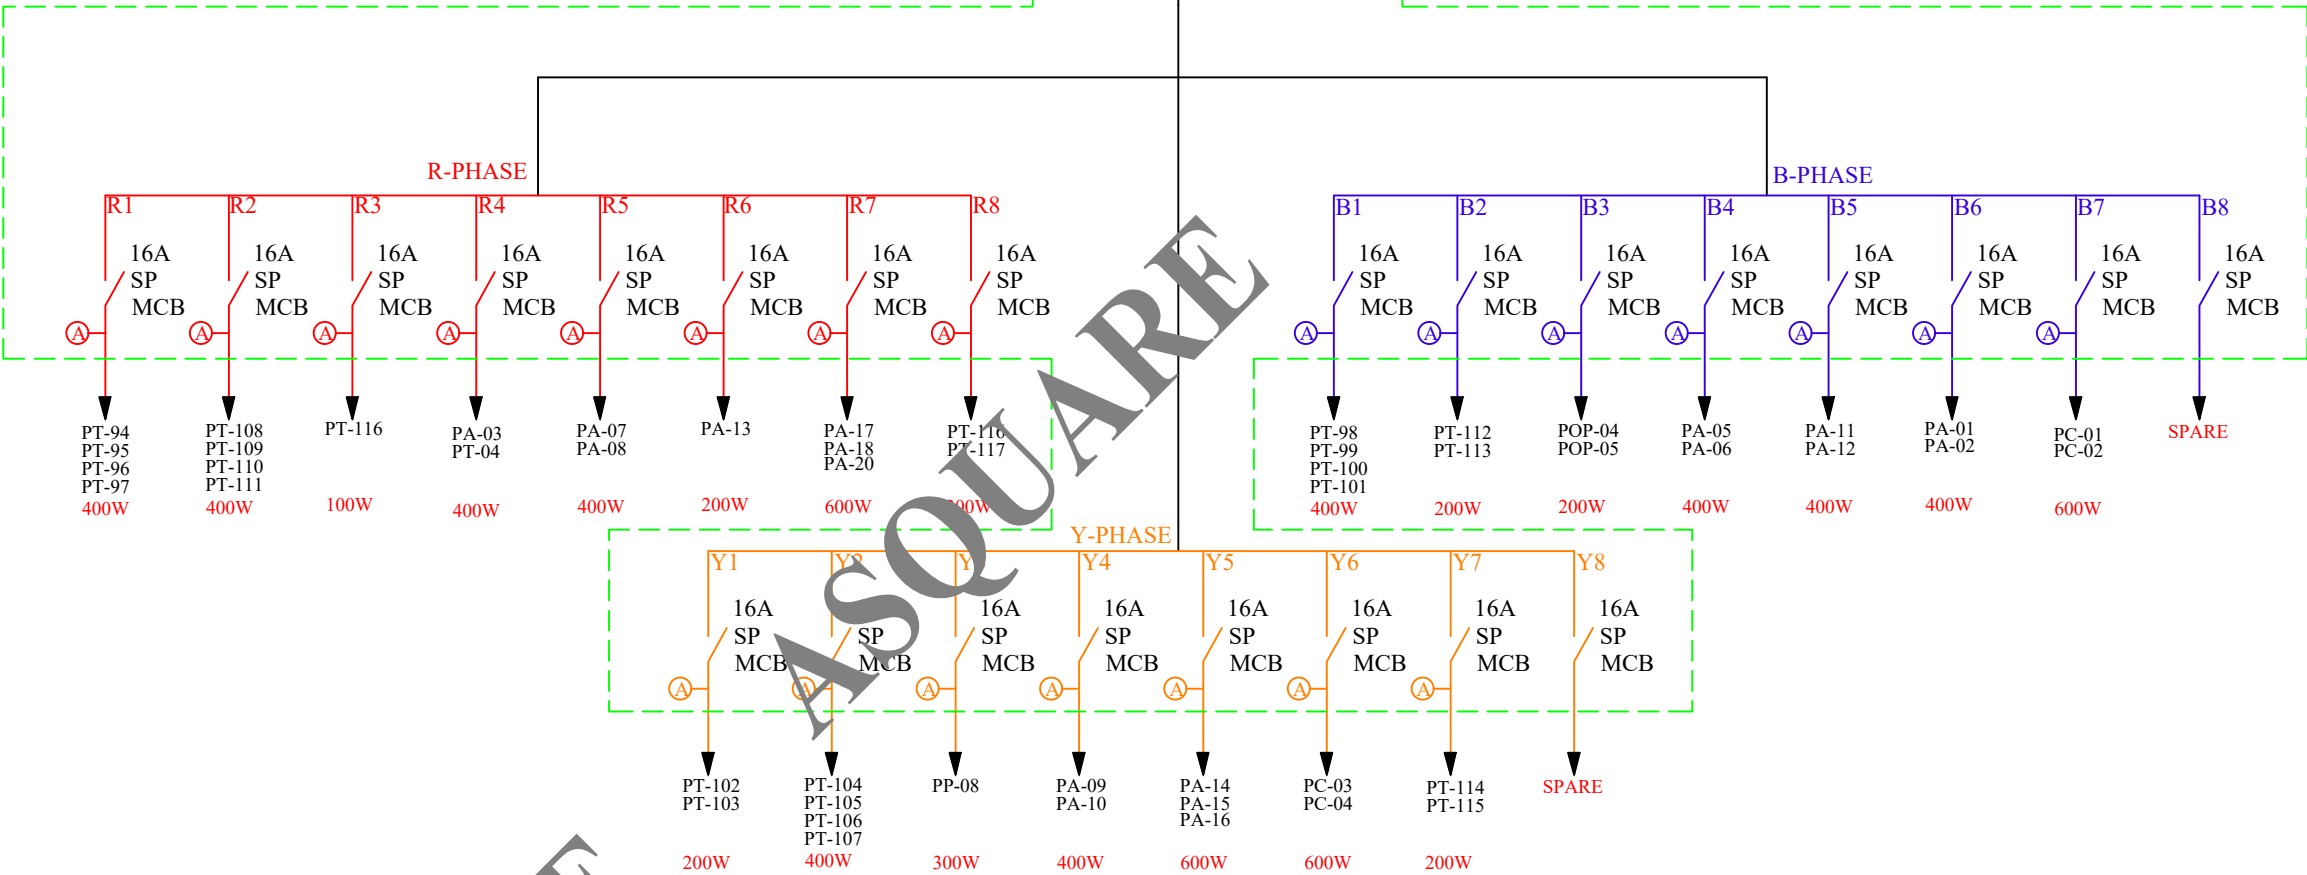

R-PHASE:- 2.70 KW  
Y-PHASE:- 2.70 KW  
B-PHASE:- 2.60 KW  
T.C.L :- 8.00 KW

MEP CONSULTANTS:



1st Floor, APR & MRS ARCADE,  
Vijayapura Road, Devanahalli,  
BENGALURU INDIA , 562110

A-SQUARE MEP Consultants (hereafter referred to as "A-SQUARE") retains all copyright and other proprietary rights to the drawings created by A-SQUARE. All drawings created by A-SQUARE are protected by Indian and international copyright laws. Any unauthorized reproduction, distribution, or modification of A-SQUARE's drawings is strictly prohibited. A-SQUARE reserves the right to take legal action against any unauthorized use of its drawings. A-SQUARE grants clients a limited, non-exclusive, non-transferable license to use the drawings for the specific project or purpose for which they were created. Clients may not use the drawings for any other purpose without the express written consent of A-SQUARE. Clients may not modify, reproduce, distribute, transmit, display, perform, publish, license, create derivative works from, transfer, or sell any of A-SQUARE's drawings without the prior written consent of A-SQUARE. Clients may not use any of A-SQUARE's drawings as a basis for the design or construction of any other project without the express written consent of A-SQUARE. Clients may not disclose any of A-SQUARE's drawings to any third party without the prior written consent of A-SQUARE. kindly visit our web-site, to know more.

### GENERAL NOTES

- All dimensions are in millimeters (mm); follow written dimensions, do not scale.
- Drawings must be coordinated across all disciplines; report discrepancies before execution.
- Designs comply with NBC, ASHRAE, NEC, IPS, and other applicable architectural & MEP standards.
- Use only the latest issued drawings; verify all dimensions and site conditions before execution.

### VERSION CHART

| VERSION NO. | VERSION DATE |
|-------------|--------------|
| APPROVAL-01 | 08-MAR-2025  |
| GFC         | 27-MAR-2025  |
|             |              |
|             |              |
|             |              |

ARCHITECT / INTERIOR CONSULTANT:



#12, 3RD FLOOR, 60FT ROAD,  
6TH BLOCK, KORMANGALA,  
BENGALURU 560034, INDIA

PROJECT:

ASTROME  
BRIGADE DECCAN HEIGHTS

ASTROME TECHNOLOGIES

ISSUED FOR:

GOOD FOR CONSTRUCTION

ISSUED DATE:

27-MAR-2025

DRAWN BY:

DA

CHECKED BY:

SK

APPROVED BY

AA

SHEET TITLE:

POWER DISTRIBUTION BAORD-03 SLD

SHEET SIZE:

A3

DRAWING NO:

ASC-ELE-ATM-008-B



PDB -01  
Loc. DB PANEL ROOM


Ⓐ—(2x4Sq.mm + 1x2.5 Sq.mm) Copper Wire

# LIGHT DB SLD

6 Way  
Single Door  
TPN MCB DB

SUPPLY FROM  
ELECTRICAL PANEL

32A FP  
RCBO  
30mA

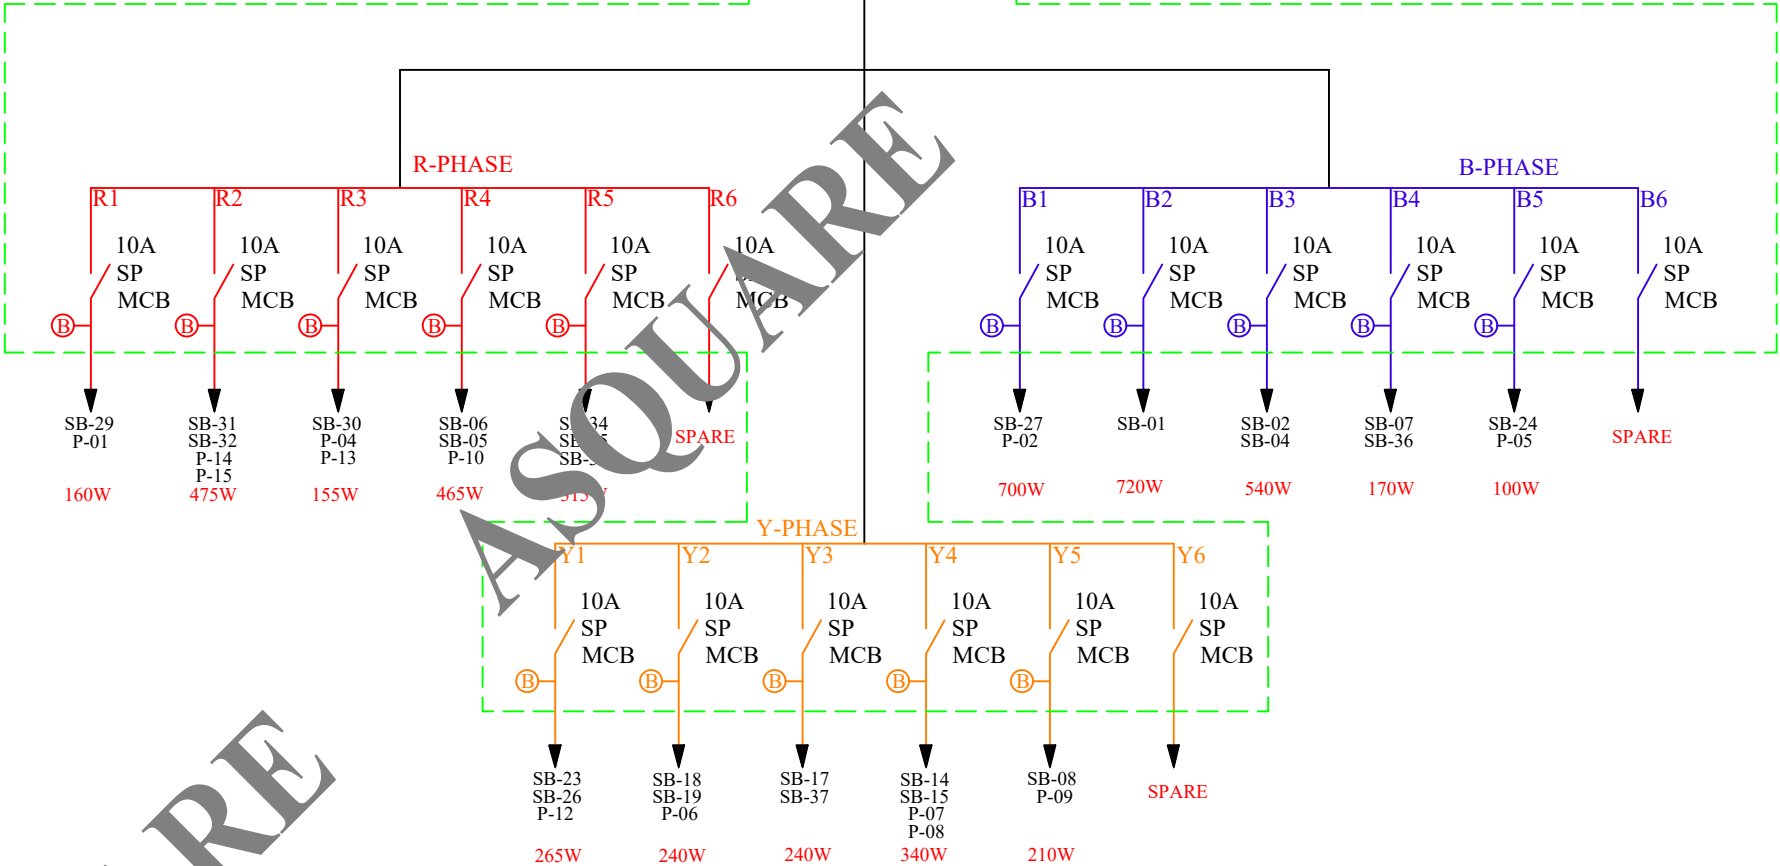

R-PHASE:- 1.06 KW  
Y-PHASE:- 1.18KW  
B-PHASE:- 1.39 KW  
T.C.L :- 3.51 KW

MEP CONSULTANTS:



1st Floor, APR & MRS ARCADE,  
Vijayapura Road, Devanahalli,  
BENGALURU INDIA , 562110

A-SQUARE MEP Consultants (hereafter referred to as "A-SQUARE") retains all copyright and other proprietary rights to the drawings created by A-SQUARE. All drawings created by A-SQUARE are protected by Indian and international copyright laws. Any unauthorized reproduction, distribution, or modification of A-SQUARE's drawings is strictly prohibited. A-SQUARE reserves the right to take legal action against any unauthorized use of its drawings. A-SQUARE grants clients a limited, non-exclusive, non-transferable license to use the drawings for the specific project or purpose for which they were created. Clients may not use the drawings for any other purpose without the express written consent of A-SQUARE. Clients may not modify, reproduce, distribute, transmit, display, perform, publish, license, create derivative works from, transfer, or sell any of A-SQUARE's drawings without the prior written consent of A-SQUARE. Clients may not use any of A-SQUARE's drawings as a basis for the design or construction of any other project without the express written consent of A-SQUARE. Clients may not disclose any of A-SQUARE's drawings to any third party without the prior written consent of A-SQUARE. kindly visit our web-site, to know more.

## GENERAL NOTES

- All dimensions are in millimeters (mm); follow written dimensions, do not scale.
- Drawings must be coordinated across all disciplines; report discrepancies before execution.
- Designs comply with NBC, ASHRAE, NEC, IPS, and other applicable architectural & MEP standards.
- Use only the latest issued drawings; verify all dimensions and site conditions before execution.

## VERSION CHART

| VERSION NO. | VERSION DATE |
|-------------|--------------|
| APPROVAL-01 | 08-MAR-2025  |
| GFC         | 27-MAR-2025  |
|             |              |
|             |              |
|             |              |

ARCHITECT / INTERIOR CONSULTANT:



#12, 3RD FLOOR, 60FT ROAD,  
6TH BLOCK, KORMANGALA,  
BENGALURU 560034, INDIA

PROJECT:

ASTROME  
BRIGADE DECCAN HEIGHTS

ASTROME TECHNOLOGIES

ISSUED FOR:

GOOD FOR CONSTRUCTION

ISSUED DATE:

27-MAR-2025

DRAWN BY:

DA

CHECKED BY:

SK

APPROVED BY

AA

SHEET TITLE:

LIGHT DISTRIBUTION BAORD- SLD

SHEET SIZE:

A3

DRAWING NO:

ASC-ELE-ATM-006


UPS SPN DB  
Loc. DB PANEL ROOM

Ⓐ—(2x4Sq.mm + 1x2.5 Sq.mm) Copper Wire

Ⓑ—(2x2.5Sq.mm + 1x1.5 Sq.mm) Copper Wire

12 Way  
Single Door  
SPN MCB DB

UPS SPN DB

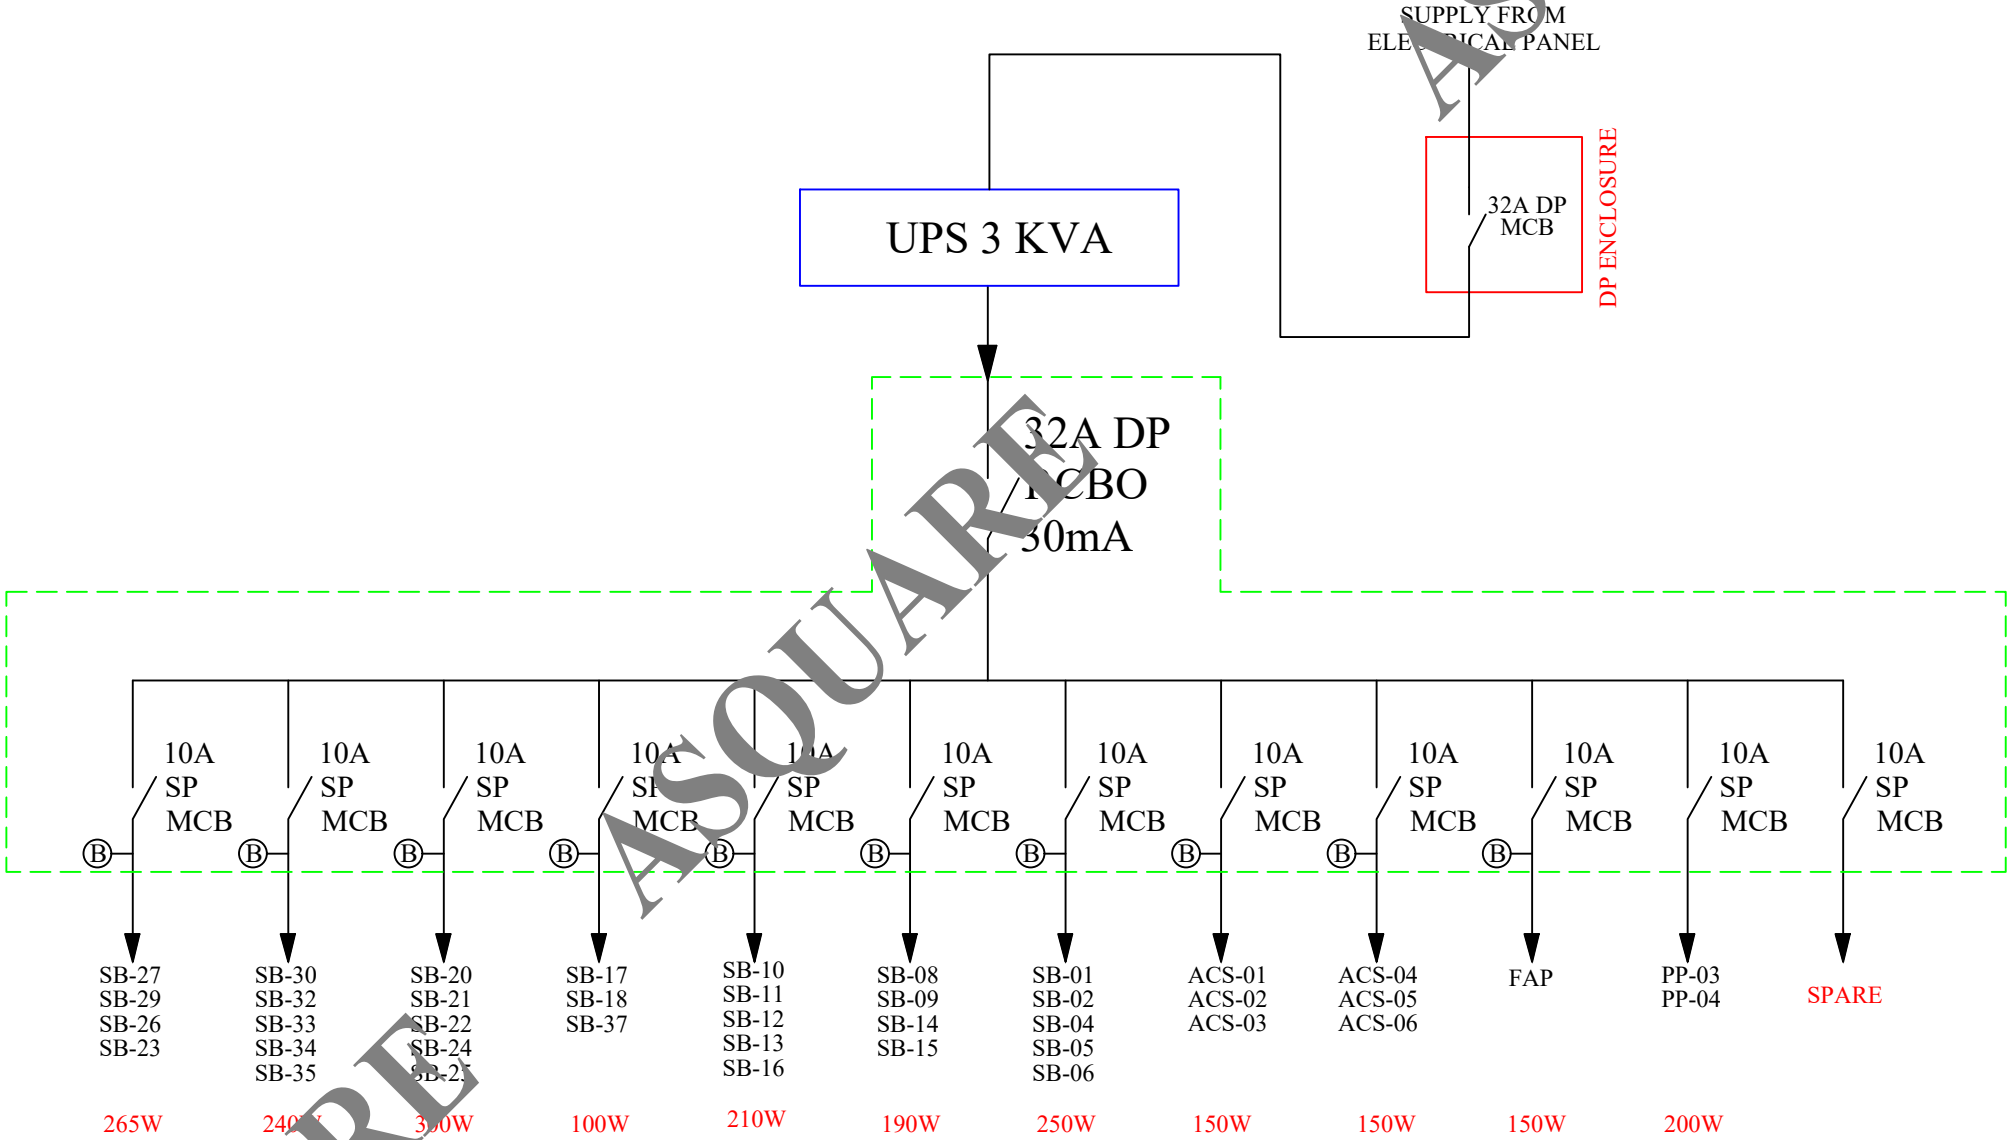

T.C.L :- 2.19 KW

MEP CONSULTANTS:



1st Floor, APR & MRS ARCADE,  
Vijayapura Road, Devanahalli,  
BENGALURU INDIA , 562110

A-SQUARE MEP Consultants (hereafter referred to as "A-SQUARE") retains all copyright and other proprietary rights to the drawings created by A-SQUARE. All drawings created by A-SQUARE are protected by Indian and international copyright laws. Any unauthorized reproduction, distribution, or modification of A-SQUARE's drawings is strictly prohibited. A-SQUARE reserves the right to take legal action against any unauthorized use of its drawings. A-SQUARE grants clients a limited, non-exclusive, non-transferable license to use the drawings for the specific project or purpose for which they were created. Clients may not use the drawings for any other purpose without the express written consent of A-SQUARE. Clients may not modify, reproduce, distribute, transmit, display, perform, publish, license, create derivative works from, transfer, or sell any of A-SQUARE's drawings without the prior written consent of A-SQUARE. Clients may not use any of A-SQUARE's drawings as a basis for the design or construction of any other project without the express written consent of A-SQUARE. Clients may not disclose any of A-SQUARE's drawings to any third party without the prior written consent of A-SQUARE. kindly visit our web-site, to know more.

GENERAL NOTES

- All dimensions are in millimeters (mm); follow written dimensions, do not scale.
- Drawings must be coordinated across all disciplines; report discrepancies before execution.
- Designs comply with NBC, ASHRAE, NEC, IPS, and other applicable architectural & MEP standards.
- Use only the latest issued drawings; verify all dimensions and site conditions before execution.

VERSION CHART

| VERSION NO. | VERSION DATE |
|-------------|--------------|
| APPROVAL-01 | 08-MAR-2025  |
| GFC         | 27-MAR-2025  |
|             |              |
|             |              |
|             |              |

ARCHITECT / INTERIOR CONSULTANT:



#12, 3RD FLOOR, 60FT ROAD,  
6TH BLOCK, KORMANGALA,  
BENGALURU 560034, INDIA

PROJECT:

ASTROME  
BRIGADE DECCAN HEIGHTS

ASTROME TECHNOLOGIES

ISSUED FOR:

GOOD FOR CONSTRUCTION

ISSUED DATE:

27-MAR-2025

DRAWN BY:

DA

CHECKED BY:

SK

APPROVED BY

AA

SHEET TITLE:

UPS-DB- SLD

SHEET SIZE:

A3

DRAWING NO:

ASC-ELE-ATM-007

MAIN ELECTRICAL PANEL

MEP CONSULTANTS:



1st Floor, APR & MRS ARCADE,  
Vijayapura Road, Devanahalli,  
BENGALURU INDIA , 562110

A-SQUARE MEP Consultants (hereafter referred to as "A-SQUARE") retains all copyright and other proprietary rights to the drawings created by A-SQUARE. All drawings created by A-SQUARE are protected by Indian and international copyright laws. Any unauthorized reproduction, distribution, or modification of A-SQUARE's drawings is strictly prohibited. A-SQUARE reserves the right to take legal action against any unauthorized use of its drawings. A-SQUARE grants clients a limited, non-exclusive, non-transferable license to use the drawings for the specific project or purpose for which they were created. Clients may not use the drawings for any other purpose without the express written consent of A-SQUARE. Clients may not modify, reproduce, distribute, transmit, display, perform, publish, license, create derivative works from, transfer, or sell any of A-SQUARE's drawings without the prior written consent of A-SQUARE. Clients may not use any of A-SQUARE's drawings as a basis for the design or construction of any other project without the express written consent of A-SQUARE. Clients may not disclose any of A-SQUARE's drawings to any third party without the prior written consent of A-SQUARE. kindly visit our web-site, to know more.

GENERAL NOTES

- All dimensions are in millimeters (mm); follow written dimensions, do not scale.
- Drawings must be coordinated across all disciplines; report discrepancies before execution.
- Designs comply with NBC, ASHRAE, NEC, IPS, and other applicable architectural & MEP standards.
- Use only the latest issued drawings; verify all dimensions and site conditions before execution.

VERSION CHART

| VERSION NO. | VERSION DATE |
|-------------|--------------|
| APPROVAL-01 | 08-MAR-2025  |
| GFC         | 27-MAR-2025  |
|             |              |
|             |              |
|             |              |

ARCHITECT / INTERIOR CONSULTANT:



#12, 3RD FLOOR, 60FT ROAD,  
6TH BLOCK, KORMANGALA,  
BENGALURU 560034, INDIA

PROJECT:

ASTROME  
BRIGADE DECCAN HEIGHTS

ASTROME TECHNOLOGIES

ISSUED FOR:

GOOD FOR CONSTRUCTION

ISSUED DATE:

27-MAR-2025

DRAWN BY:

DA

CHECKED BY:

SK

APPROVED BY

AA

SHEET TITLE:


MAIN ELECTRICAL PANEL-SLD

SHEET SIZE:

A3

DRAWING NO:

ASC-ELE-ATM-009



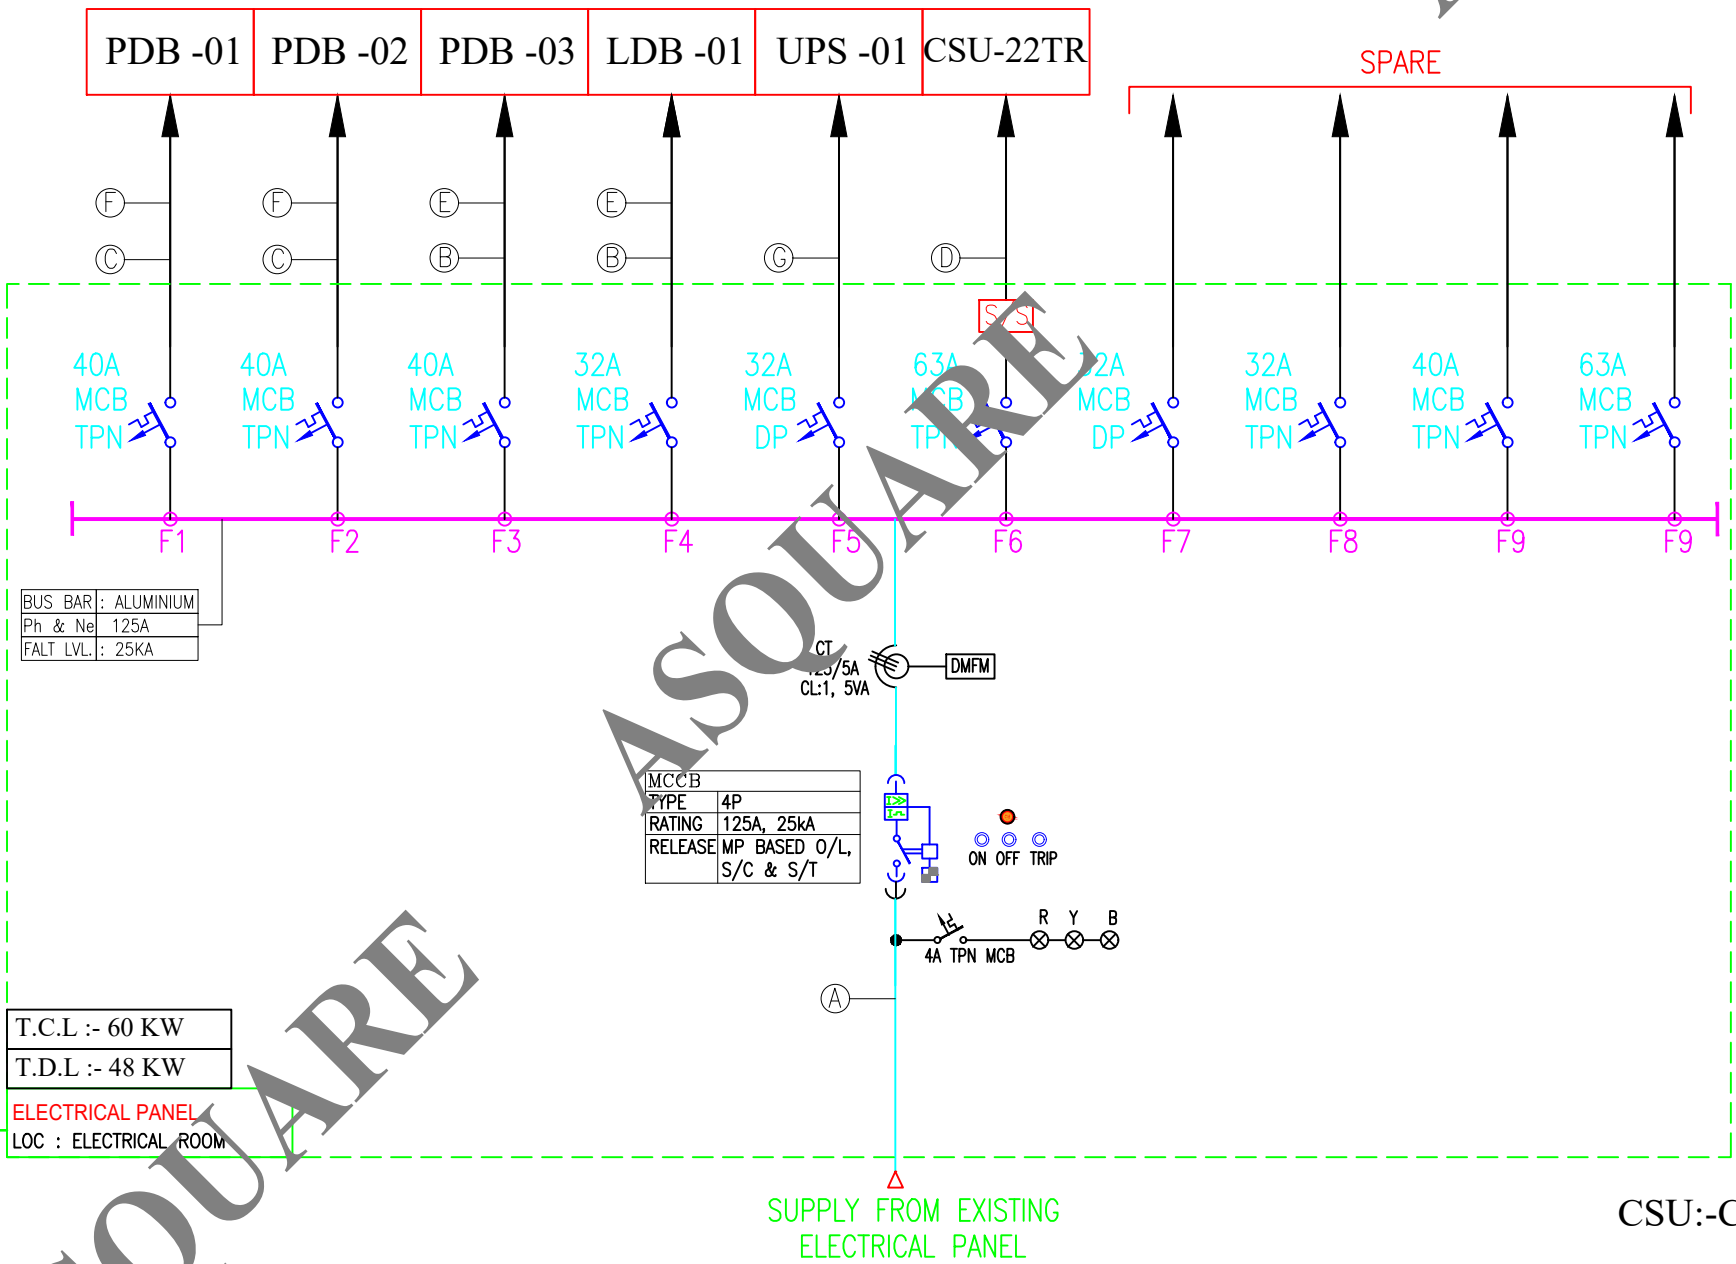




GENERAL NOTES

- 1) R,Y & ,B INDICATES PHASES
- 2) The number written near the switch board and power point indicates circuit number, for details of circuits refer distribution board chart
- 3) The size of the wire from switch board to light and fan should be 1.5 sq mm
- 4) For the secondary power point the circuit wire shall be loopedfrom first power point by 2\*2.5 sq mm
- 5) PVC junction box size as per conduct size
- 6) Light and power circuit should be drawn in seperate conduit
- 7) The opening inside electricals , lv & fire shaft should be sealed at each floor
- 8) No two disimilar phase circuit / wire shall run together through same conduit
- 9) The position mentioned in the legend is bottom of the switch board
- 10)The conduit using for wiring shall be as follows
- a) PVC -heavy duty (2mm thick ) : in R.C.C SLAB
- b) PVC -medium duty (1.5mm thick ) : in brick wall
- c) The minimum conduit size in RCC Slab shall be :25mm dia
- 11) EV Churching wire 2.5sq mm and earthen wire 2.5sqmm 25Ømm pvc conduit
- 12) 6 AMP socket shall be connected to the lighting ckt of that area

   LEGEND

| SYMBOL                                                                                   | SB MODELS                                                                           | DESCRIPTION                                                                           |
|------------------------------------------------------------------------------------------|-------------------------------------------------------------------------------------|---------------------------------------------------------------------------------------|
|       |  | 6A SOCKET CONNECTED TO RAW POWER                                                      |
|       |  | 6/16A SOCKET CONNECTED TO UPS POWER                                                   |
|       |  | 16A SOCKET CONNECTED TO UPS POWER                                                     |
|       |  | 6A TWO SOCKET CONNECTED TO RAW POWER                                                  |
|       |                                                                                     | LIGHTING POINT @1350mm LVL ON THE WALL FOR TRAIL RM.MOROR COE LIGHTING                |
|       |  | RJ-45 DATA OUTLET                                                                     |
|       |  | RJ-11 TELEPHONE OUTLET                                                                |
|       |  | 1A SOCKET CONNECTED TO RAW POWER                                                      |
|       |  | INDICATES ONE WAY 6A SP SWITCH CONTROL FOR LIGHTS 1350MM LVL                          |
|       |                                                                                     | CELLING MOUNTING FAN                                                                  |
|       |                                                                                     | RAW POWER CIRCUIT MAIN - 2x4.0 + 1x2.5Sqmm FRLS wires in 20mmØ conduit                |
|       |                                                                                     | LIGHTING CIRCUIT R,Y,B 2X4.0+1X1.5 SQ MM WIRES 25 MM Ø CONDUIT                        |
|       |  | WALL MOUNTING EXHAUST FAN                                                             |
|       |  | INTEGRATED PANEL-1 INCLUDES 3 GANG OF 5/13A SOCKET WITH 20 A SWITCH, DATA & TEL SOCK. |
|     |                                                                                     | DISTRIBUTION BOARD                                                                    |
|     |                                                                                     | EXTRA LOW VOLTAGE DB                                                                  |
| 17  |                                                                                     | SWITCH BOARD                                                                          |
|     |                                                                                     | WALL MOUNTED LIGHT                                                                    |
|     |                                                                                     | LOW WALL LIGHT                                                                        |
|     |                                                                                     | CELLING MOUNTED LIGHT                                                                 |
|     | MB                                                                                  | METER BOARD                                                                           |
|     |                                                                                     | BELL                                                                                  |
|     |                                                                                     | BELL PUSH POINT                                                                       |
|     |                                                                                     | 20A SOCKET CONNECTED TO RAW POWER                                                     |
|     |                                                                                     | CHANDELIER / HANGING LIGHT                                                            |
|     |                                                                                     | LED FLOOR MOUNTED LIGHT                                                               |
|     |                                                                                     | FURNITURE MOUNTED SOCKET                                                              |
|     |                                                                                     | ONE WAY PVC JUNCTION BOX                                                              |
|     |                                                                                     | TWO WAY PVC JUNCTION BOX                                                              |
|     |                                                                                     | THREE WAY PVC JUNCTION BOX                                                            |
|     |                                                                                     | FOUR WAY PVC JUNCTION BOX                                                             |
|     |                                                                                     | TWO WAY PVC JUNCTION BOX                                                              |
|     |                                                                                     | CONDUIT DROP                                                                          |
|     |                                                                                     | PVC CONDUIT VERTICAL DROP                                                             |
|     |                                                                                     | INVERTER 25MM CONDUIT                                                                 |

GOOD FOR CONSTRUCTION

Issued by: \_\_\_\_\_  
Issued Date: 03 OCT 2024


COPYRIGHT POLICY

A-SQUARE MEP Consultants (hereafter referred to as "A-SQUARE" retains all copyright and other proprietary rights to the drawings created by A-SQUARE. All drawings created by A-SQUARE are protected by Indian and international copyright laws. Any unauthorized reproduction, distribution, or modification of A-SQUARE's drawings is strictly prohibited. A-SQUARE reserves the right to take legal action against any unauthorized use of its drawings. A-SQUARE grants clients a limited, non-exclusive, non-transferable license to use the drawings for the specific project or purpose for which they were created. Clients may not use the drawings for any other purpose without the express written consent of A-SQUARE. Clients may not modify, reproduce, distribute, transmit, display, perform, publish, license, create derivative works from, transfer, or sell any of A-SQUARE's drawings without the prior written consent of A-SQUARE. Clients may not use any of A-SQUARE's drawings as a basis for the design or construction of any other project without the express written consent of A-SQUARE. Clients may not disclose any of A-SQUARE's drawings to any third party without the prior written consent of A-SQUARE. kindly visit our web-site, to know more.

REVISION CHART

|   | REVISION DATE | REV. NO. |
|---|---------------|----------|
| 1 | 03 AUG 2024   | R0       |
| 2 | 19 AUG 2024   | R1       |
| 3 | 07 SEP 2024   | R2       |
| 4 | 10 OCT 2024   | R3       |

ENGINEERING CONSULTANTS:

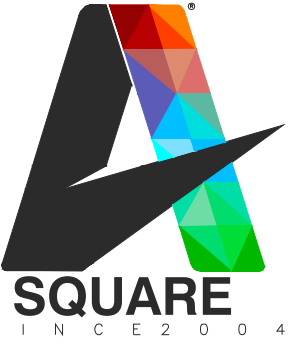

G-31, CEDAR BUILDING, BRIGADE ORCHARDS, SPINAL ROAD, DEVANAHALLI, BANGALORE-562110  
Email: Support@a-square.group  
Contact No: +91 9845208299  
www.a-sqaure.group

ARCHITECT NAME

INNOBUILD LANDHOLDINGS

PROJECT NAME:

ALAKANANDA APARTMENTA -AT KAVALI


DRAWING TITLE:

ELECTRICAL SPECIFICATIONS

|      |       |       |
|------|-------|-------|
| DRWN | CHD   | APPD  |
| M.F  | ABDUL | ALTAF |

|       |            |      |
|-------|------------|------|
| SCALE | SHEET SIZE | REV. |
| NTS   | A1         | R3   |



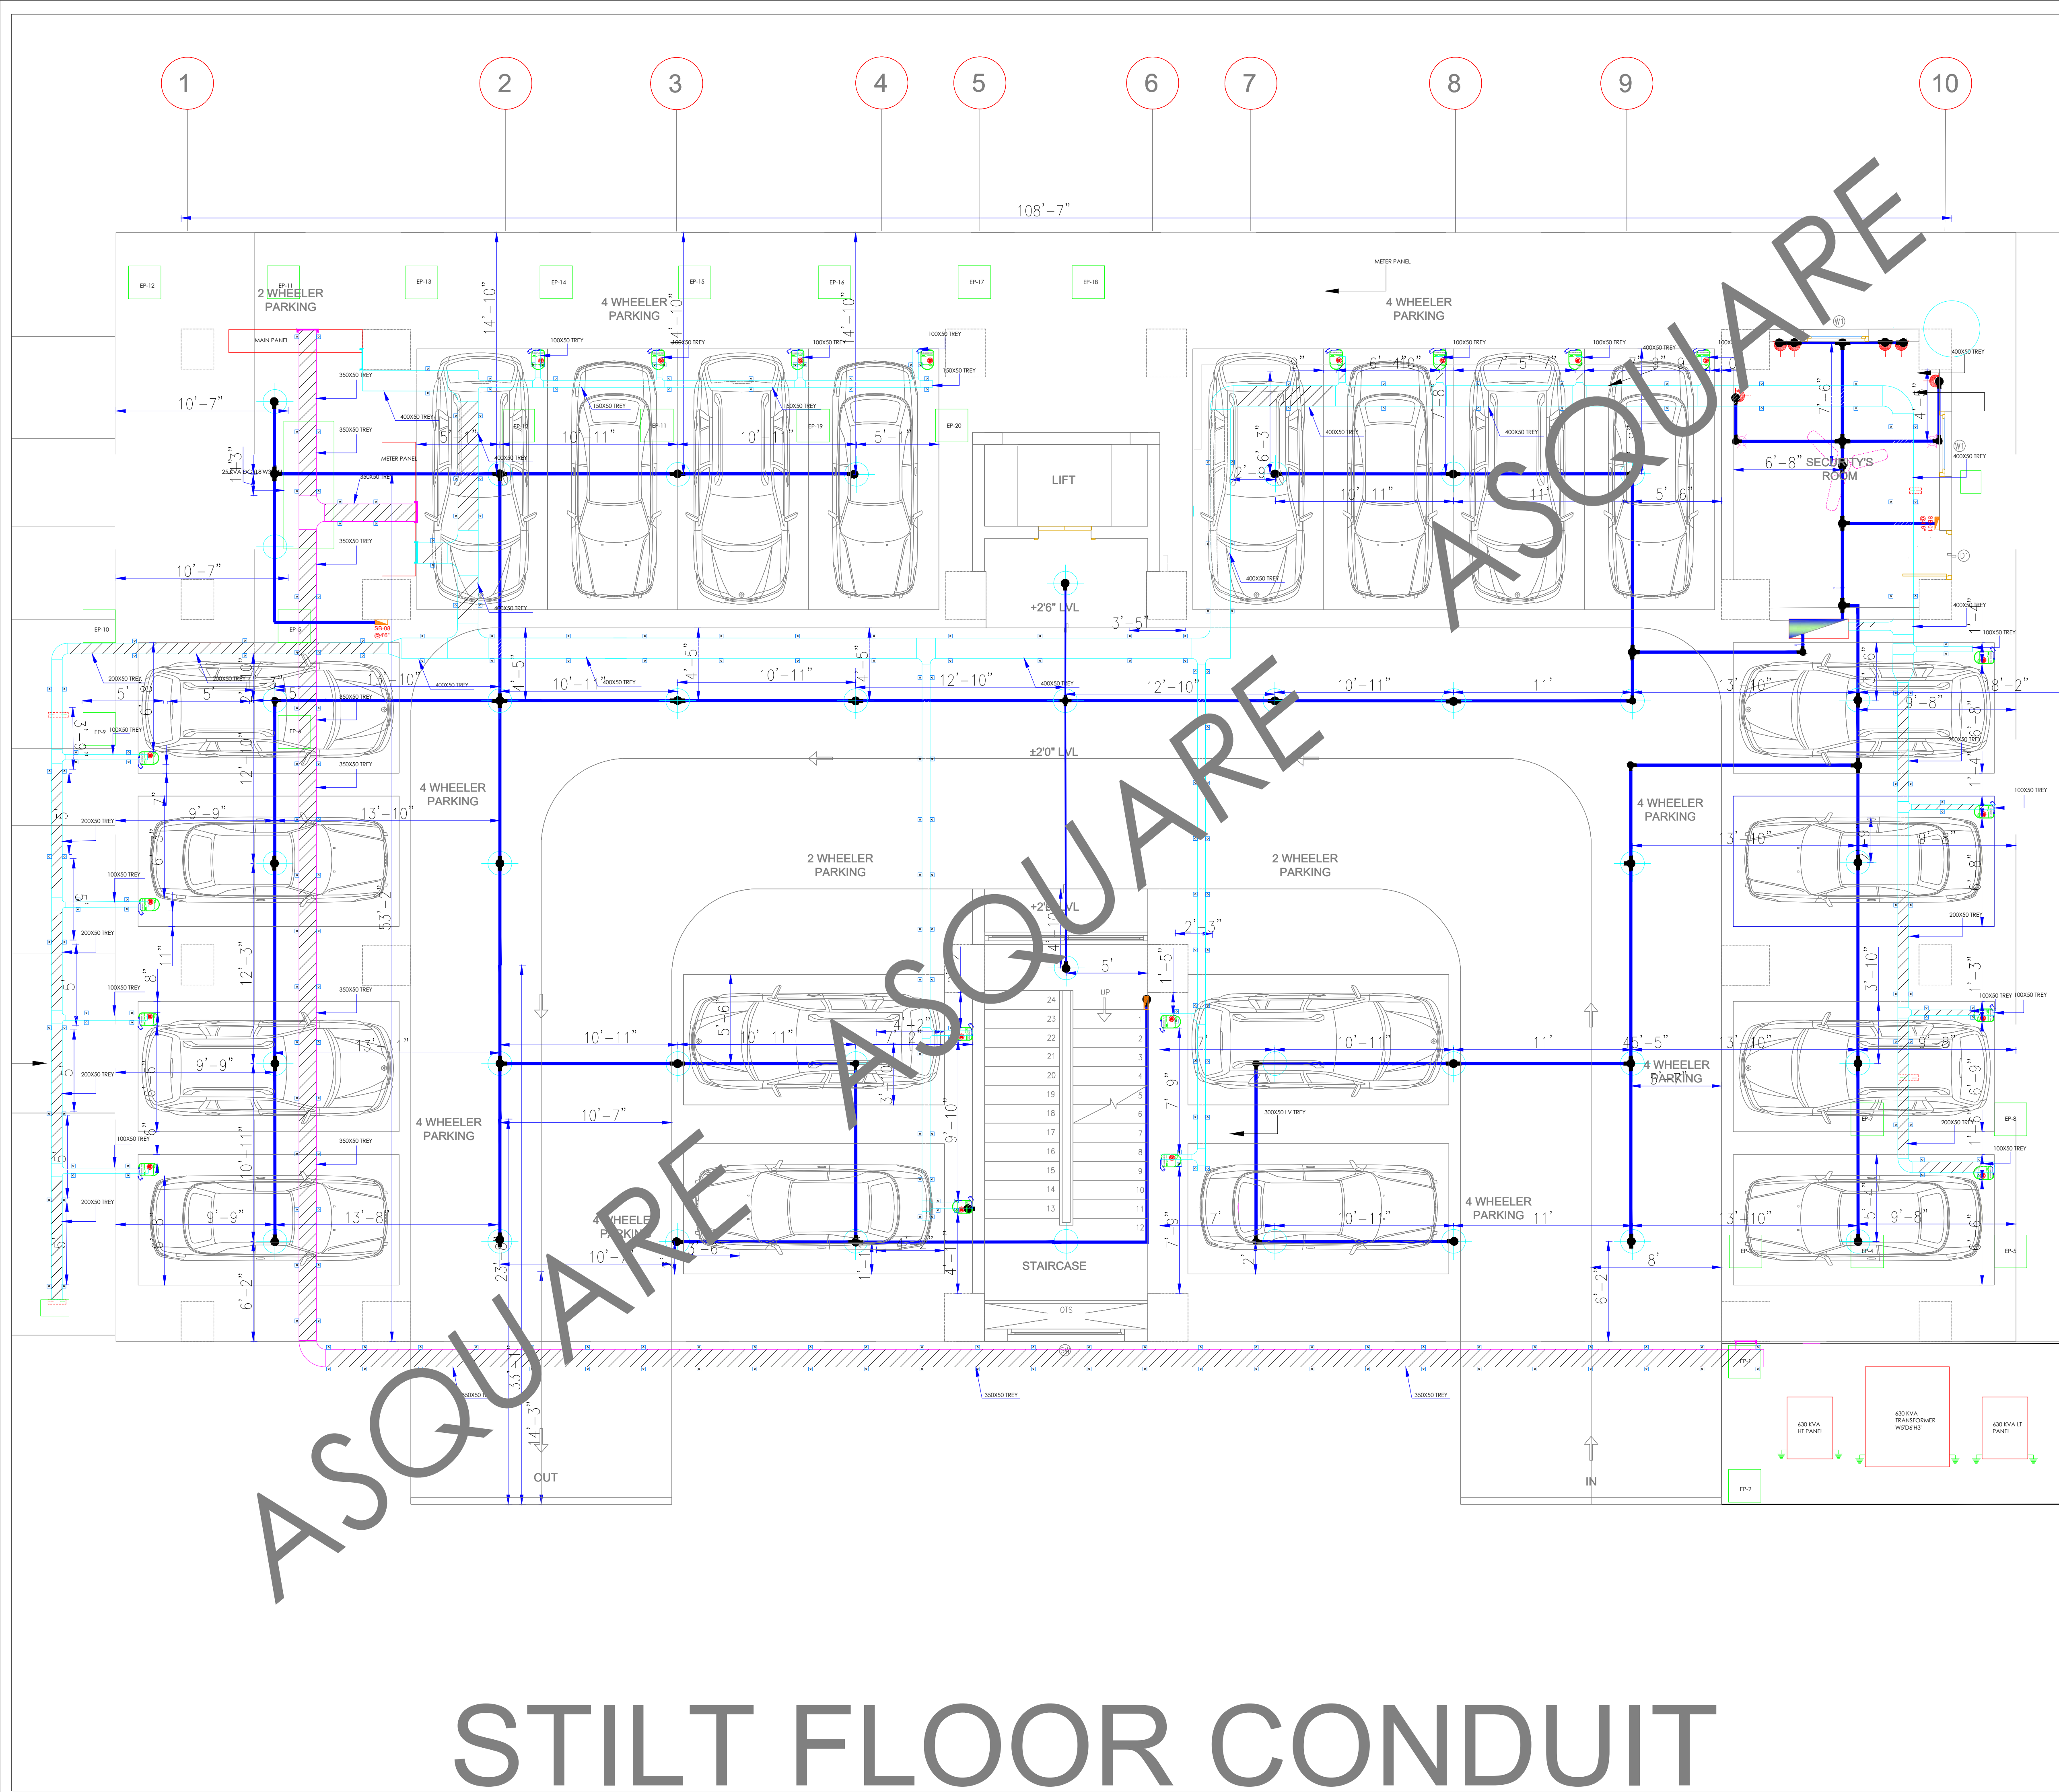

GOOD FOR CONSTRUCTION

Issued by: \_\_\_\_\_

Issued Date: 10 OCT 2024

COPYRIGHT POLICY

A-SQUARE MEP Consultants (hereafter referred to as "A-SQUARE") retains all copyright and other proprietary rights to the drawings created by A-SQUARE. All drawings created by A-SQUARE are protected by Indian and international copyright laws. Any unauthorized reproduction, distribution, or modification of A-SQUARE's drawings is strictly prohibited. A-SQUARE reserves the right to take legal action against any unauthorized use of its drawings. A-SQUARE grants clients a limited, non-exclusive, non-transferable license to use the drawings for the specific project or purpose for which they were created. Clients may not use the drawings for any other purpose without the express written consent of A-SQUARE. Clients may not modify, reproduce, distribute, transmit, display, perform, publish, license, create derivative works from, transfer, or sell any of A-SQUARE's drawings without the prior written consent of A-SQUARE. Clients may not use any of A-SQUARE's drawings as a basis for the design or construction of any other project without the express written consent of A-SQUARE. Clients may not disclose any of A-SQUARE's drawings to any third party without the prior written consent of A-SQUARE. kindly visit our web-site, to know more.

| REVISION CHART |               |          |
|----------------|---------------|----------|
|                | REVISION DATE | REV. NO. |
| 1              | 03 AUG 2024   | R0       |
| 2              | 19 AUG 2024   | R1       |
| 3              | 07 SEP 2024   | R2       |
| 4              | 10 OCT 2024   | R3       |

ENGINEERING CONSULTANTS:



G-31, CEDAR BUILDING, BRIGADE ORCHARDS, SPINAL ROAD, DEVANAHALLI, BANGALORE-562110  
Email: Support@a-square.group  
Contact No: +91 9845208299  
www.a-sqaure.group

ARCHITECT NAME

INNOBUILD LANDHOLDINGS

PROJECT NAME:

ALAKANANDA APARTMENTA -AT KAVALI

DRAWING TITLE:

STILT FLOOR CONDUIT

|      |       |       |
|------|-------|-------|
| DRWN | CHD   | APPD  |
| M.F  | ABDUL | ALTAF |

|       |            |      |
|-------|------------|------|
| SCALE | SHEET SIZE | REV. |
| NTS   | A1         | R3   |




COPYRIGHT POLICY

A-SQUARE MEP Consultants (hereafter referred to as "A-SQUARE") retains all copyright and other proprietary rights to the drawing created by A-SQUARE. All drawings created by A-SQUARE are protected by Indian and international copyright laws. Any unauthorized reproduction, distribution, or modification of A-SQUARE's drawings is strictly prohibited. A-SQUARE reserves the right to take legal action against any unauthorized use of its drawings. A-SQUARE grants clients a limited, non-exclusive, non-transferable license to use the drawings for the specific project or purpose for which they were created. Clients may not use the drawings for any other purpose without the express written consent of A-SQUARE. Clients may not modify, reproduce, distribute, transmit, display, perform, publish, license, create derivative works from, transfer, or sell any of A-SQUARE's drawings without the prior written consent of A-SQUARE. Clients may not use any of A-SQUARE's drawings as a basis for the design or construction of any other project without the express written consent of A-SQUARE. Clients may not disclose any of A-SQUARE's drawings to any third party without the prior written consent of A-SQUARE. kindly visit our web-site, to know more.

REVISION CHART

|   | REVISION DATE | REV. NO. |
|---|---------------|----------|
| 1 | 03 AUG 2024   | R0       |
| 2 | 19 AUG 2024   | R1       |
| 3 | 07 SEP 2024   | R2       |
| 4 | 10 OCT 2024   | R3       |

ENGINEERING CONSULTANTS:

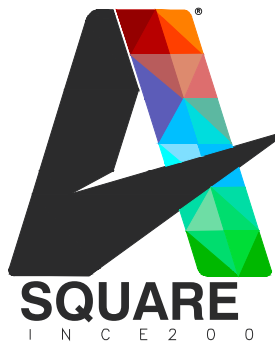

G-31, CEDAR BUILDING, BRIGADE ORCHARDS,  
SPINAL ROAD, DEVANAHALLI, BANGALORE-562110  
Email: Support@a-square.group  
Contact No: +91 9845208299  
www.a-sqaure.group

ARCHITECT NAME

INNOBUILD LANDHOLDINGS


PROJECT NAME:

ALAKANANDA APARTMENTA  
-AT KAVALI


DRAWING TITLE:

TYPICAL FLOOR CONDUIT


|       |            |       |
|-------|------------|-------|
| DRWN  | CHD        | APPD  |
| M.F   | ABDUL      | ALTAF |
| SCALE | SHEET SIZE | REV.  |
| NTS   | A1         | R3    |

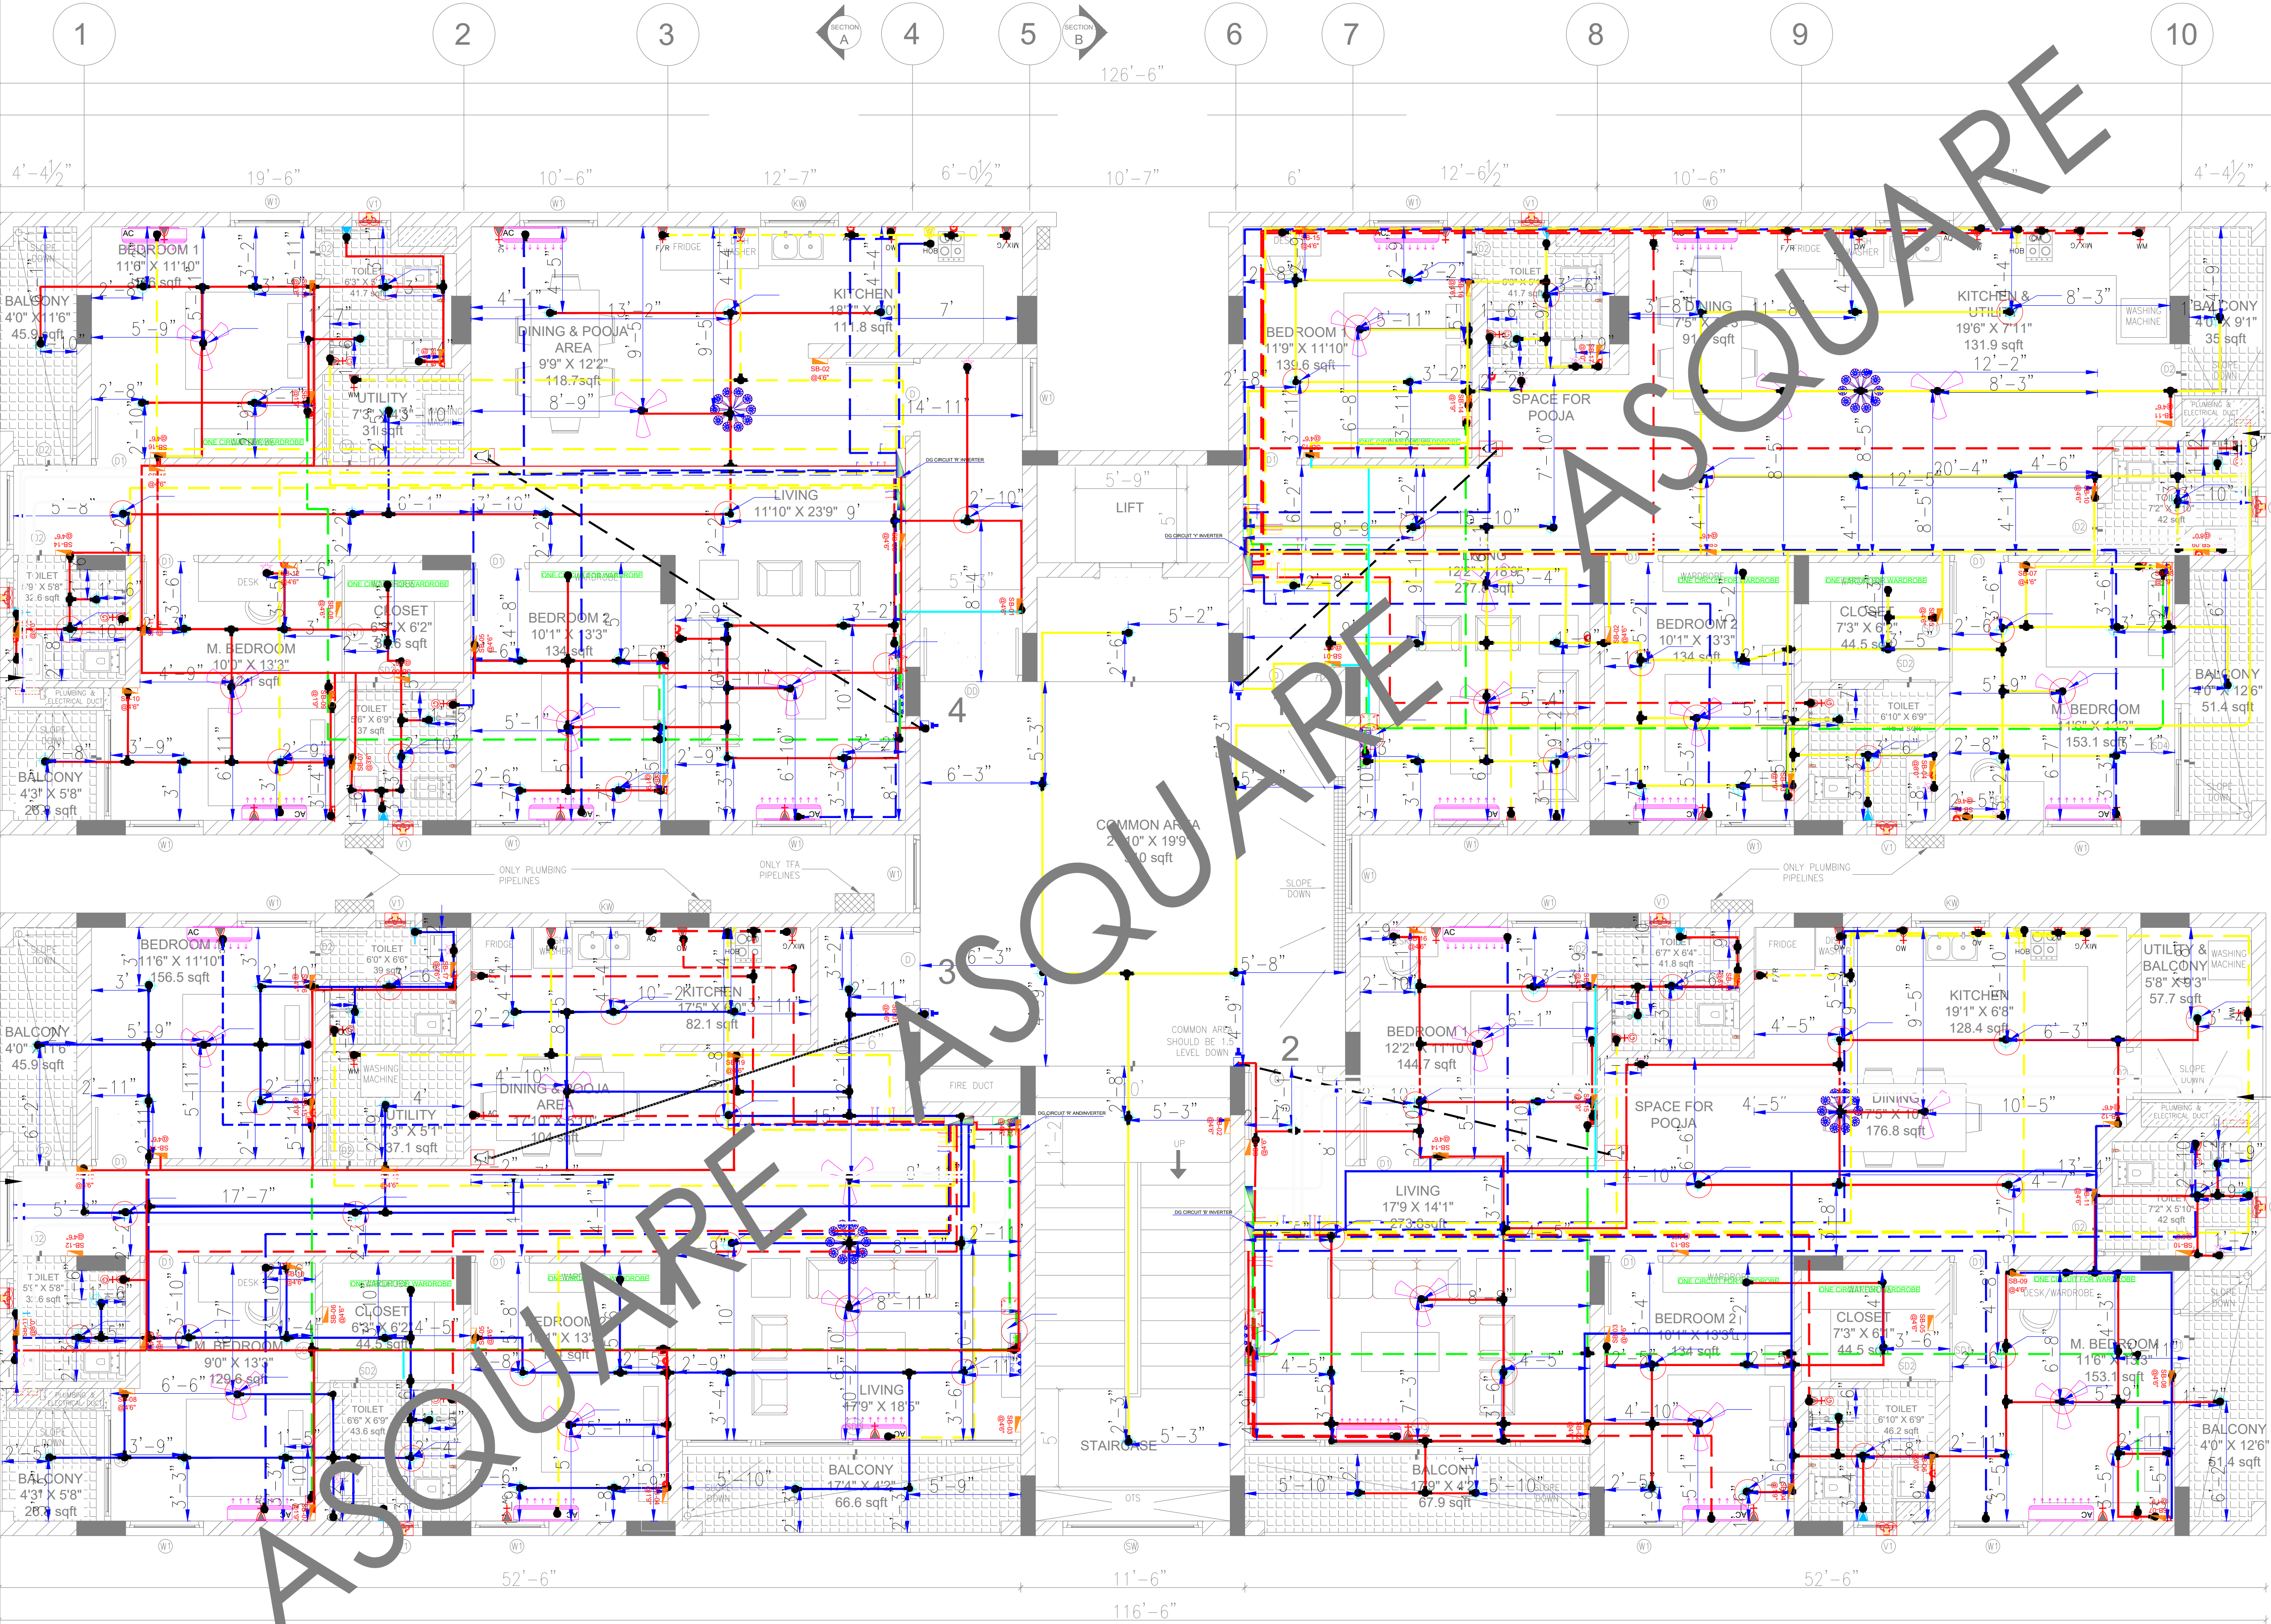




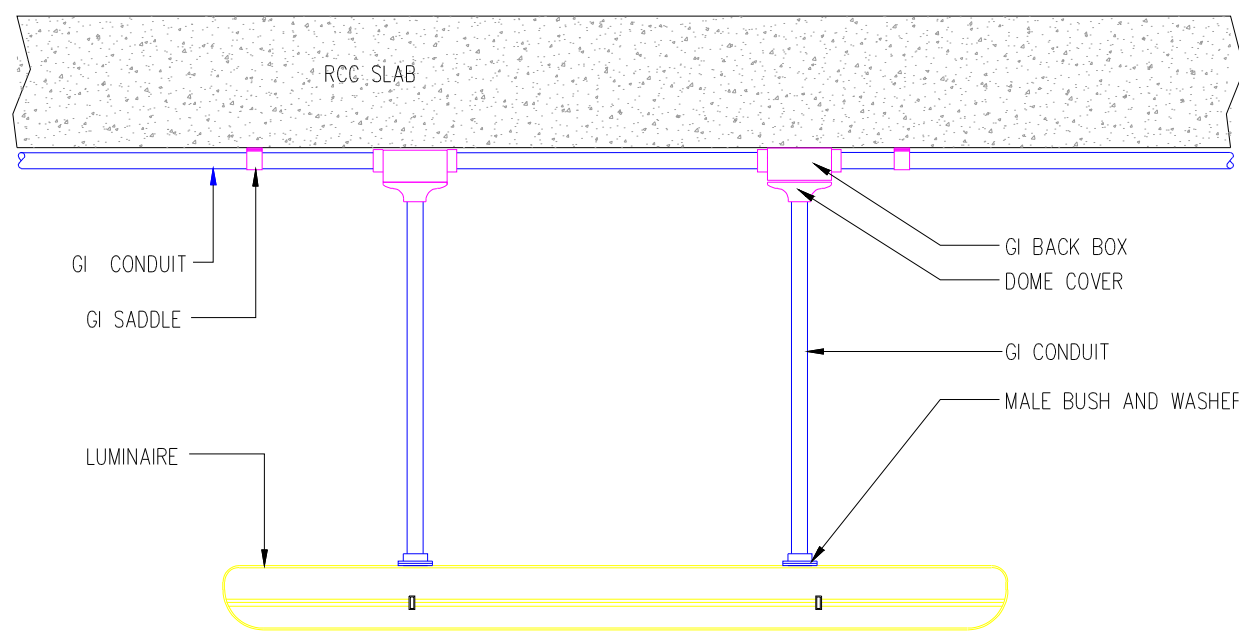


01 TYPICAL INSTALLATION DETAIL FOR SUSPENDED LED LUMINAIRE  
SCALE NTS

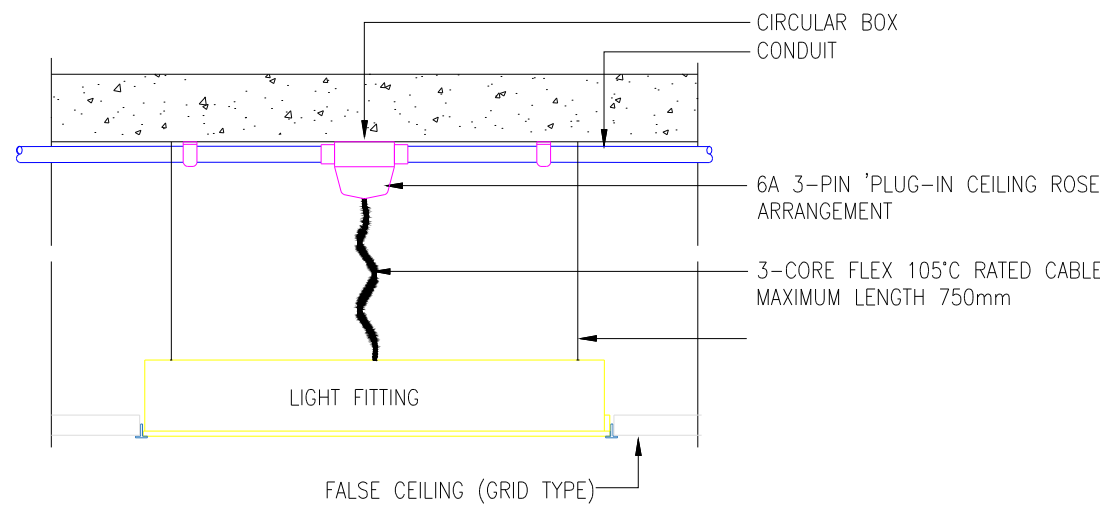


02 TYPICAL INSTALLATION DETAIL FOR RECESSED LED LUMINAIRE  
SCALE NTS

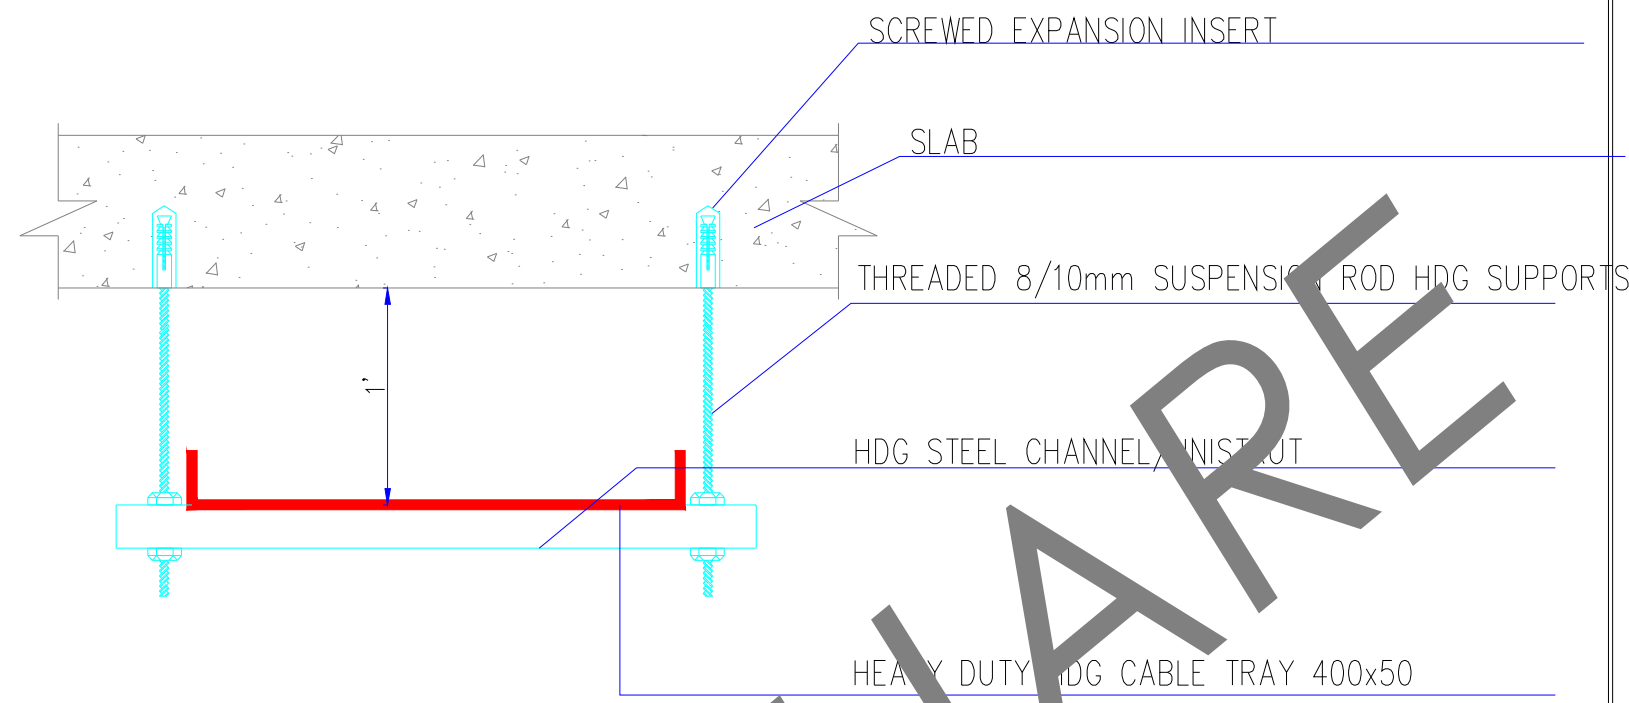


03 CABEL TRAY TYPICAL DETAILS  
NTS

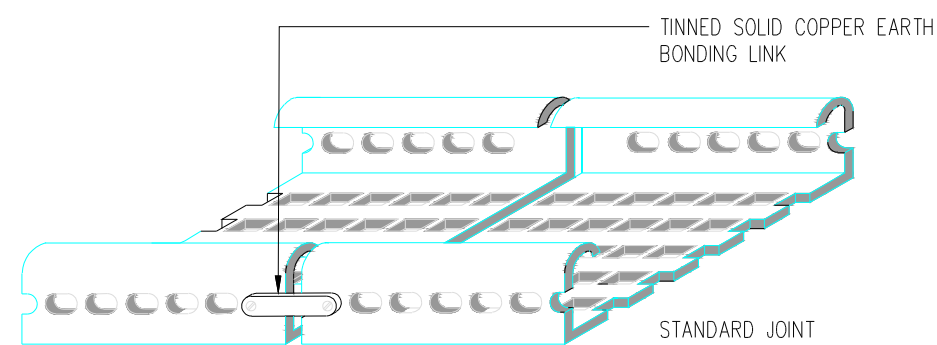


04 CABLE TRAY BONDING  
NTS

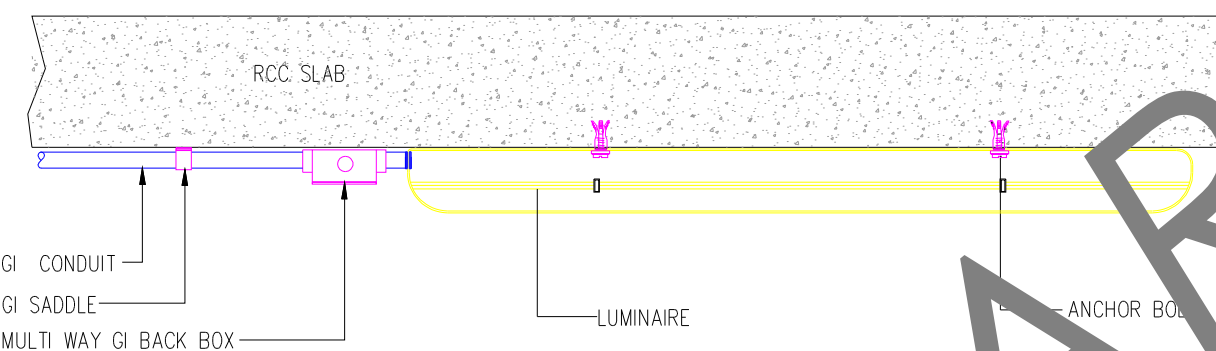


05 TYPICAL INSTALLATION DETAIL FOR SURFACE LED LUMINAIRE  
SCALE NTS

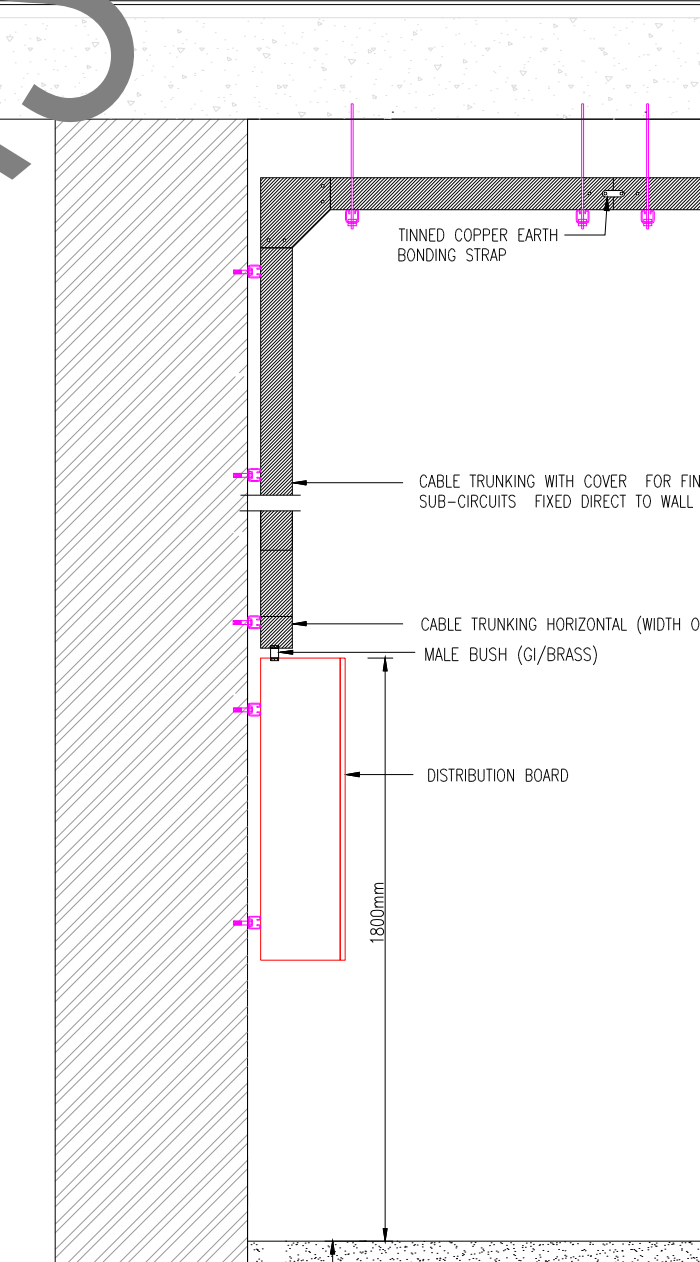


06 SURFACE MOUNTED DISTRIBUTION BOARD  
NTS

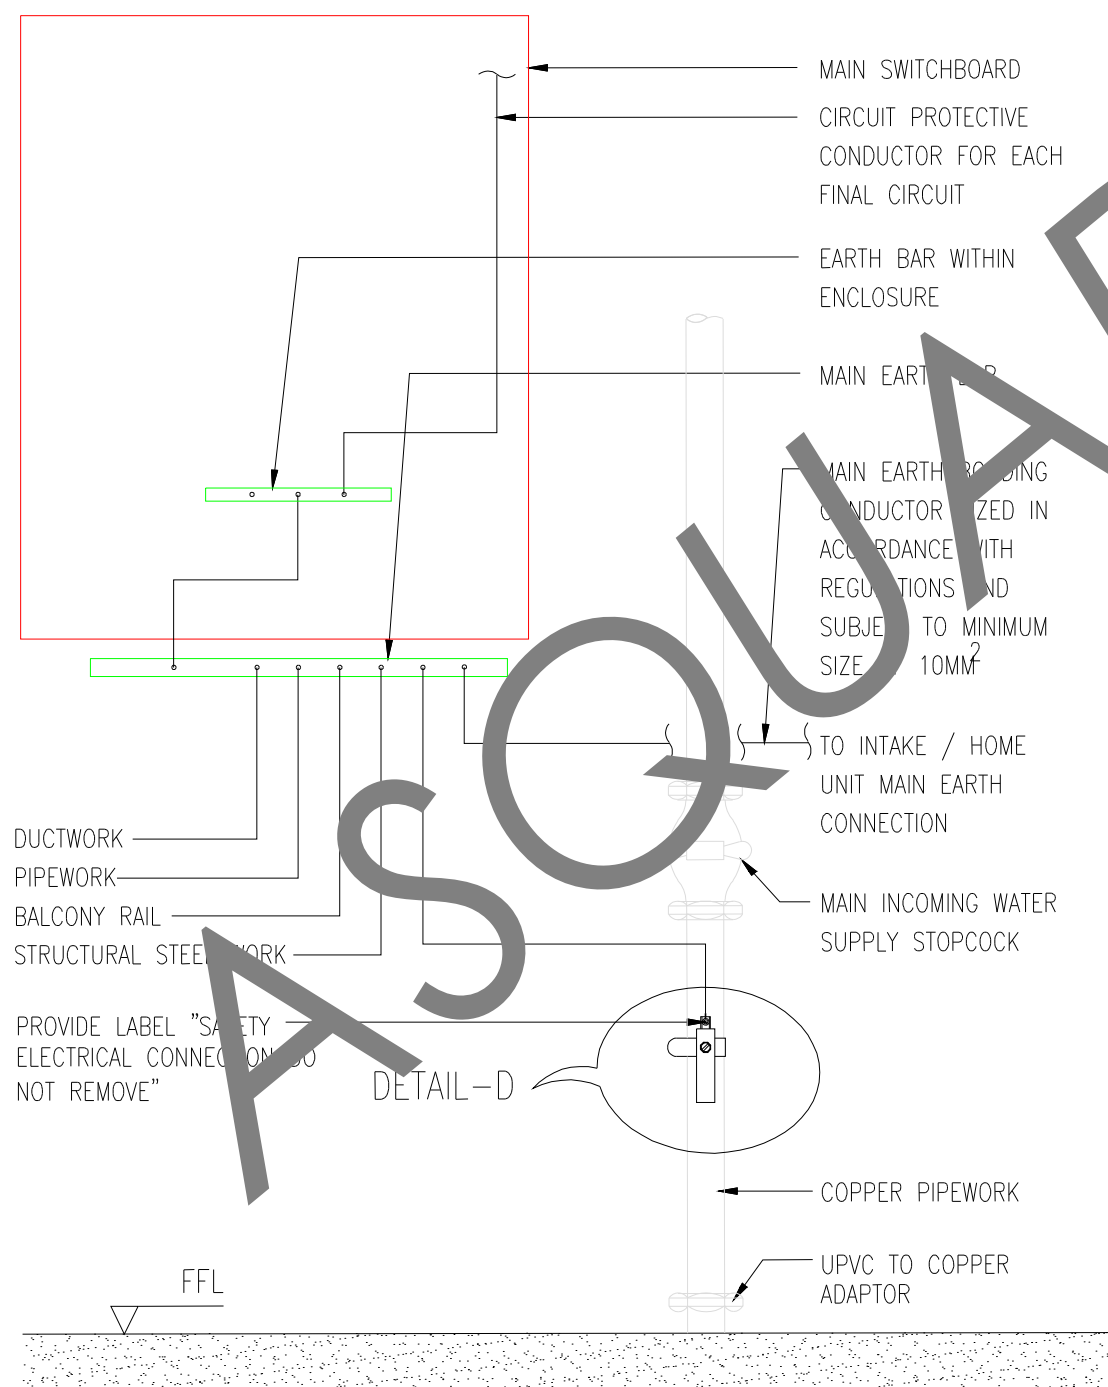

07 TYPICAL EQUIPOTENTIAL BONDING CONNECTIONS  
NTS

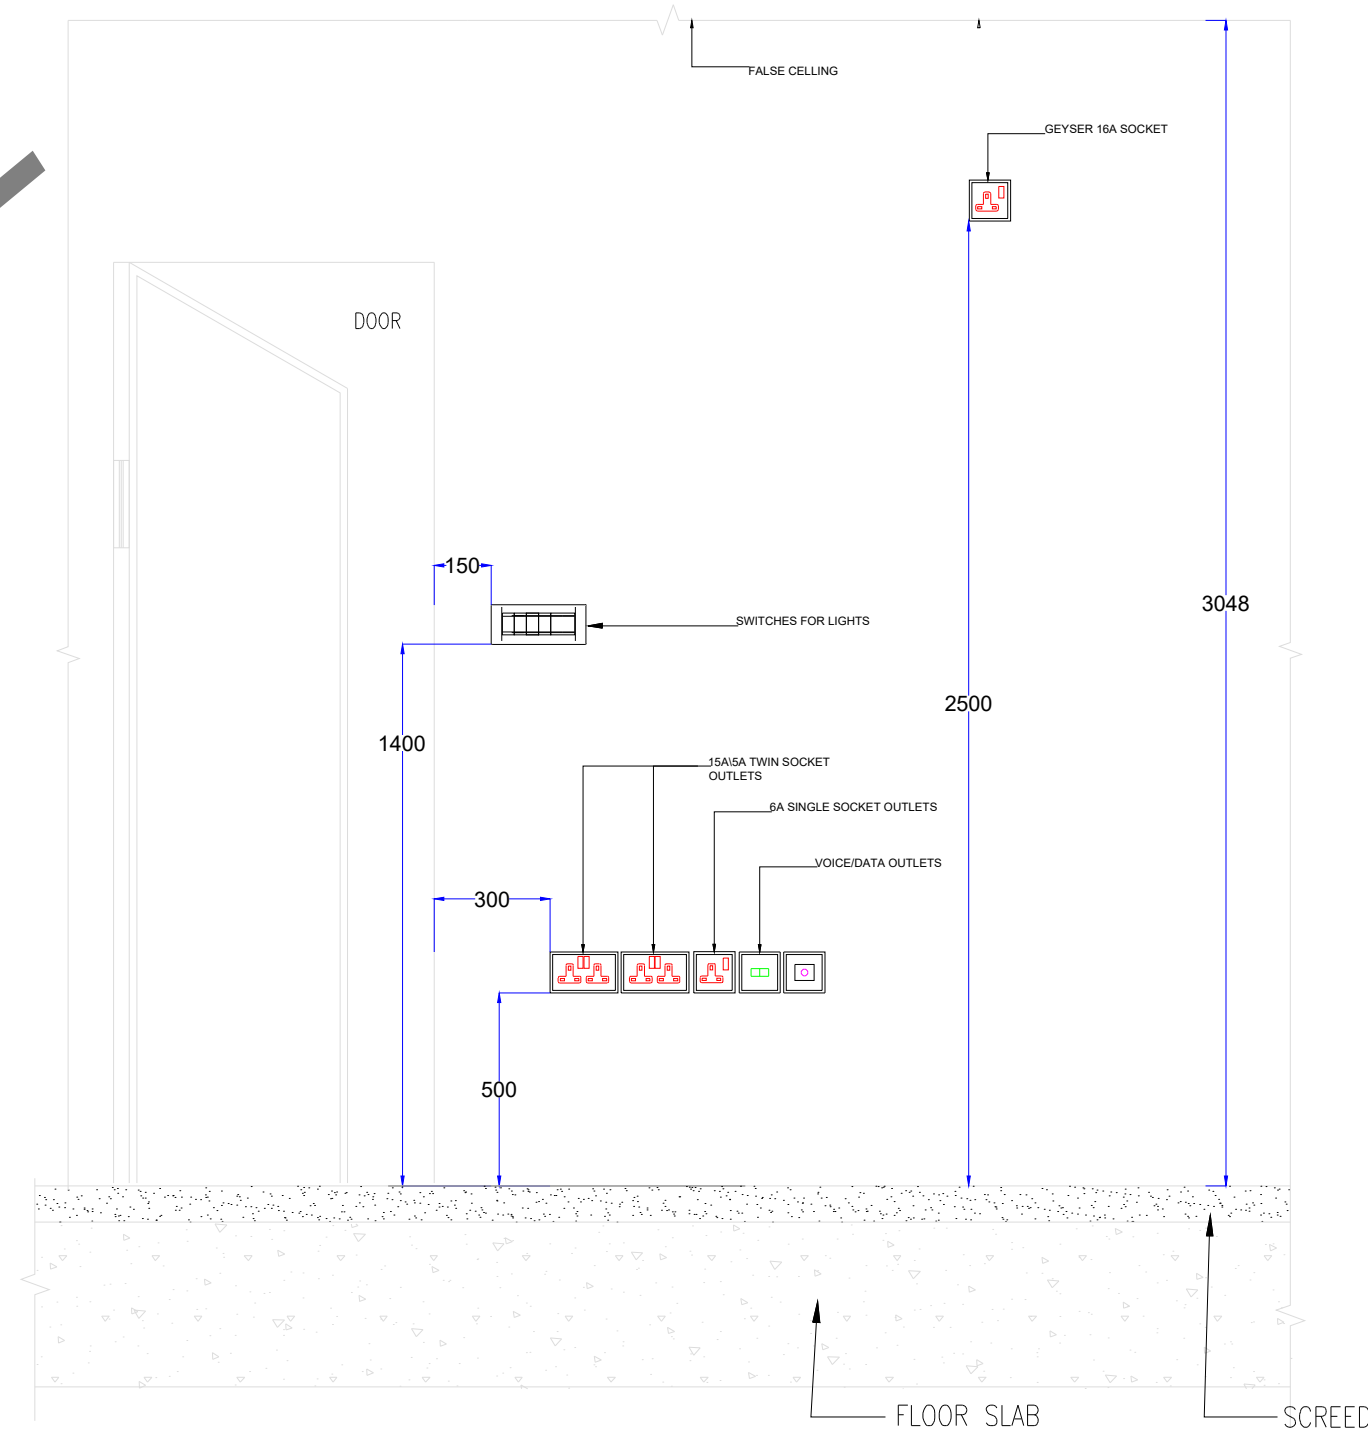

08 SWITCHBOARDS  
NTS

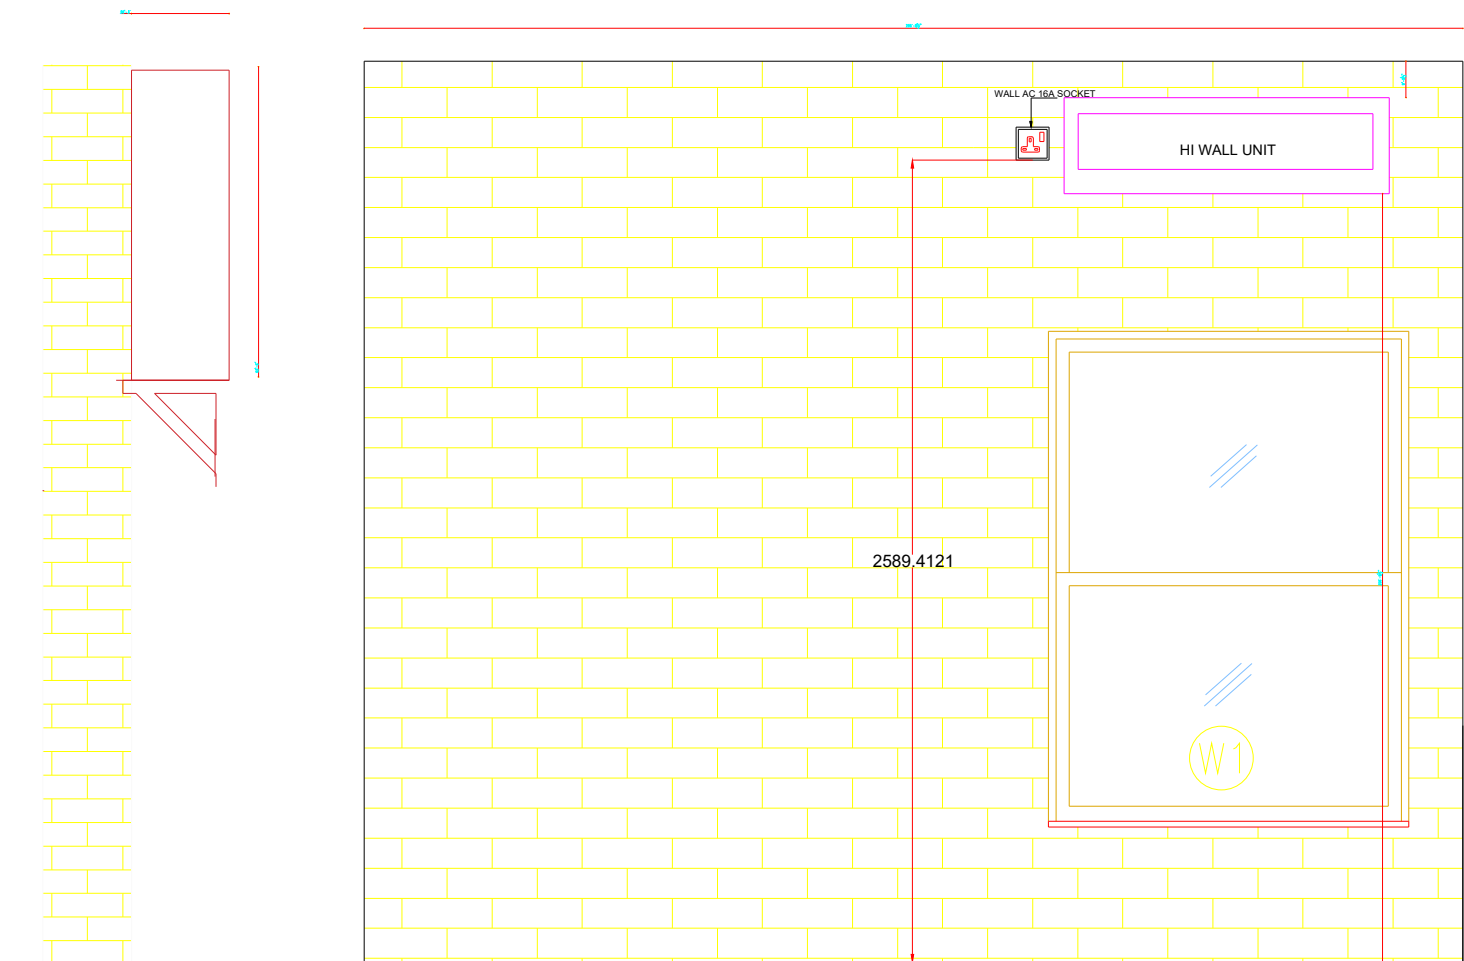

09 WALL AC SOCKET OUTLET  
NTS

GOOD FOR CONSTRUCTION

Issued by: \_\_\_\_\_  
Issued Date: 10 OCT 2024

## COPYRIGHT POLICY

A-SQUARE MEP Consultants (hereafter referred to as "A-SQUARE") retains all copyright and other proprietary rights to the drawings created by A-SQUARE. All drawings created by A-SQUARE are protected by Indian and international copyright laws. Any unauthorized reproduction, distribution, or modification of A-SQUARE's drawings is strictly prohibited. A-SQUARE reserves the right to take legal action against any unauthorized use of its drawings. A-SQUARE grants clients a limited, non-exclusive, non-transferable license to use the drawings for the specific project or purpose for which they were created. Clients may not use the drawings for any other purpose without the express written consent of A-SQUARE. Clients may not modify, reproduce, distribute, transmit, display, perform, publish, license, create derivative works from, transfer, or sell any of A-SQUARE's drawings without the prior written consent of A-SQUARE. Clients may not use any of A-SQUARE's drawings as a basis for the design or construction of any other project without the express written consent of A-SQUARE. Clients may not disclose any of A-SQUARE's drawings to any third party without the prior written consent of A-SQUARE. kindly visit our web-site, to know more.

## REVISION CHART

|   | REVISION DATE | REV. NO. |
|---|---------------|----------|
| 1 | 03 AUG 2024   | R0       |
| 2 | 19 AUG 2024   | R1       |
| 3 | 07 SEP 2024   | R2       |
| 4 | 10 OCT 2024   | R3       |

## ENGINEERING CONSULTANTS:



G-31, CEDAR BUILDING, BRIGADE ORCHARDS,  
SPINAL ROAD, DEVANAHALLI, BANGALORE-562110  
Email: Support@a-square.group  
Contact No: +91 9845208299  
www.a-sqaure.group

## ARCHITECT NAME

INNOBUILD LANDHOLDINGS

## PROJECT NAME:


ALAKANANDA APARTMENTA  
-AT KAVALI

## DRAWING TITLE:

ELECTRICAL SECTIONS

| DRWN  | CHD        | APPD  |
|-------|------------|-------|
| M.F   | ABDUL      | ALTAF |
| SCALE | SHEET SIZE | REV.  |
| NTS   | A1         | R3    |



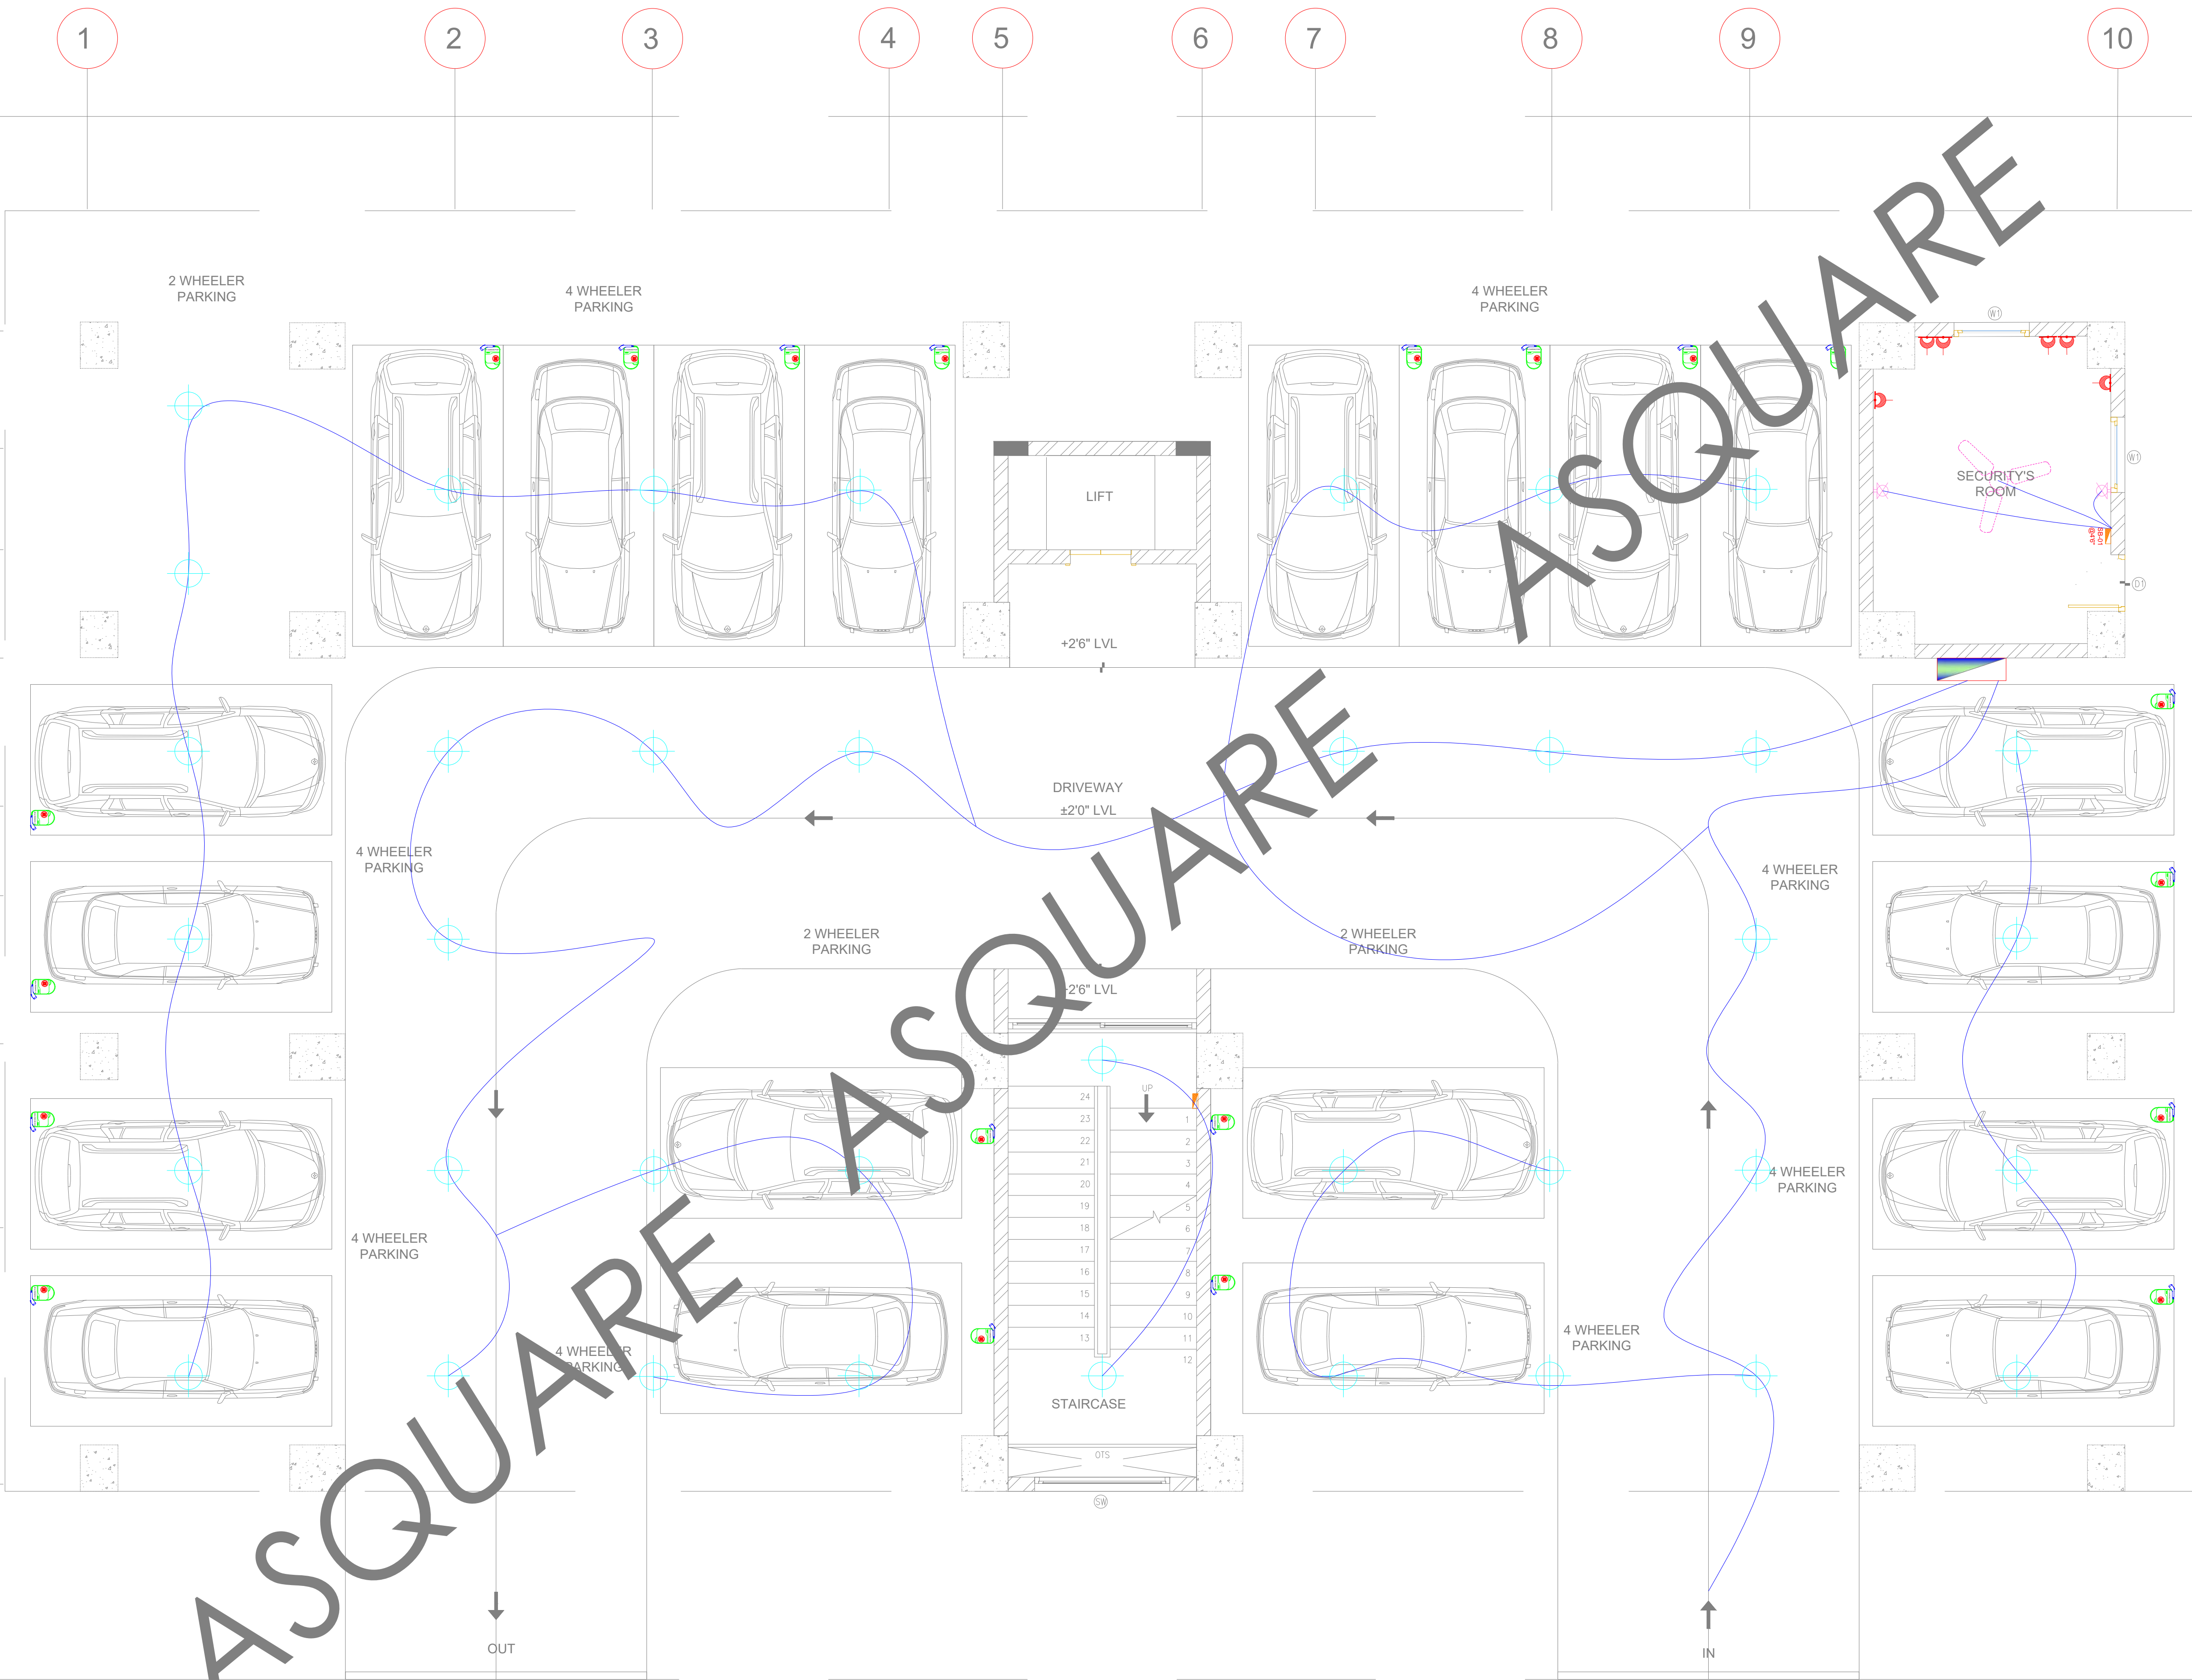

GOOD FOR CONSTRUCTION

Issued by: \_\_\_\_\_  
Issued Date: 03 OCT 2024

COPYRIGHT POLICY

A-SQUARE MEP Consultants (hereafter referred to as "A-SQUARE") retains all copyright and other proprietary rights to the drawings created by A-SQUARE. All drawings created by A-SQUARE are protected by Indian and international copyright laws. Any unauthorized reproduction, distribution, or modification of A-SQUARE's drawings is strictly prohibited. A-SQUARE reserves the right to take legal action against any unauthorized use of its drawings. A-SQUARE grants clients a limited, non-exclusive, non-transferable license to use the drawings for the specific project or purpose for which they were created. Clients may not use the drawings for any other purpose without the express written consent of A-SQUARE. Clients may not modify, reproduce, distribute, transmit, display, perform, publish, license, create derivative works from, transfer, or sell any of A-SQUARE's drawings without the prior written consent of A-SQUARE. Clients may not use any of A-SQUARE's drawings as a basis for the design or construction of any other project without the express written consent of A-SQUARE. Clients may not disclose any of A-SQUARE's drawings to any third party without the prior written consent of A-SQUARE. kindly visit our web-site, to know more.

REVISION CHART

|   | REVISION DATE | REV. NO. |
|---|---------------|----------|
| 1 | 03 AUG 2024   | R0       |
| 2 | 19 AUG 2024   | R1       |
| 3 | 07 SEP 2024   | R2       |
| 4 | 10 OCT 2024   | R3       |

ENGINEERING CONSULTANTS:



G-31, CEDAR BUILDING, BRIGADE ORCHARDS,  
SPINAL ROAD, DEVANAHALLI, BANGALORE-562110  
Email: Support@a-square.group  
Contact No: +91 9845208299  
www.a-sqaure.group

ARCHITECT NAME

INNOBUILD LANDHOLDINGS

PROJECT NAME:

ALAKANANDA APARTMENTA  
-AT KAVALI

DRAWING TITLE:

STILT FLOOR LOOPING

|      |       |       |
|------|-------|-------|
| DRWN | CHD   | APPD  |
| M.F  | ABDUL | ALTAF |

|       |            |      |
|-------|------------|------|
| SCALE | SHEET SIZE | REV. |
| NTS   | A1         | R3   |



GOOD FOR CONSTRUCTION

Issued by: \_\_\_\_\_  
Issued Date: 03 OCT 2024


COPYRIGHT POLICY

A-SQUARE MEP Consultants (hereafter referred to as "A-SQUARE") retains all copyright and other proprietary rights to the drawings created by A-SQUARE. All drawings created by A-SQUARE are protected by Indian and international copyright laws. Any unauthorized reproduction, distribution, or modification of A-SQUARE's drawings is strictly prohibited. A-SQUARE reserves the right to take legal action against any unauthorized use of its drawings. A-SQUARE grants clients a limited, non-exclusive, non-transferable license to use the drawings for the specific project or purpose for which they were created. Clients may not use the drawings for any other purpose without the express written consent of A-SQUARE. Clients may not modify, reproduce, distribute, transmit, display, perform, publish, license, create derivative works from, transfer, or sell any of A-SQUARE's drawings without the prior written consent of A-SQUARE. Clients may not use any of A-SQUARE's drawings as a basis for the design or construction of any other project without the express written consent of A-SQUARE. Clients may not disclose any of A-SQUARE's drawings to any third party without the prior written consent of A-SQUARE. kindly visit our web-site, to know more.

REVISION CHART

|   | REVISION DATE | REV. NO. |
|---|---------------|----------|
| 1 | 03 AUG 2024   | R0       |
| 2 | 19 AUG 2024   | R1       |
| 3 | 07 SEP 2024   | R2       |
| 4 | 10 OCT 2024   | R3       |

ENGINEERING CONSULTANTS:

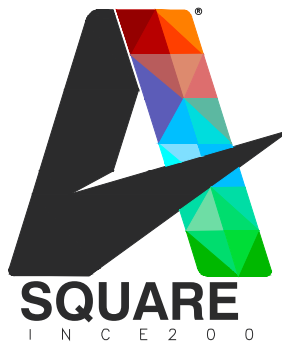

G-31, CEDAR BUILDING, BRIGADE ORCHARDS,  
SPINAL ROAD, DEVANAHALLI, BANGALORE-562110  
Email: Support@a-square.group  
Contact No: +91 9845208299  
www.a-sqaure.group

ARCHITECT NAME

INNOBUILD LANDHOLDINGS


PROJECT NAME:

ALAKANANDA APARTMENTA  
-AT KAVALI

DRAWING TITLE:

TYPICAL FLOOR LOOPING


|       |            |       |
|-------|------------|-------|
| DRWN  | CHD        | APPD  |
| M.F   | ABDUL      | ALTAF |
| SCALE | SHEET SIZE | REV.  |
| NTS   | A1         | R3    |

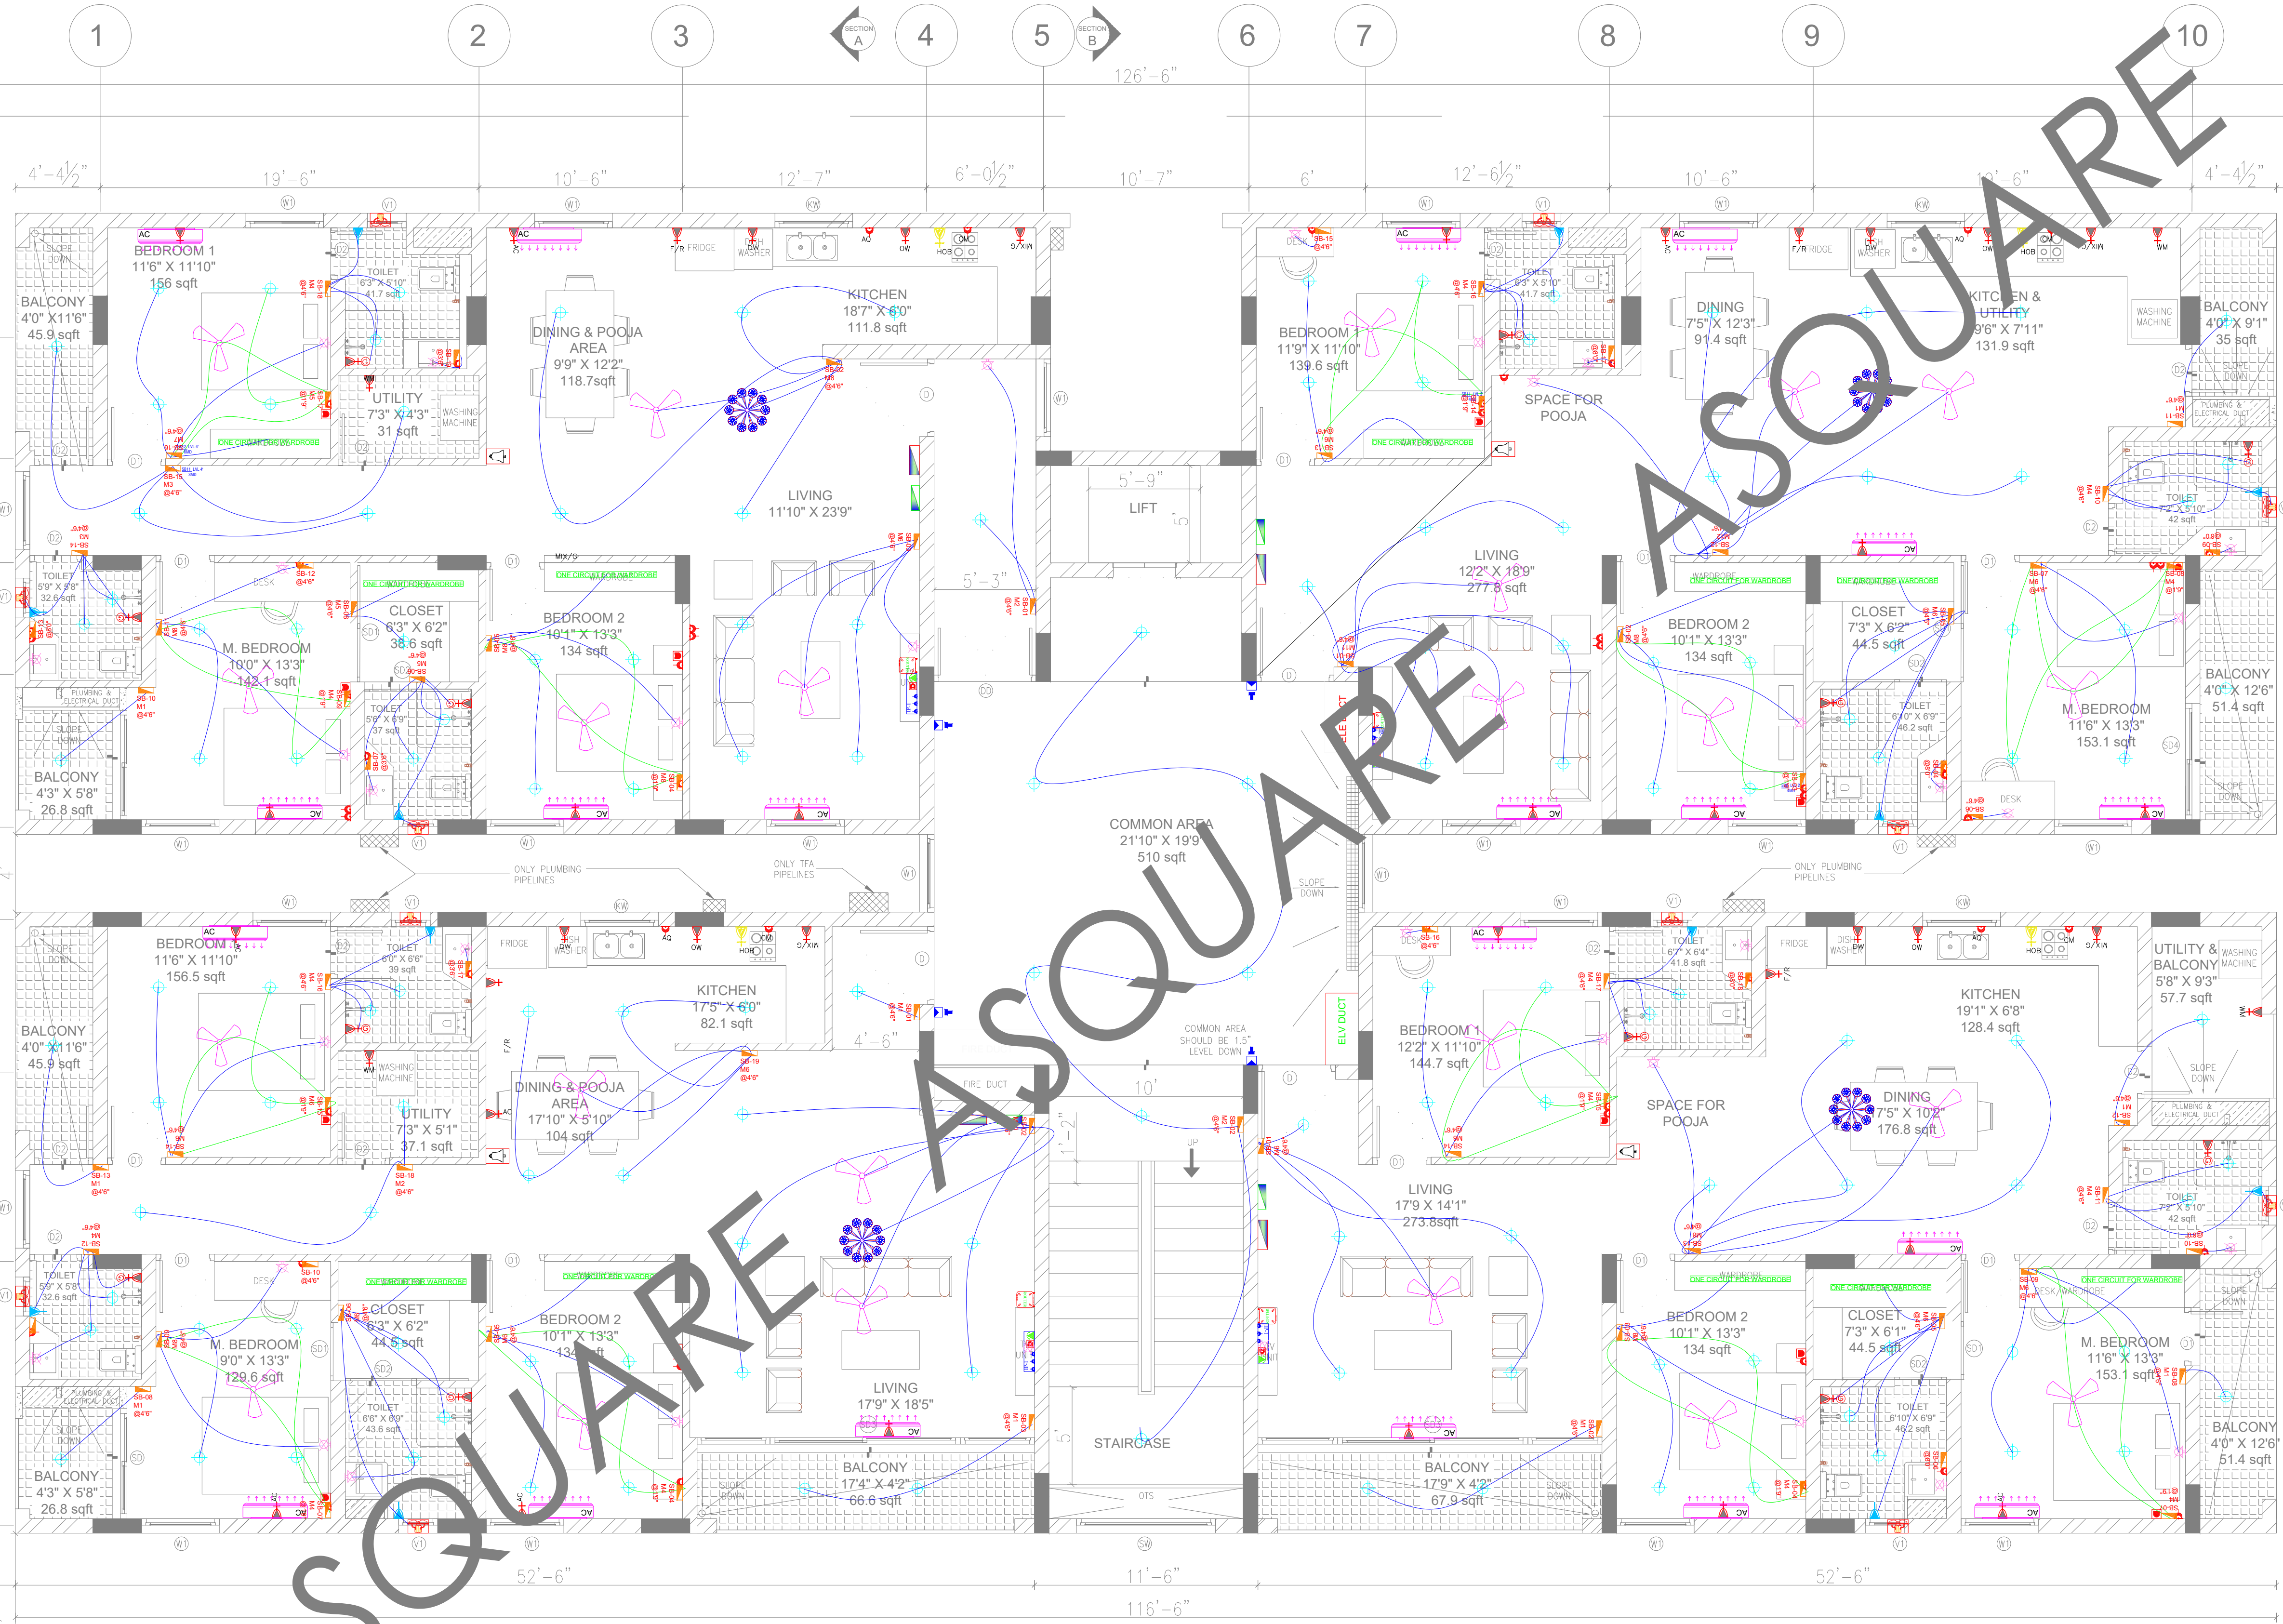

TYPICAL FLOOR LOOPING



POWER SLD

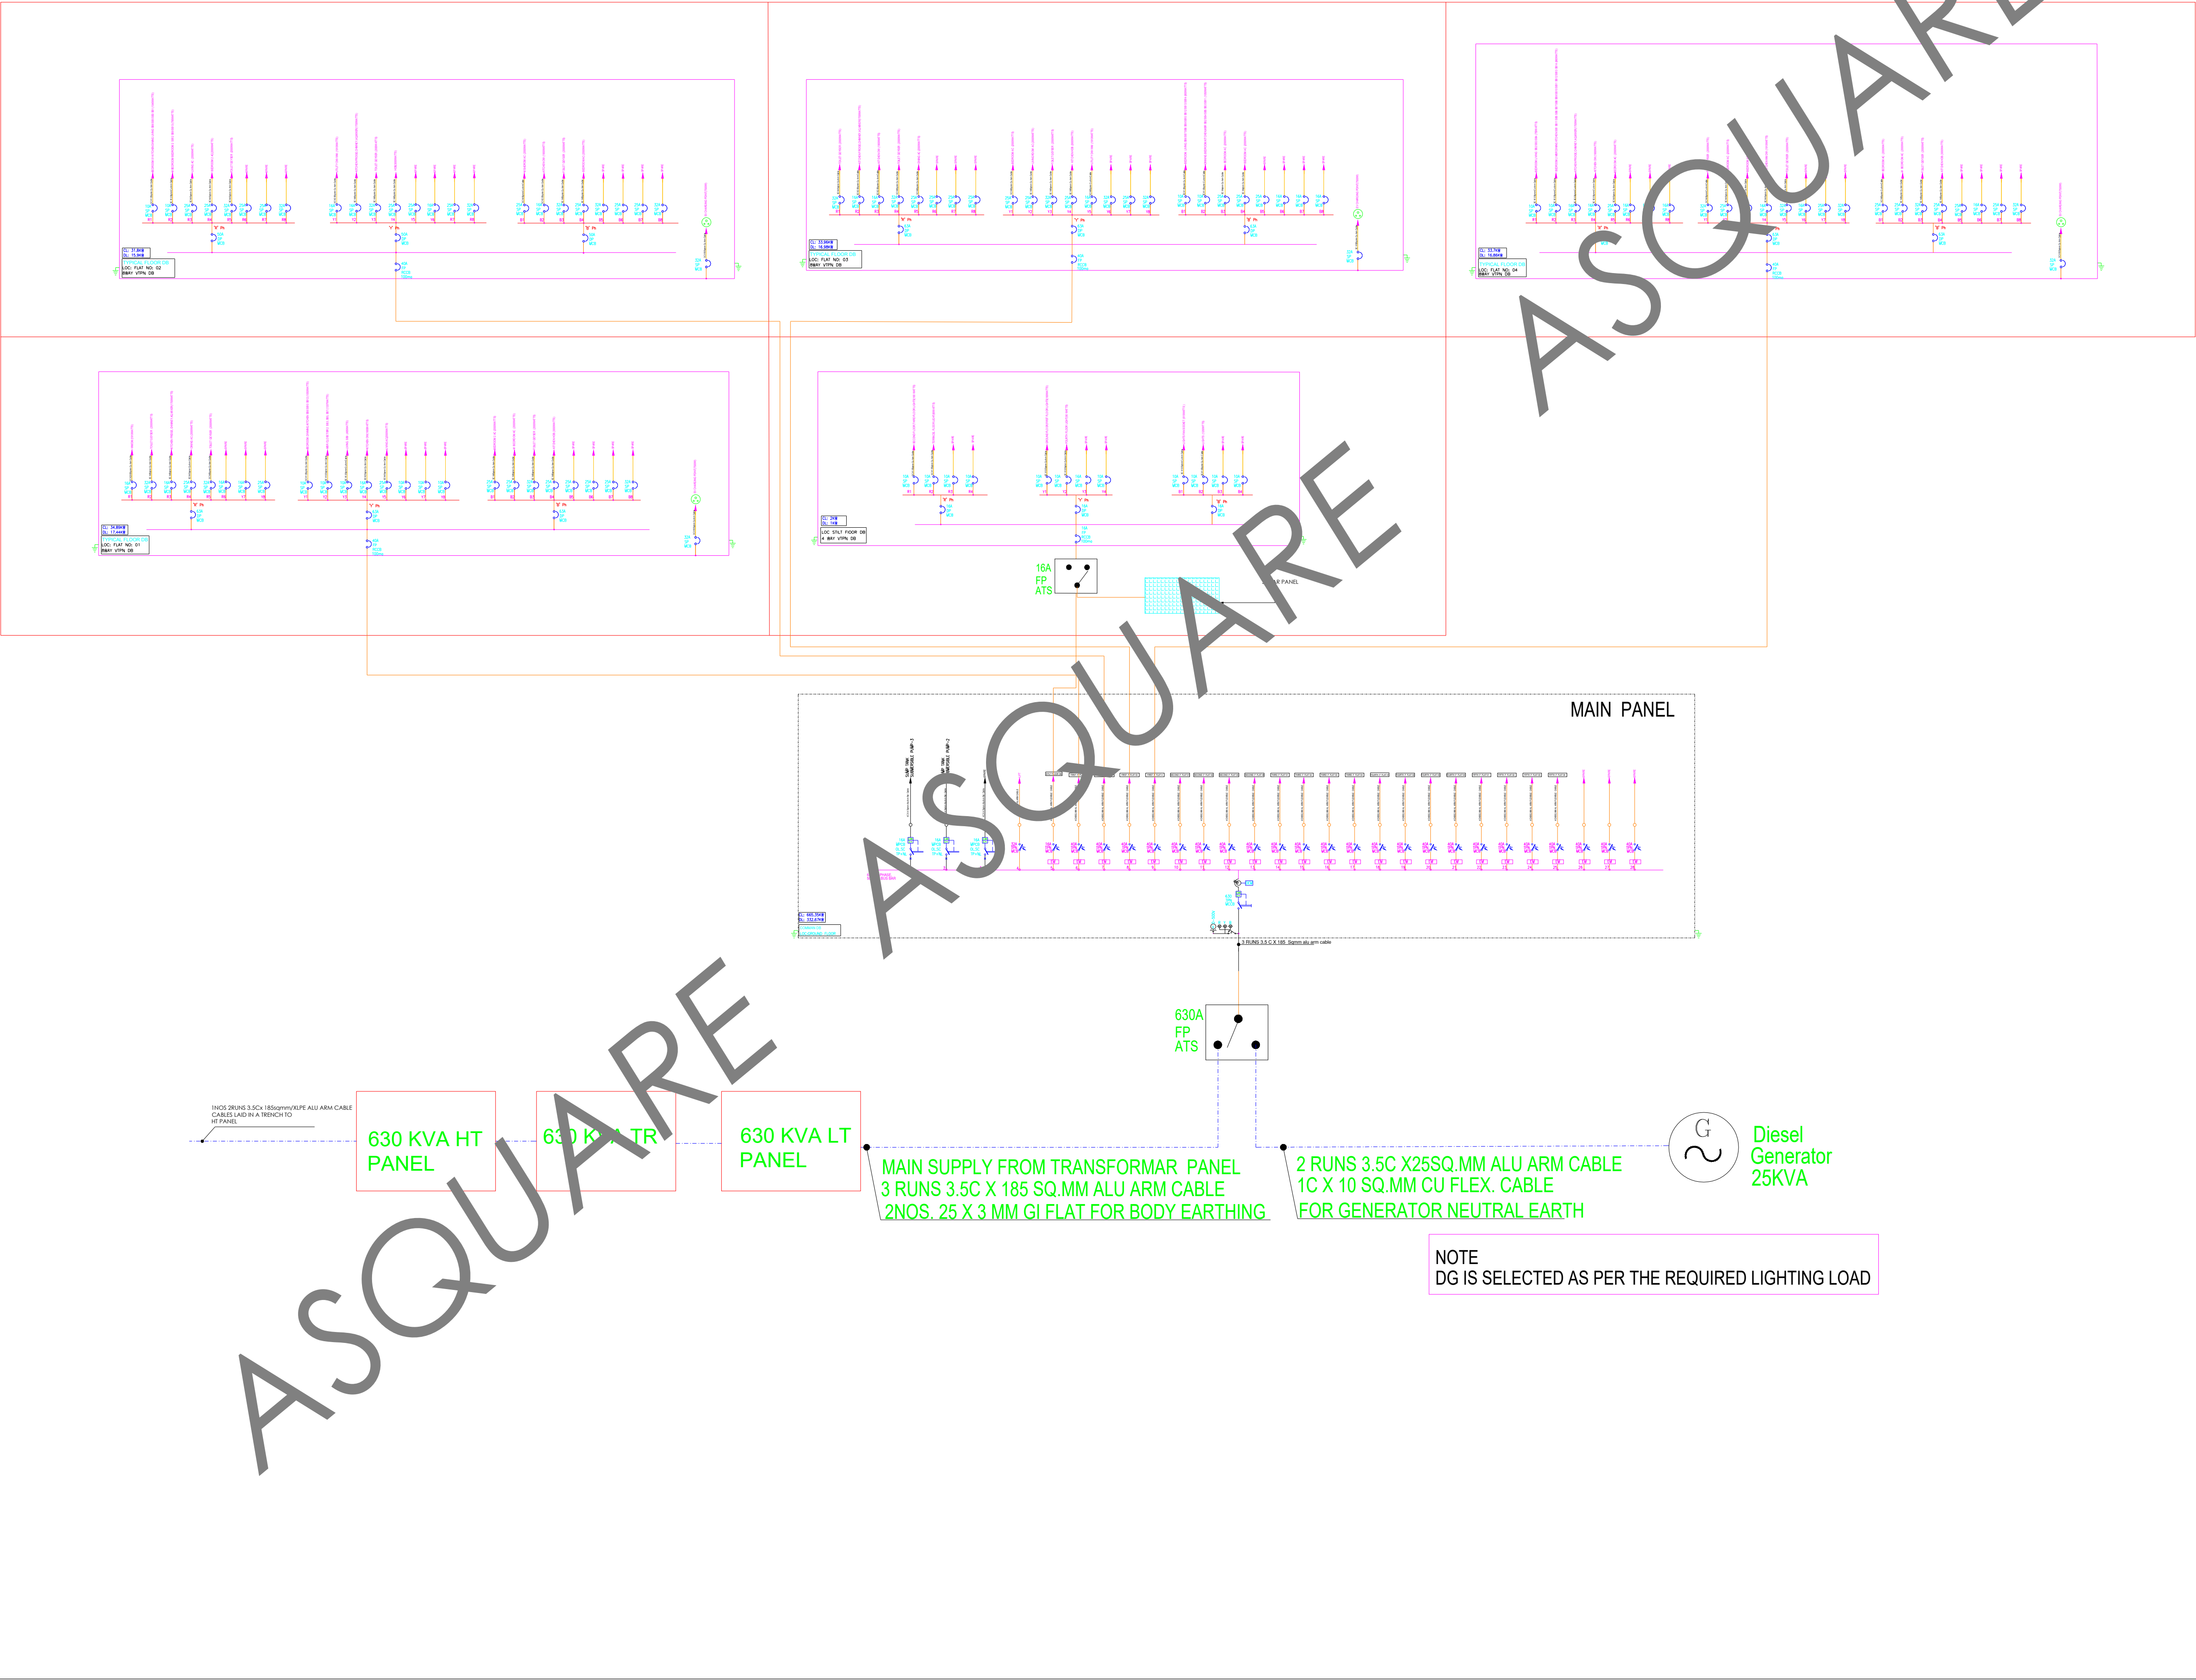

GOOD FOR CONSTRUCTION

Issued by: \_\_\_\_\_  
Issued Date: 03 OCT 2024


COPYRIGHT POLICY

A-SQUARE MEP Consultants (hereafter referred to as "A-SQUARE") retains all copyright and other proprietary rights to the drawings created by A-SQUARE. All drawings created by A-SQUARE are protected by Indian and international copyright laws. Any unauthorized reproduction, distribution, or modification of A-SQUARE's drawings is strictly prohibited. A-SQUARE reserves the right to take legal action against any unauthorized use of its drawings. A-SQUARE grants clients a limited, non-exclusive, non-transferable license to use the drawings for the specific project or purpose for which they were created. Clients may not use the drawings for any other purpose without the express written consent of A-SQUARE. Clients may not modify, reproduce, distribute, transmit, display, perform, publish, license, create derivative works from, transfer, or sell any of A-SQUARE's drawings without the prior written consent of A-SQUARE. Clients may not use any of A-SQUARE's drawings as a basis for the design or construction of any other project without the express written consent of A-SQUARE. Clients may not disclose any of A-SQUARE's drawings to any third party without the prior written consent of A-SQUARE. kindly visit our web-site, to know more.

REVISION CHART

|   | REVISION DATE | REV. NO. |
|---|---------------|----------|
| 1 | 03 AUG 2024   | R0       |
| 2 | 19 AUG 2024   | R1       |
| 3 | 07 SEP 2024   | R2       |
| 4 | 10 OCT 2024   | R3       |

ENGINEERING CONSULTANTS:

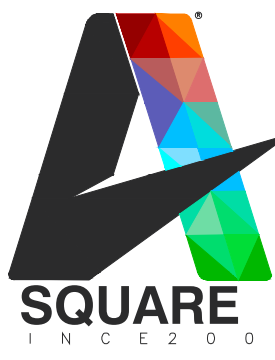

G-31, CEDAR BUILDING, BRIGADE ORCHARDS,  
SPINAL ROAD, DEVANAHALLI, BANGALORE-562110  
Email: Support@a-square.group  
Contact No: +91 9845208299  
www.a-sqaure.group

ARCHITECT NAME

INNOBUILD LANDHOLDINGS

PROJECT NAME:

ALAKANANDA APARTMENTA  
-AT KAVALI

DRAWING TITLE:

POWER SLD

|      |       |       |
|------|-------|-------|
| DRWN | CHD   | APPD  |
| M.F  | ABDUL | ALTAF |

|       |            |      |
|-------|------------|------|
| SCALE | SHEET SIZE | REV. |
| NTS   | A1         | R3   |



# DIESEL GENERATOR SLD

Issued by: \_\_\_\_\_

Issued Date: 10 OCT 2024

A-SQUARE MEP Consultants (hereafter referred to as "A-SQUARE") retains all copyright and other proprietary rights to the drawings created by A-SQUARE. All drawings created by A-SQUARE are protected by Indian and international copyright laws. Any unauthorized reproduction, distribution, or modification of A-SQUARE's drawings is strictly prohibited. A-SQUARE reserves the right to take legal action against any unauthorized use of its drawings. A-SQUARE grants clients a limited, non-exclusive, non-transferable license to use the drawings for the specific project or purpose for which they were created. Clients may not use the drawings for any other purpose without the express written consent of A-SQUARE. Clients may not modify, reproduce, distribute, transmit, display, perform, publish, license, create derivative works from, transfer, or sell any of A-SQUARE's drawings without the prior written consent of A-SQUARE. Clients may not use any of A-SQUARE's drawings as a basis for the design or construction of any other project without the express written consent of A-SQUARE. Clients may not disclose any of A-SQUARE's drawings to any third party without the prior written consent of A-SQUARE. kindly visit our web-site, to know more.

|   | REVISION DATE | REV. NO. |
|---|---------------|----------|
| 1 | 03 AUG 2024   | R0       |
| 2 | 19 AUG 2024   | R1       |
| 3 | 07 SEP 2024   | R2       |
| 4 | 10 OCT 2024   | R3       |




G-31, CEDAR BUILDING, BRIGADE ORCHARDS,  
SPINAL ROAD, DEVANAHALLI, BANGALORE-  
562110  
Email: [Support@A-square.group](mailto:Support@A-square.group)  
Contact No: +91 9845208299  
[www.A-sqaure.group](http://www.A-sqaure.group)

## INNOBUILD LANDHOLDINGS

# ALAKANANDA APARTMENTA -AT KAVALI

DG SLD

|       |               |       |
|-------|---------------|-------|
| DRWN  | CHD           | APPD  |
| M.F   | ABDUL         | ALTAF |
| SCALE | SHEET<br>SIZE | REV.  |
| NTS   | A1            | R3    |

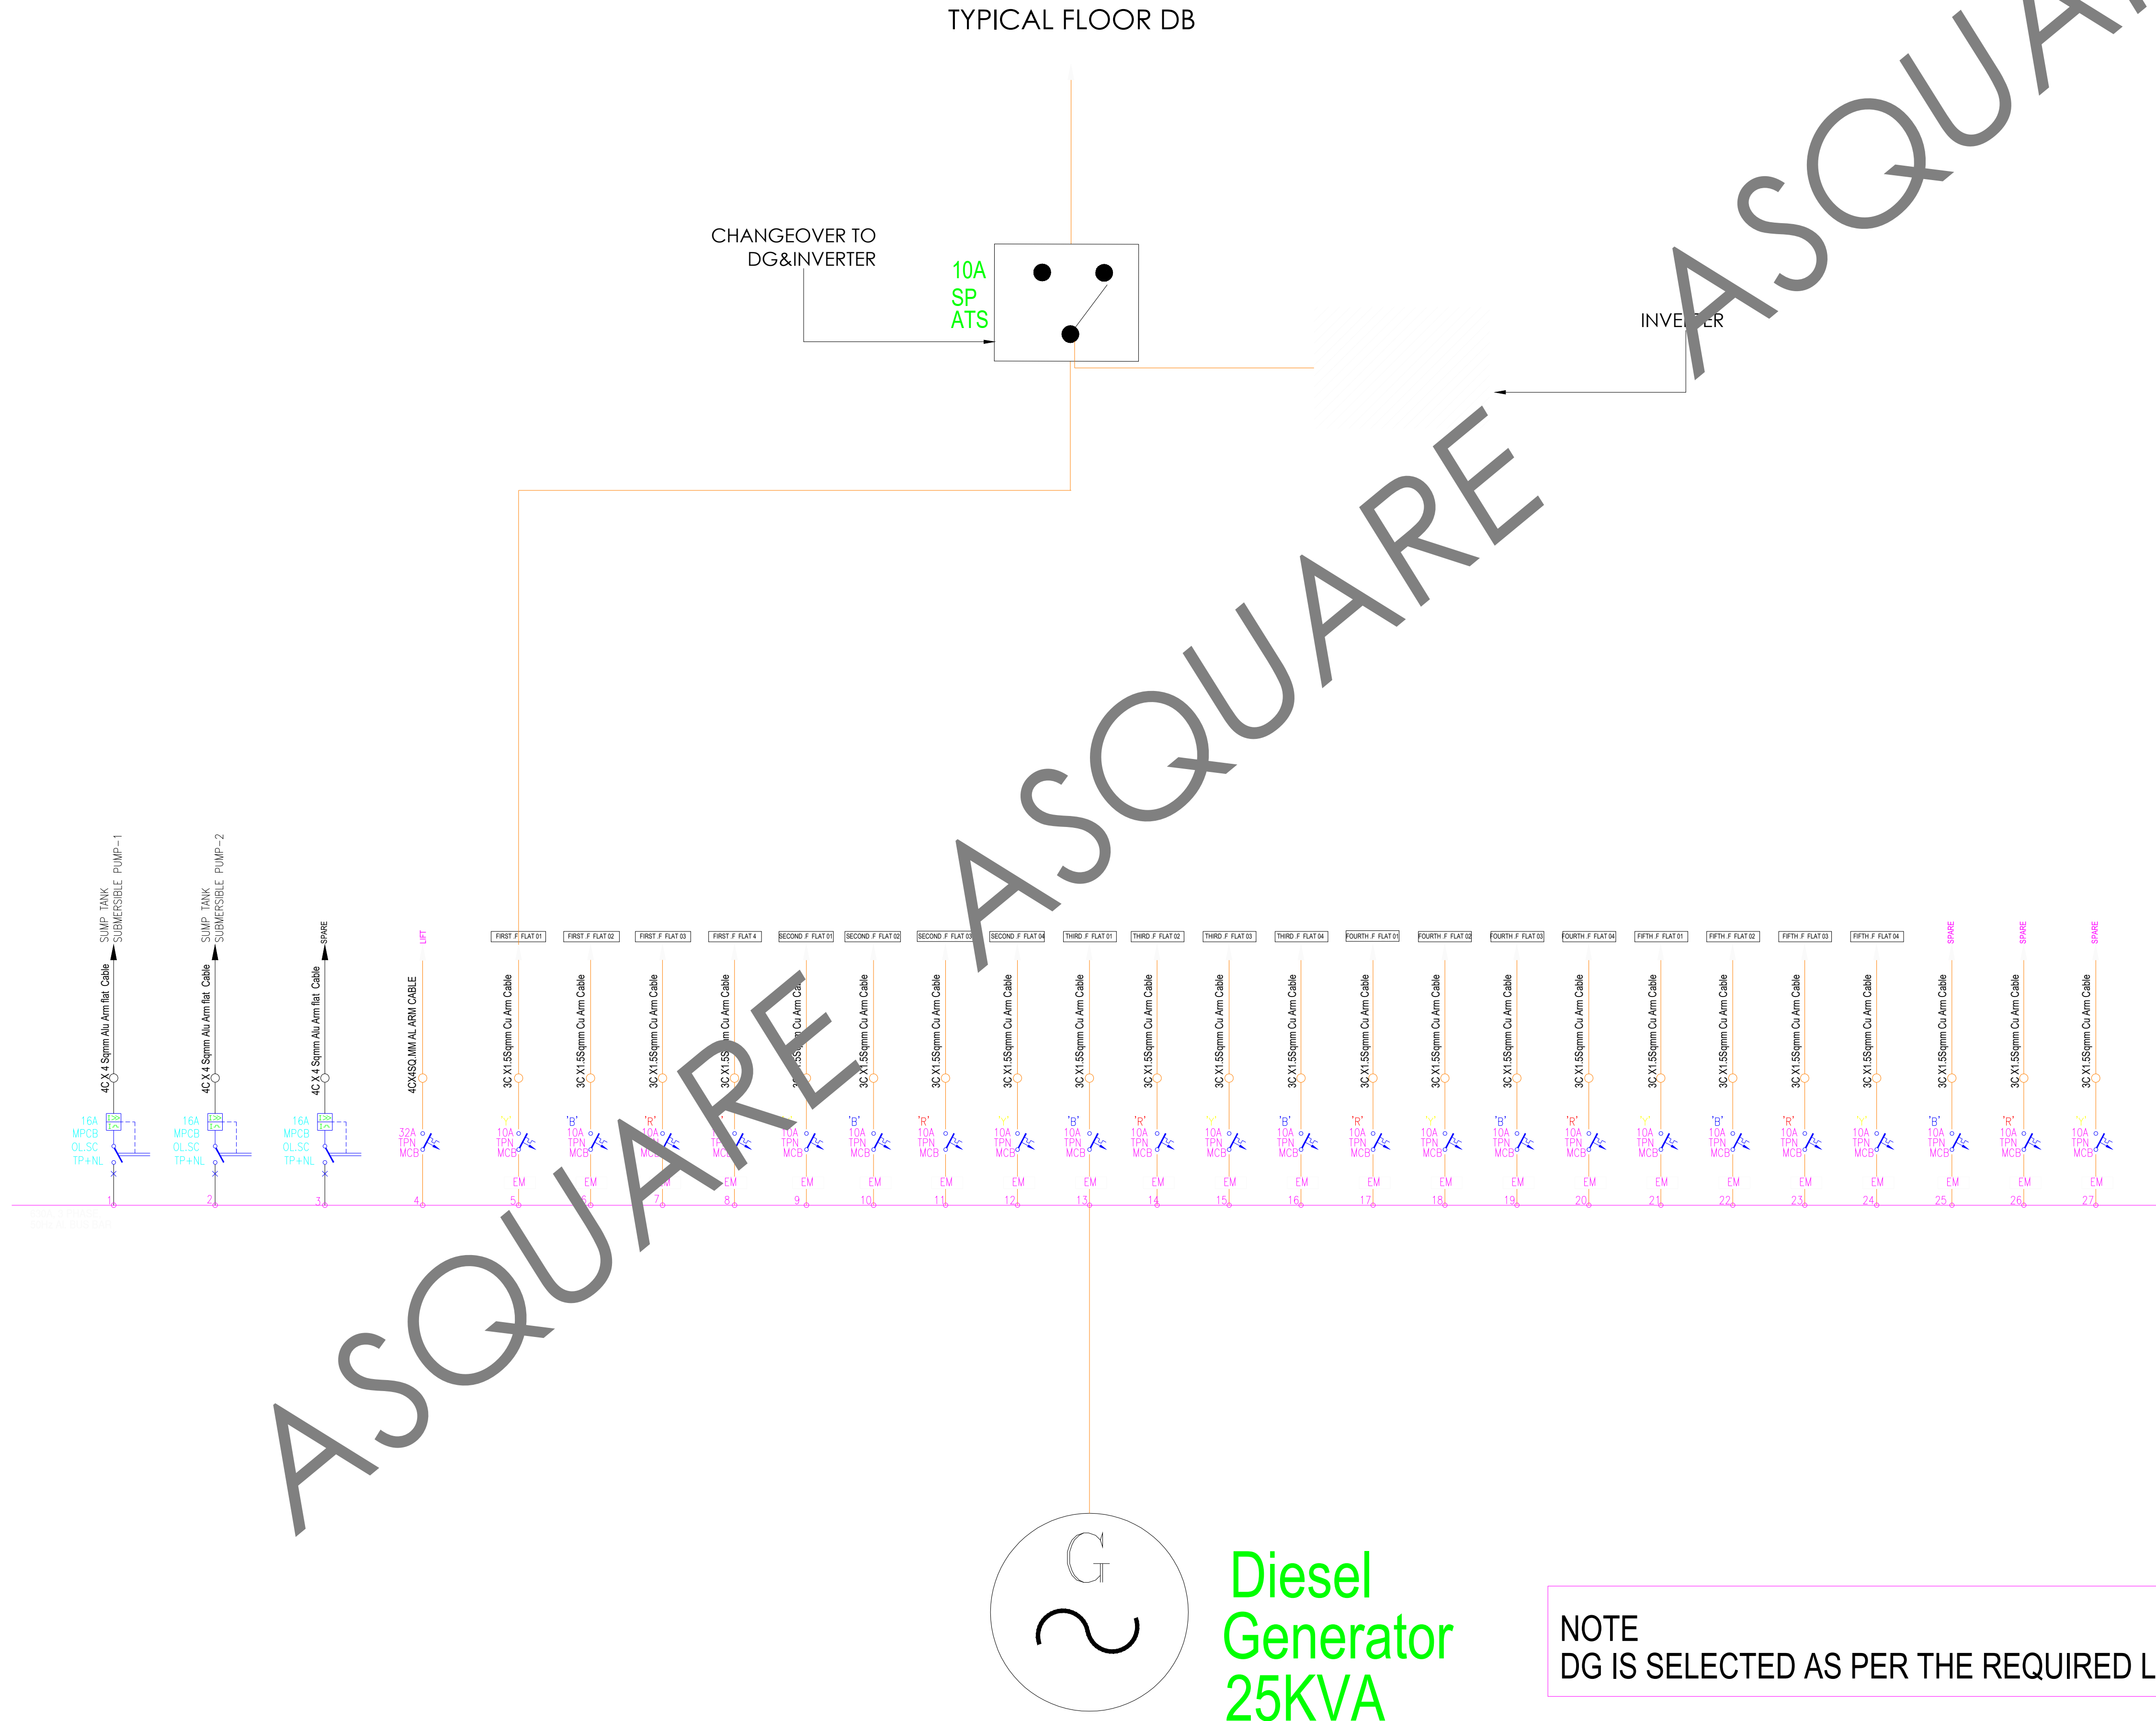

NOTE  
DG IS SELECTED AS PER THE REQUIRED LIGHTING LOAD



GOOD FOR CONSTRUCTION

Issued by: \_\_\_\_\_  
Issued Date: 03 OCT 2024


COPYRIGHT POLICY

A-SQUARE MEP Consultants (hereafter referred to as "A-SQUARE" retains all copyright and other proprietary rights to the drawings created by A-SQUARE. All drawings created by A-SQUARE are protected by Indian and international copyright laws. Any unauthorized reproduction, distribution, or modification of A-SQUARE's drawings is strictly prohibited. A-SQUARE reserves the right to take legal action against any unauthorized use of its drawings. A-SQUARE grants clients a limited, non-exclusive, non-transferable license to use the drawings for the specific project or purpose for which they were created. Clients may not use the drawings for any other purpose without the express written consent of A-SQUARE. Clients may not modify, reproduce, distribute, transmit, display, perform, publish, license, create derivative works from, transfer, or sell any of A-SQUARE's drawings without the prior written consent of A-SQUARE. Clients may not use any of A-SQUARE's drawings as a basis for the design or construction of any other project without the express written consent of A-SQUARE. Clients may not disclose any of A-SQUARE's drawings to any third party without the prior written consent of A-SQUARE. kindly visit our web-site, to know more.

REVISION CHART

|   | REVISION DATE | REV. NO. |
|---|---------------|----------|
| 1 | 03 AUG 2024   | R0       |
| 2 | 19 AUG 2024   | R1       |
| 3 | 07 SEP 2024   | R2       |
| 4 | 10 OCT 2024   | R3       |

ENGINEERING CONSULTANTS:

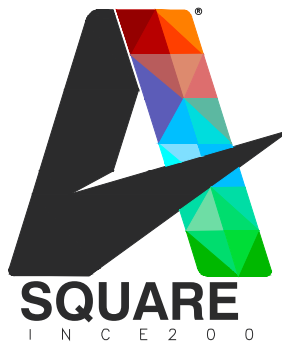

G-31, CEDAR BUILDING, BRIGADE ORCHARDS,  
SPINAL ROAD, DEVANAHALLI, BANGALORE-562110  
Email: Support@a-square.group  
Contact No: +91 9845208299  
www.a-sqaure.group

ARCHITECT NAME

INNOBUILD LANDHOLDINGS

PROJECT NAME:

ALAKANANDA APARTMENTA  
-AT KAVALI

DRAWING TITLE:

EARTHING SLD

|      |       |       |
|------|-------|-------|
| DRWN | CHD   | APPD  |
| M.F  | ABDUL | ALTAF |

|       |            |      |
|-------|------------|------|
| SCALE | SHEET SIZE | REV. |
| NTS   | A1         | R3   |