

S.N.	SYM.	NOM.	DESCRIPTION
1.			450 x 50 mm Cable Tray
2.			300 x 50 mm Cable Tray
3.			150 x 50 mm Cable Tray
4.			100 x 50 mm Cable Tray
5.			75 x 25 mm Cable Tray

S.N.	SYM.	DESCRIPTION
1.		Dome Camera with microphone
2.	NVR	Network Video Recorder
3.	POE SWITCH	Power over Ethernet Switch
4.		Outdoor Bullet Camera with microphone

MEP CONSULTANTS:



1st Floor, APR & MRS ARCADE,
Vijayapura Road, Devanahalli,
BENGALURU INDIA , 562110

A-SQUARE MEP Consultants (hereafter referred to as "A-SQUARE") retains all copyright and other proprietary rights to the drawings created by A-SQUARE. All drawings created by A-SQUARE are protected by Indian and international copyright laws. Any unauthorized reproduction, distribution, or modification of A-SQUARE's drawings is strictly prohibited. A-SQUARE reserves the right to take legal action against any unauthorized use of its drawings. A-SQUARE grants clients a limited, non-exclusive, non-transferable license to use the drawings for the specific project or purpose for which they were created. Clients may not use the drawings for any other purpose without the express written consent of A-SQUARE. Clients may not modify, reproduce, distribute, transmit, display, perform, publish, license, create derivative works from, transfer, or sell any of A-SQUARE's drawings without the prior written consent of A-SQUARE. Clients may not use any of A-SQUARE's drawings as a basis for the design or construction of any other project without the express written consent of A-SQUARE. Clients may not disclose any of A-SQUARE's drawings to any third party without the prior written consent of A-SQUARE. kindly visit our web-site, to know more.

GENERAL NOTES

- All dimensions are in millimeters (mm); follow written dimensions, do not scale.
- Drawings must be coordinated across all disciplines; report discrepancies before execution.
- Designs comply with NBC, ASHRAE, NEC, IPC, NFPA, and other applicable architectural & MEP standards.
- Use only the latest issued drawings; verify all dimensions and site conditions before execution.

VERSION CHART

VERSION NO.	VERSION DATE
GFC	20-MAR-2025

ISSUED FOR:

GOOD FOR CONSTRUCTION

ARCHITECT / INTERIOR CONSULTANTS:



PROJECT:



Bommasandra Industrial Area, Bommasandra
Village, Anekal TK, Bengaluru (Bangalore)
Urban, Karnataka, Bangalore, 560099

CLIENT:

DR. VIKRAM
Dhyan Dishes LLP

ISSUED DATE:

20-MAR-2025

DRAWN BY:

DA

CHECKED BY:

SK

APPROVED BY

AA

SHEET TITLE:


GROUND FLOOR CCTV & DETECTOR CABLE TRAY
LAYOUT

SHEET SIZE:

A3

DRAWING NO:

ASC-ELE-TRC-005

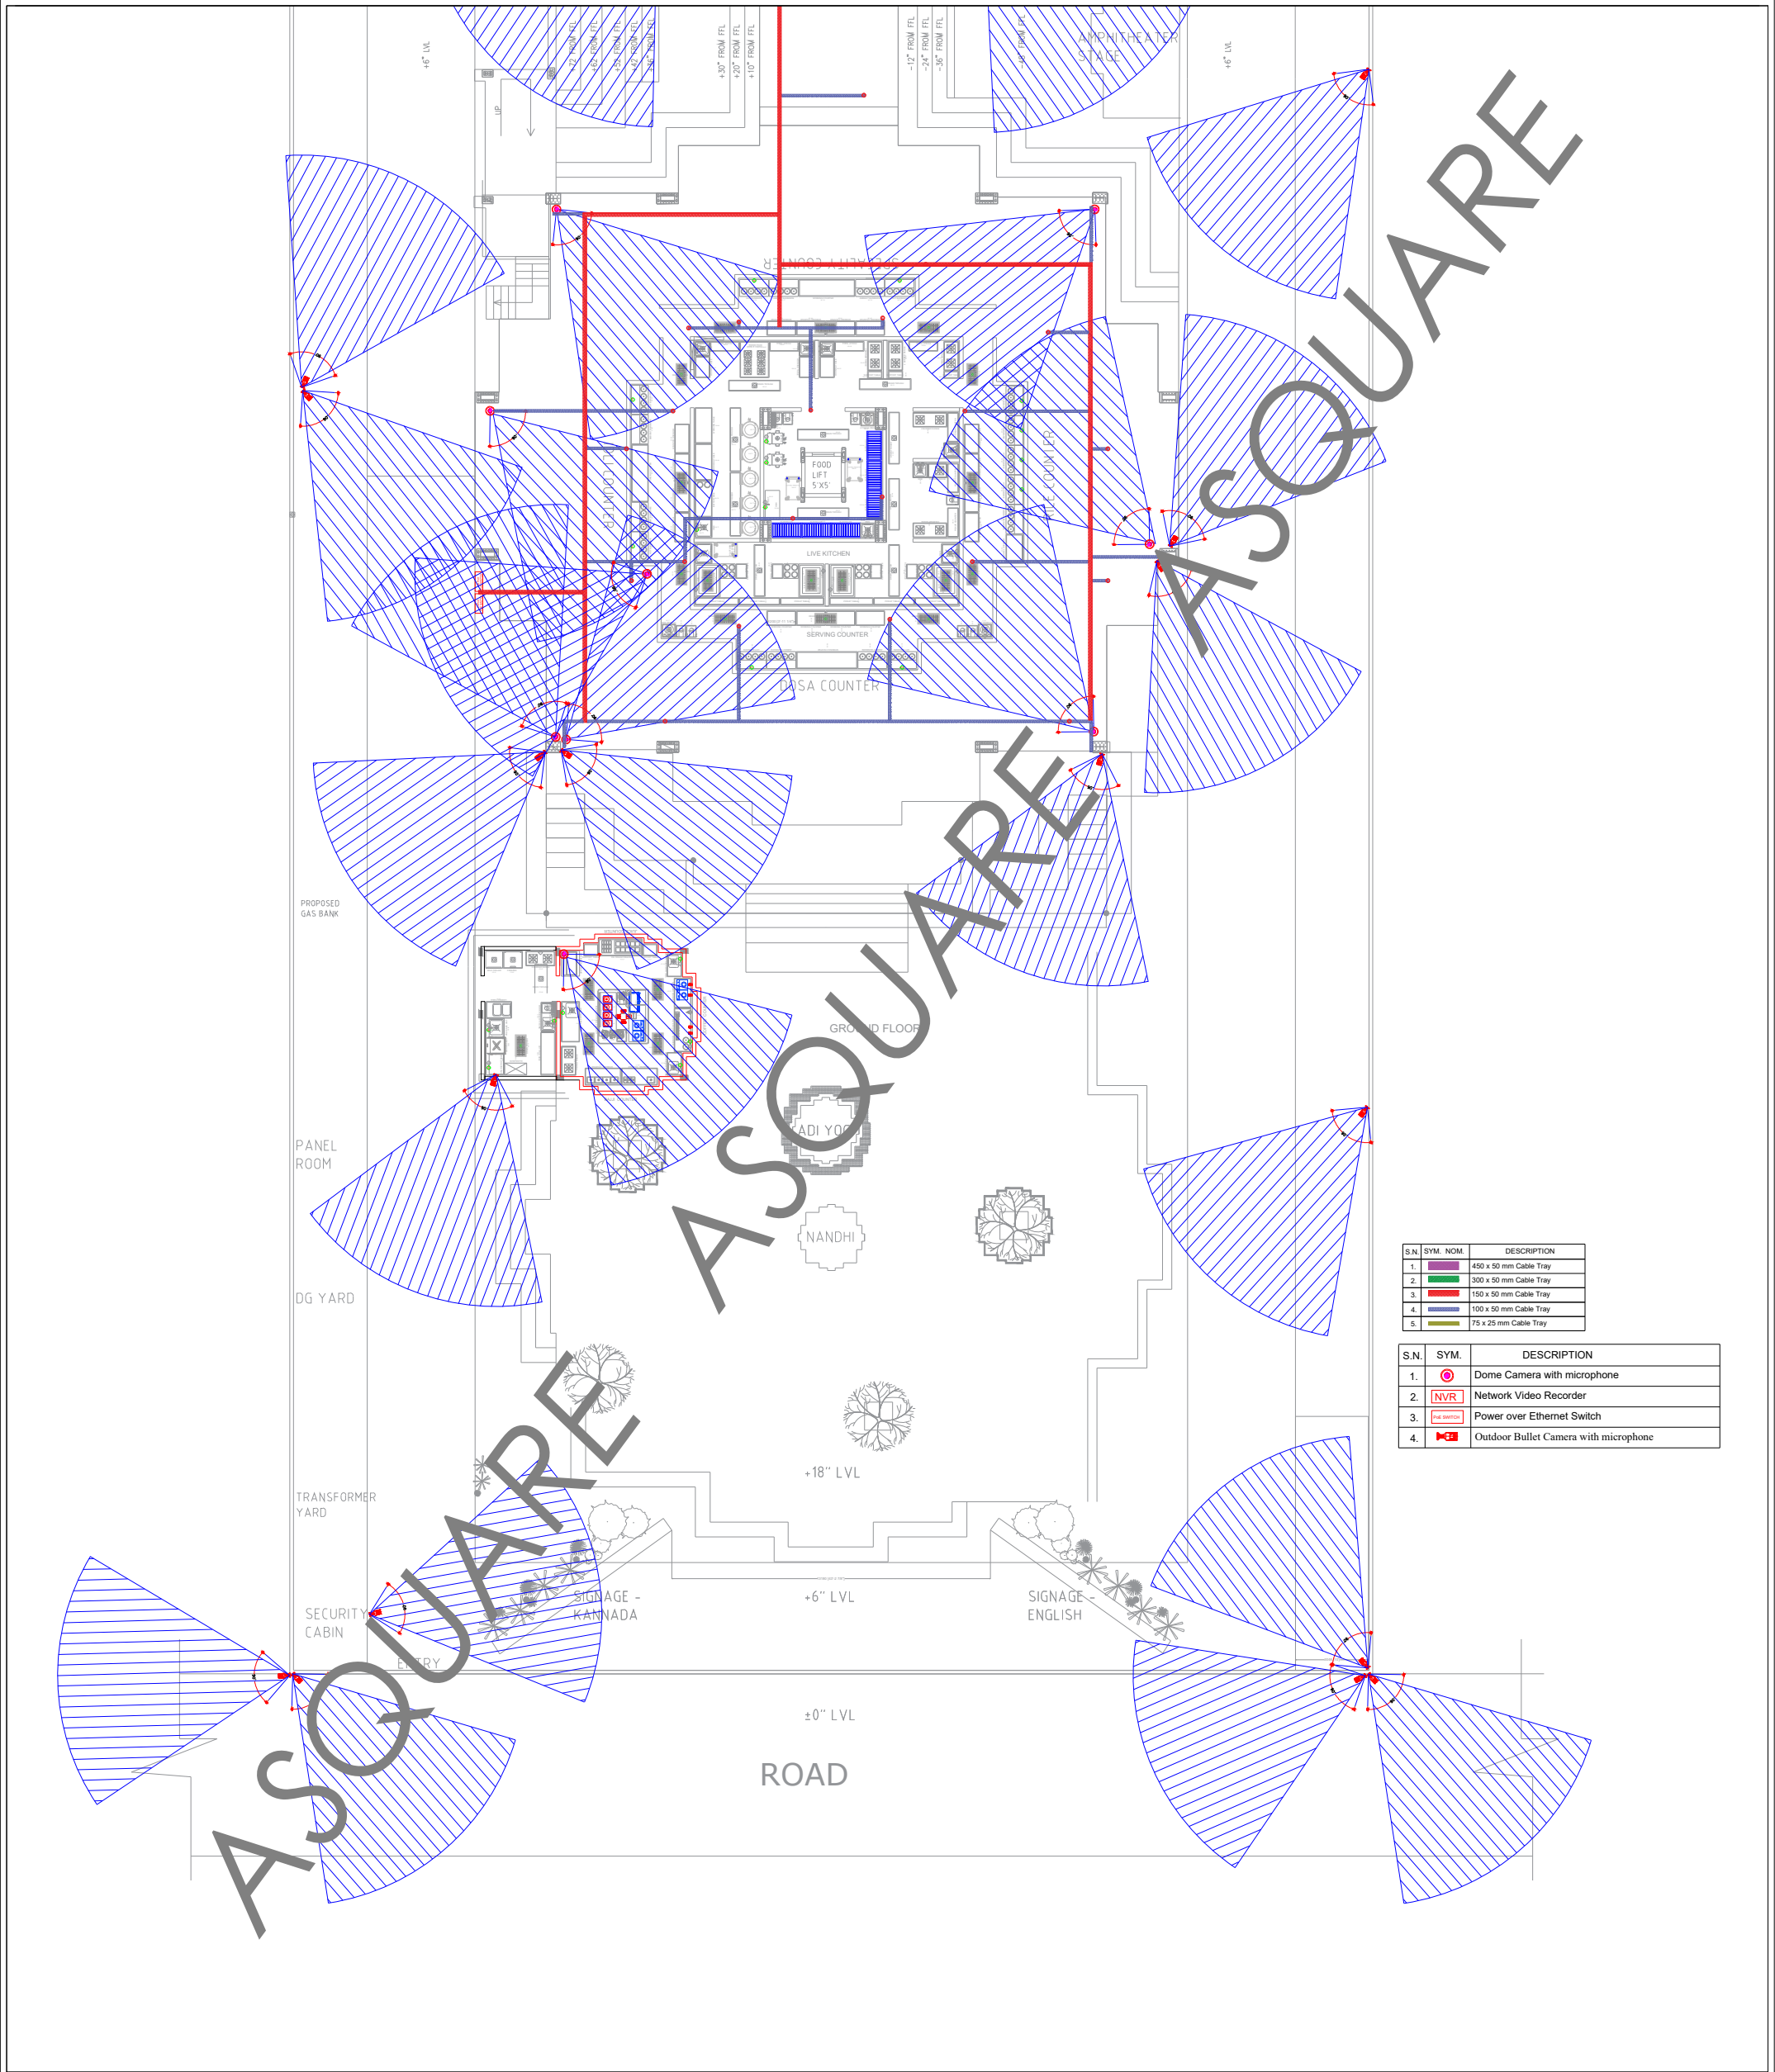

S.N.	SYM.	NOM.	DESCRIPTION
1.			450 x 50 mm Cable Tray
2.			300 x 50 mm Cable Tray
3.			150 x 50 mm Cable Tray
4.			100 x 50 mm Cable Tray
5.			75 x 25 mm Cable Tray

S.N.	SYM.	DESCRIPTION
1.		Dome Camera with microphone
2.	NVR	Network Video Recorder
3.	POE SWITCH	Power over Ethernet Switch
4.	OUTDOOR BULLET CAMERA	Outdoor Bullet Camera with microphone

MEP CONSULTANTS:



1st Floor, APR & MRS ARCADE,
Vijayapura Road, Devanahalli,
BENGALURU INDIA , 562110

A-SQUARE MEP Consultants (hereafter referred to as "A-SQUARE") retains all copyright and other proprietary rights to the drawings created by A-SQUARE. All drawings created by A-SQUARE are protected by Indian and international copyright laws. Any unauthorized reproduction, distribution, or modification of A-SQUARE's drawings is strictly prohibited. A-SQUARE reserves the right to take legal action against any unauthorized use of its drawings. A-SQUARE grants clients a limited, non-exclusive, non-transferable license to use the drawings for the specific project or purpose for which they were created. Clients may not use the drawings for any other purpose without the express written consent of A-SQUARE. Clients may not modify, reproduce, distribute, transmit, display, perform, publish, license, create derivative works from, transfer, or sell any of A-SQUARE's drawings without the prior written consent of A-SQUARE. Clients may not use any of A-SQUARE's drawings as a basis for the design or construction of any other project without the express written consent of A-SQUARE. Clients may not disclose any of A-SQUARE's drawings to any third party without the prior written consent of A-SQUARE. kindly visit our web-site, to know more.

GENERAL NOTES

- All dimensions are in millimeters (mm); follow written dimensions, do not scale.
- Drawings must be coordinated across all disciplines; report discrepancies before execution.
- Designs comply with NBC, ASHRAE, NEC, IPC, NFPA, and other applicable architectural & MEP standards.
- Use only the latest issued drawings; verify all dimensions and site conditions before execution.

VERSION CHART

VERSION NO.	VERSION DATE
GFC	20-MAR-2025

ISSUED FOR:

GOOD FOR CONSTRUCTION

ARCHITECT / INTERIOR CONSULTANTS:



PROJECT:



Bommasandra Industrial Area, Bommasandra
Village, Anekal TK, Bengaluru (Bangalore)
Urban, Karnataka, Bangalore, 560099

CLIENT:

DR. VIKRAM
Dhyani Dishes LLP

ISSUED DATE:

20-MAR-2025

DRAWN BY:

DA

CHECKED BY:

SK

APPROVED BY

AA

SHEET TITLE:


GROUND FLOOR CCTV & DETECTOR CABLE
TRAY LAYOUT

SHEET SIZE:

A3

DRAWING NO:

ASC-ELE-TRC-005-A

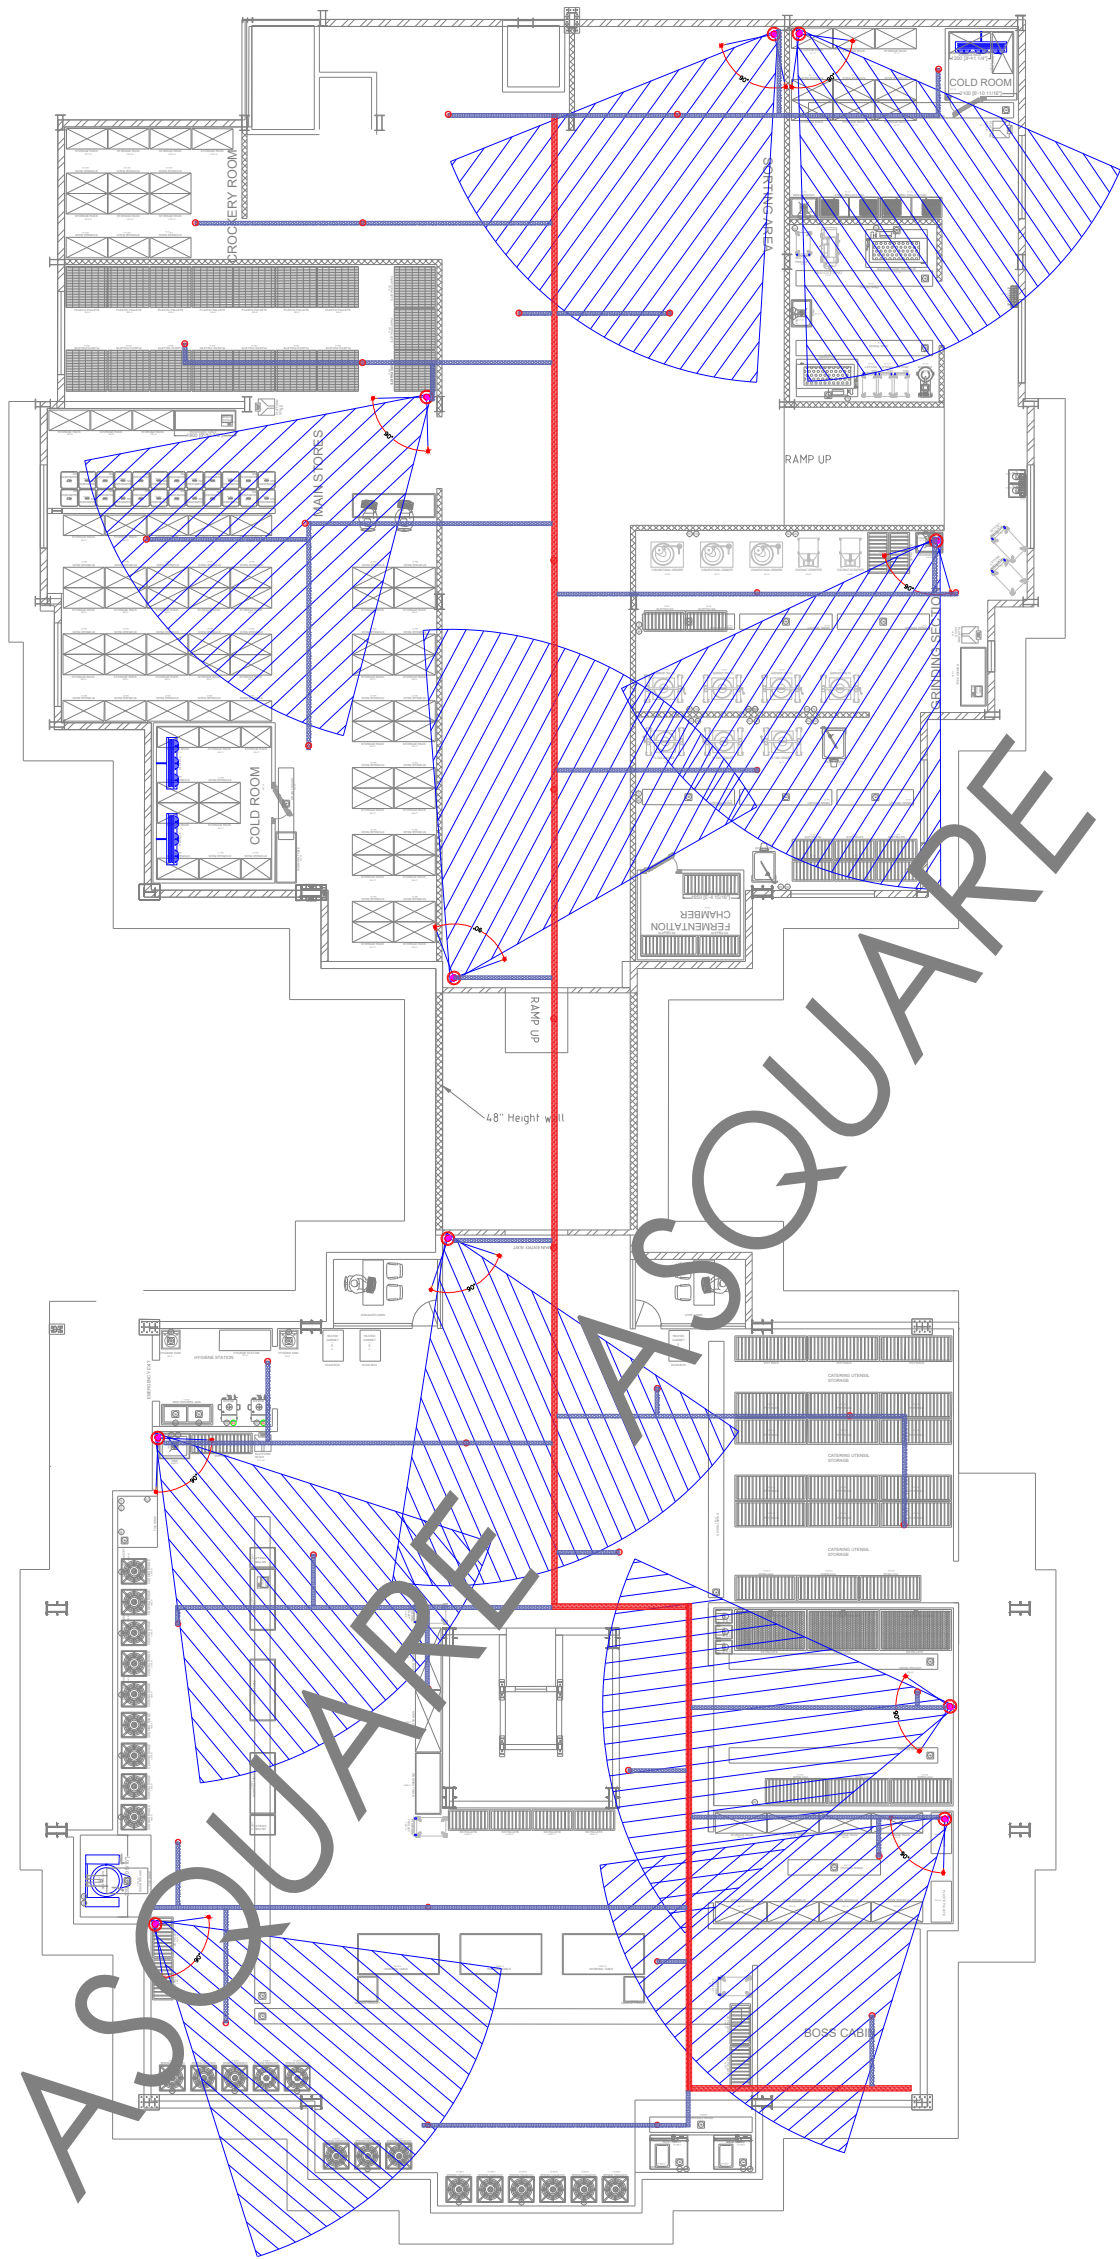

S.N.	SYM.	NOM.	DESCRIPTION
1.			450 x 50 mm Cable Tray
2.			300 x 50 mm Cable Tray
3.			150 x 50 mm Cable Tray
4.			100 x 50 mm Cable Tray
5.			75 x 25 mm Cable Tray

S.N.	SYM.	DESCRIPTION
1.		Dome Camera
2.		Network Video Recorder
3.		Power over Ethernet Switch
4.		Bullet Camera with water proof

MEP CONSULTANTS:



1st Floor,APR & MRS ARCADE,
Vijayapura Road,Devanahalli,
BENGALURU INDIA , 562110

A-SQUARE MEP Consultants (hereafter referred to as "A-SQUARE") retains all copyright and other proprietary rights to the drawings created by A-SQUARE. All drawings created by A-SQUARE are protected by Indian and international copyright laws. Any unauthorized reproduction, distribution, or modification of A-SQUARE's drawings is strictly prohibited. A-SQUARE reserves the right to take legal action against any unauthorized use of its drawings. A-SQUARE grants clients a limited, non-exclusive, non-transferable license to use the drawings for the specific project or purpose for which they were created. Clients may not use the drawings for any other purpose without the express written consent of A-SQUARE. Clients may not modify, reproduce, distribute, transmit, display, perform, publish, license, create derivative works from, transfer, or sell any of A-SQUARE's drawings without the prior written consent of A-SQUARE. Clients may not use any of A-SQUARE's drawings as a basis for the design or construction of any other project without the express written consent of A-SQUARE. Clients may not disclose any of A-SQUARE's drawings to any third party without the prior written consent of A-SQUARE. kindly visit our web-site, to know more.

GENERAL NOTES

- All dimensions are in millimeters (mm); follow written dimensions, do not scale.
- Drawings must be coordinated across all disciplines; report discrepancies before execution.
- Designs comply with NBC, ASHRAE, NEC, IPC, NFPA, and other applicable architectural & MEP standards.
- Use only the latest issued drawings; verify all dimensions and site conditions before execution.

VERSION CHART

VERSION NO.	VERSION DATE
GFC	20-MAR-2025

ISSUED FOR:

GOOD FOR CONSTRUCTION

ARCHITECT / INTERIOR CONSULTANTS:



PROJECT:



Bommasandra Industrial Area, Bommasandra
Village, Anekal TK, Bengaluru (Bangalore)
Urban, Karnataka, Bangalore, 560099

CLIENT:

DR. VIKRAM
Dhyan Dishes LLP

ISSUED DATE:

20-MAR-2025

DRAWN BY:

DA

CHECKED BY:

SK

APPROVED BY

AA

SHEET TITLE:


FIRST FLOOR CCTV & DETECTOR CABLE TRAY
LAYOUT

SHEET SIZE:

A3

DRAWING NO:

ASC-ELE-TRC-005-B

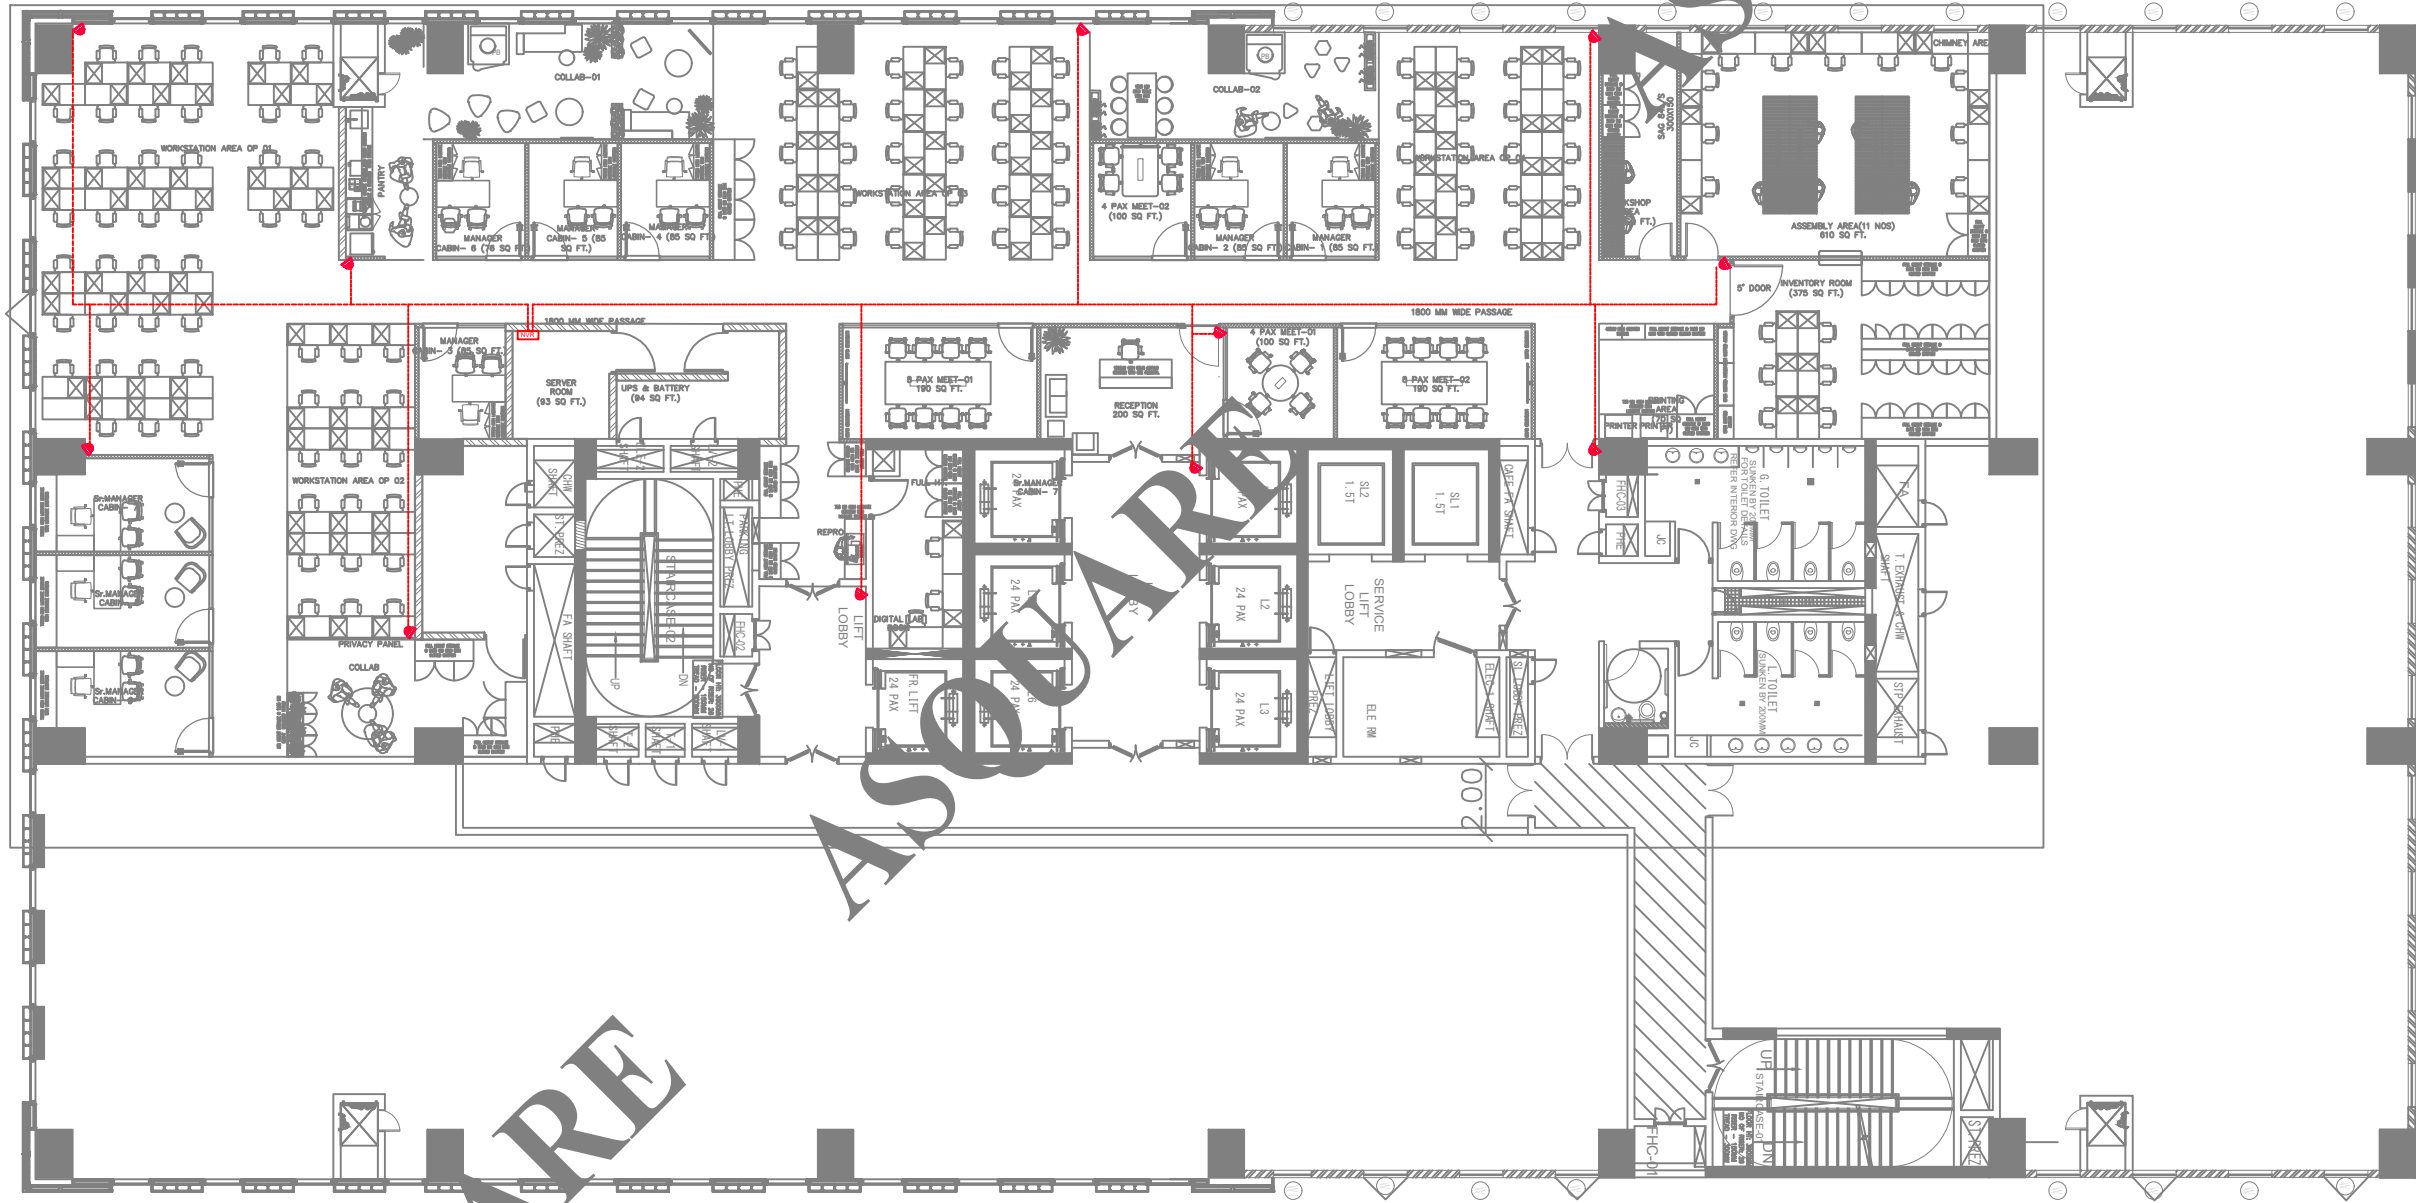

LOW VOLTAGE LEGEND		
S.N.	LEGEND	DESCRIPTION
1.		-Network Video Recorder
2.		-25mm dia PVC Conduit for CCTV
3.		-IP Dome CCTV

MEP CONSULTANTS:



1st Floor, APR & MRS ARCADE,
Vijayapura Road, Devanahalli,
BENGALURU INDIA , 562110

A-SQUARE MEP Consultants (hereafter referred to as "A-SQUARE") retains all copyright and other proprietary rights to the drawings created by A-SQUARE. All drawings created by A-SQUARE are protected by Indian and international copyright laws. Any unauthorized reproduction, distribution, or modification of A-SQUARE's drawings is strictly prohibited. A-SQUARE reserves the right to take legal action against any unauthorized use of its drawings. A-SQUARE grants clients a limited, non-exclusive, non-transferable license to use the drawings for the specific project or purpose for which they were created. Clients may not use the drawings for any other purpose without the express written consent of A-SQUARE. Clients may not modify, reproduce, distribute, transmit, display, perform, publish, license, create derivative works from, transfer, or sell any of A-SQUARE's drawings without the prior written consent of A-SQUARE. Clients may not use any of A-SQUARE's drawings as a basis for the design or construction of any other project without the express written consent of A-SQUARE. Clients may not disclose any of A-SQUARE's drawings to any third party without the prior written consent of A-SQUARE. kindly visit our web-site, to know more.

GENERAL NOTES

- All dimensions are in millimeters (mm); follow written dimensions, do not scale.
- Drawings must be coordinated across all disciplines; report discrepancies before execution.
- Designs comply with NBC, ASHRAE, NEC, IPS, and other applicable architectural & MEP standards.
- Use only the latest issued drawings; verify all dimensions and site conditions before execution.

VERSION CHART

VERSION NO.	VERSION DATE
APPROVAL-01	08-MAR-2025
GFC	27-MAR-2025

ARCHITECT / INTERIOR CONSULTANT:



#12, 3RD FLOOR, 60FT ROAD,
6TH BLOCK, KORMANGALA,
BENGALURU 560034, INDIA

PROJECT:

ASTROME
BRIGADE DECCAN HEIGHTS

ASTROME TECHNOLOGIES

ISSUED FOR:

GOOD FOR CONSTRUCTION

ISSUED DATE:

27-MAR-2025

DRAWN BY:

DA

CHECKED BY:

SK

APPROVED BY

AA

SHEET TITLE:


CCTV LAYOUT

SHEET SIZE:

A3


DRAWING NO:

ASC-ELE-ATM-011

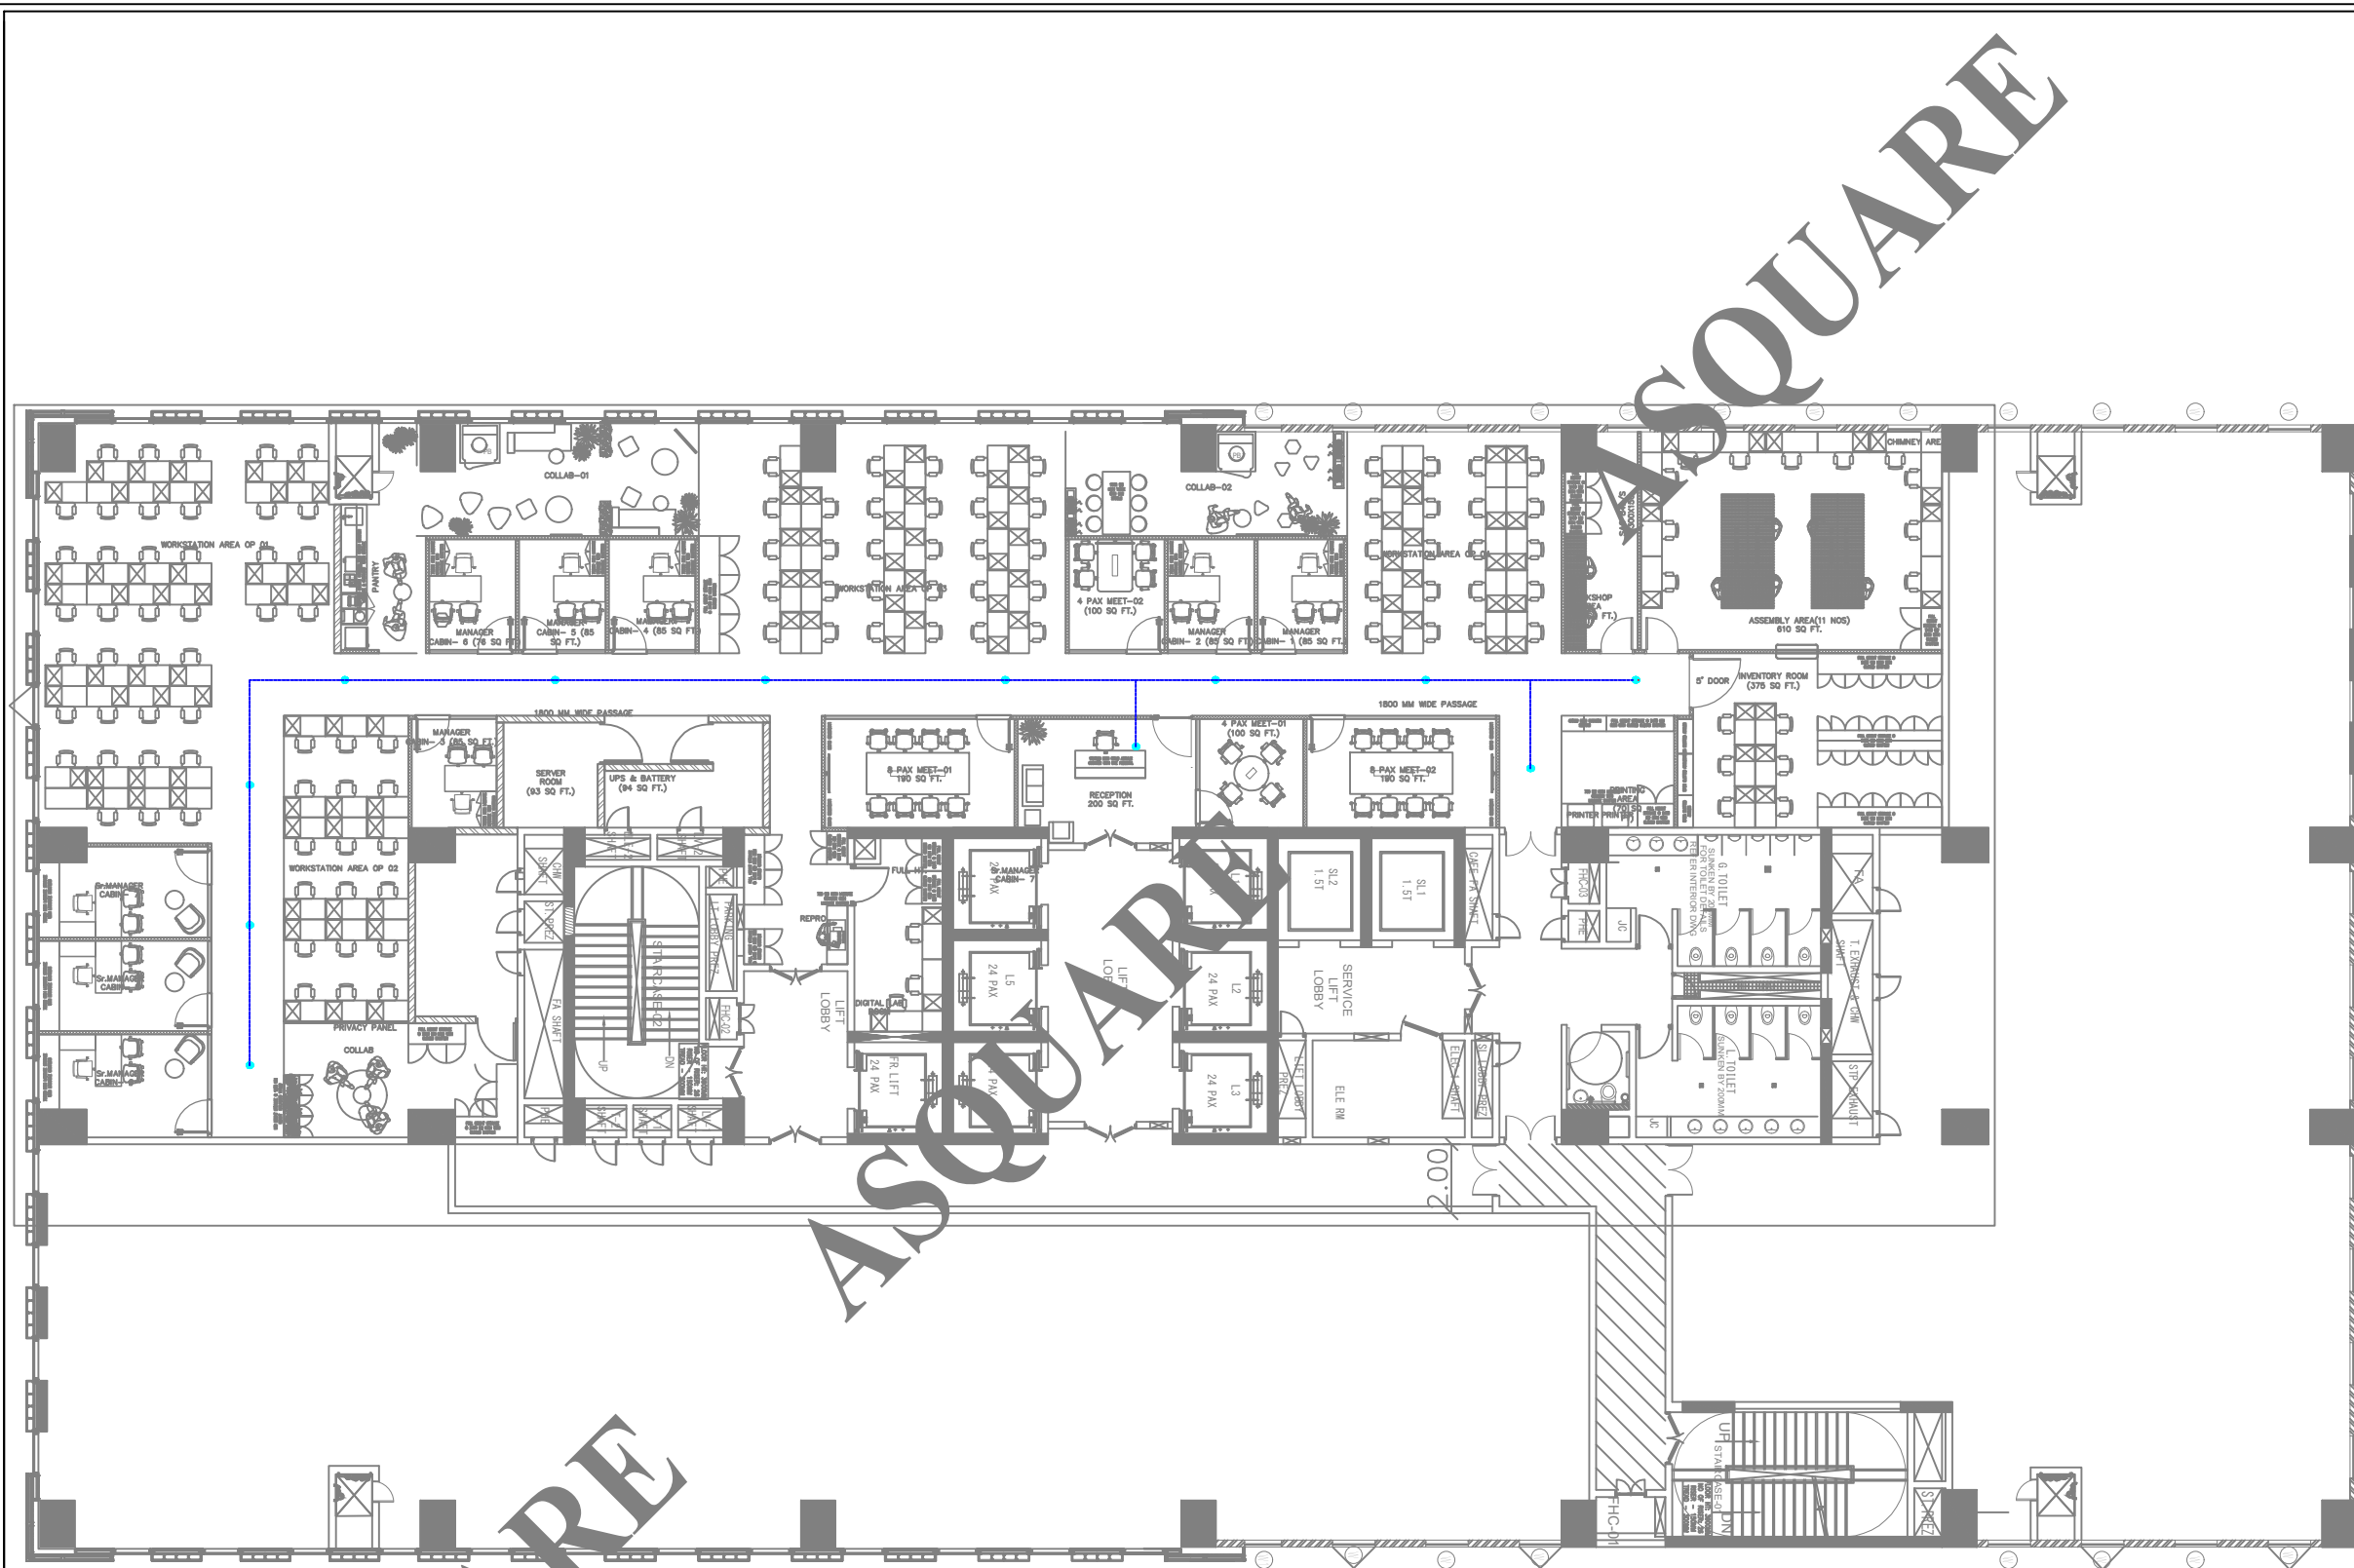

NOTE:-
1. The amplifier location will be provided by the client.
2. Power Amplifier is 100W.

LOW VOLTAGE LEGEND			
S.N.	LEGEND	DESCRIPTION	QTY.
1.		-6W CEILING SPEAKER	
2.		-20mm dia PVC Conduit for Ceiling Speaker	


MEP CONSULTANTS:

1st Floor, APR & MRS ARCADE,
Vijayapura Road, Devanahalli,
BENGALURU INDIA , 562110

A-SQUARE MEP Consultants (hereafter referred to as "A-SQUARE") retains all copyright and other proprietary rights to the drawings created by A-SQUARE. All drawings created by A-SQUARE are protected by Indian and international copyright laws. Any unauthorized reproduction, distribution, or modification of A-SQUARE's drawings is strictly prohibited. A-SQUARE reserves the right to take legal action against any unauthorized use of its drawings. A-SQUARE grants clients a limited, non-exclusive, non-transferable license to use the drawings for the specific project or purpose for which they were created. Clients may not use the drawings for any other purpose without the express written consent of A-SQUARE. Clients may not modify, reproduce, distribute, transmit, display, perform, publish, license, create derivative works from, transfer, or sell any of A-SQUARE's drawings without the prior written consent of A-SQUARE. Clients may not use any of A-SQUARE's drawings as a basis for the design or construction of any other project without the express written consent of A-SQUARE. Clients may not disclose any of A-SQUARE's drawings to any third party without the prior written consent of A-SQUARE. kindly visit our web-site, to know more.

GENERAL NOTES
1. All dimensions are in millimeters (mm); follow written dimensions, do not scale.
2. Drawings must be coordinated across all disciplines; report discrepancies before execution.
3. Designs comply with NBC, ASHRAE, NEC, IPS, and other applicable architectural & MEP standards.
4. Use only the latest issued drawings; verify all dimensions and site conditions before execution.

VERSION CHART

VERSION NO.	VERSION DATE
APPROVAL-01	08-MAR-2025
GFC	27-MAR-2025

ARCHITECT / INTERIOR CONSULTANT:

#12, 3RD FLOOR, 60FT ROAD,
6TH BLOCK, KORMANGALA,
BENGALURU 560034, INDIA

PROJECT:
**ASTROME
BRIGADE DECCAN HEIGHTS**

ASTROME TECHNOLOGIES

ISSUED FOR:
GOOD FOR CONSTRUCTION



ISSUED DATE:
27-MAR-2025

DRAWN BY: DA
CHECKED BY: SK
APPROVED BY: AA

SHEET TITLE:
SPEAKER LAYOUT

SHEET SIZE: A3

DRAWING NO:
ASC-HVAC-ATM-017

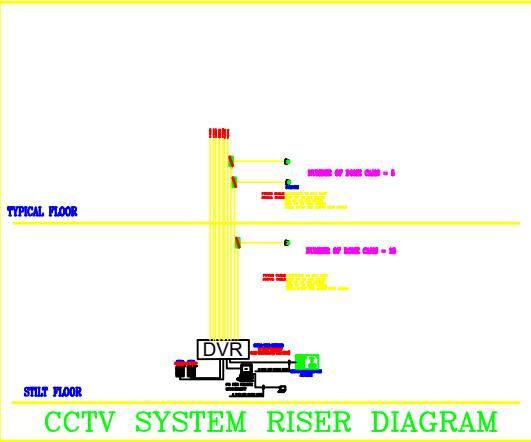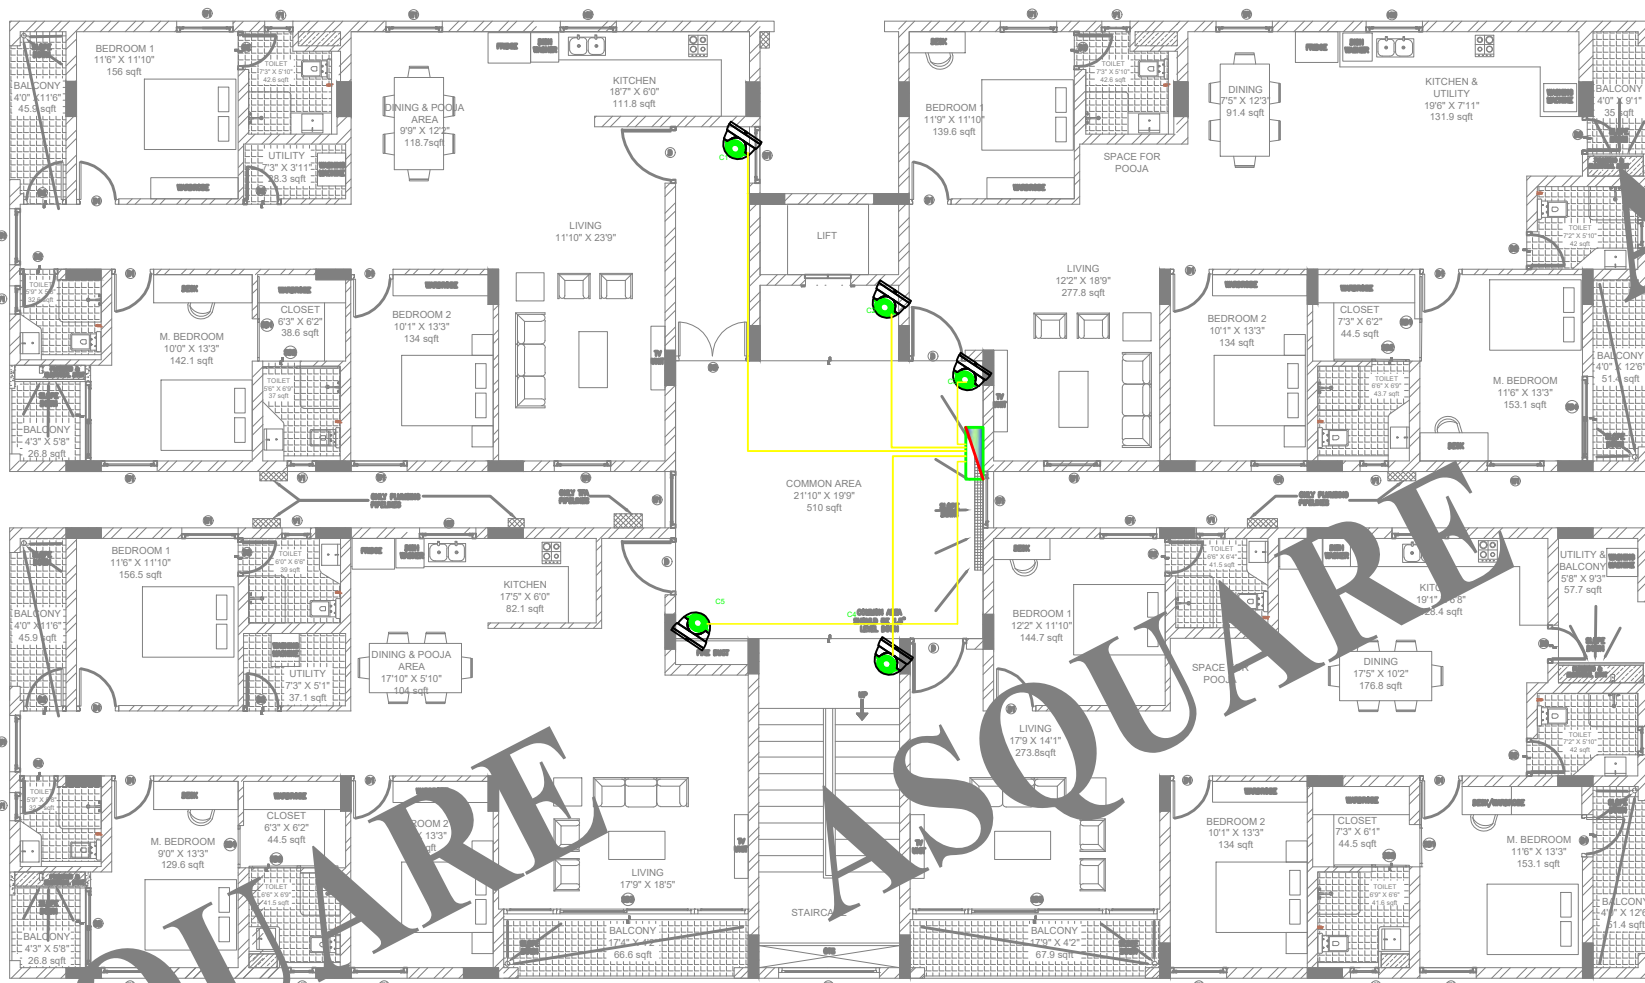

LEGEND	
DOME CAM	
EXTRA LOW VOLTAGE DB	
(KEYPAD CONTROLLER) WITH JOYSTICK	
LCD 21"	
RECORD & SHOW UNIT (DVR)	

NOTE : All Cable Should be
FRLS cable Drawn in MS conduit

GOOD FOR CONSTRUCTION

Issued by: _____
Issued Date: 03 OCT 2024

REVISION CHART

	REVISION DATE	REV. NO.
1	15-07-2024	R0
2	24-08-2024	R1
3	09-09-2024	R2
4		

COPYRIGHT POLICY

A-SQUARE MEP Consultants (hereafter referred to as "A-SQUARE") retains all copyright and other proprietary rights to the drawings created by A-SQUARE. All drawings created by A-SQUARE are protected by Indian and international copyright laws. Any unauthorized reproduction, distribution, or modification of A-SQUARE's drawings is strictly prohibited. A-SQUARE reserves the right to take legal action against any unauthorized use of its drawings. A-SQUARE grants clients a limited, non-exclusive, non-transferable license to use the drawings for the specific project or purpose for which they were created. Clients may not use the drawings for any other purpose without the express written consent of A-SQUARE. Clients may not modify, reproduce, distribute, transmit, display, perform, publish, license, create derivative works from, transfer, or sell any of A-SQUARE's drawings without the prior written consent of A-SQUARE. Clients may not use any of A-SQUARE's drawings as a basis for the design or construction of any other project without the express written consent of A-SQUARE. Clients may not disclose any of A-SQUARE's drawings to any third party without the prior written consent of A-SQUARE. kindly visit our web-site, to know more.

ENGINEERING CONSULTANTS:



G-31, CEDAR BUILDING, BRIGADE ORCHARDS,
SPINAL ROAD, DEVANAHALLI,
BANGALORE- 562110
Email: Support@a-square.group
Contact No: +91 9845208299
www.a-sqaure.group

ARCHITECT NAME

INNOBUILD LANDHOLDINGS PVT. LTD
#460, 17th cross, 4th sector, CS Towers, HSR
layout, Bangalore 560102


PROJECT NAME:

ALAKANANDA APARTMENTS AT KAVALI


DRAWING TITLE:

CCTV LAYOUT

DRWN	CHD	APPD
VIJAY	AA	ALTAF
SCALE	SHEET SIZE	REV.
NTS	A1	R2

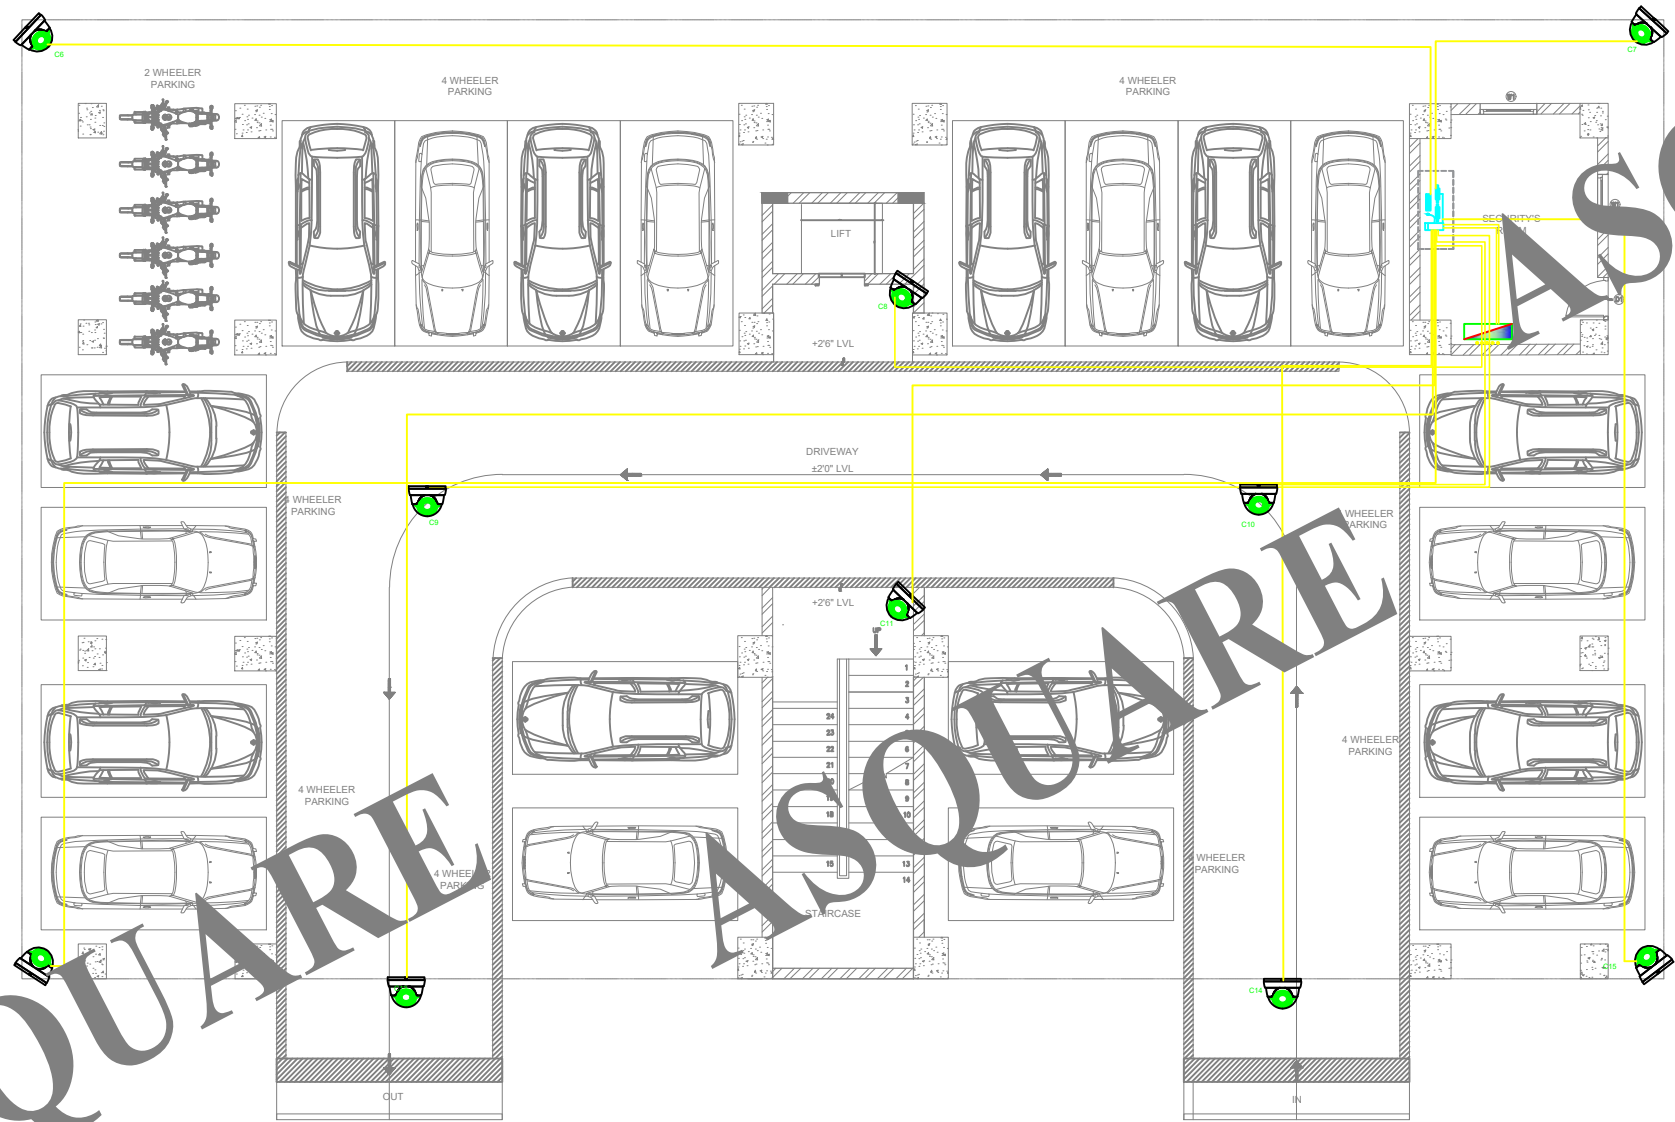

NOTE : All Cable Should be
FRLS cable Drawn in MS conduit

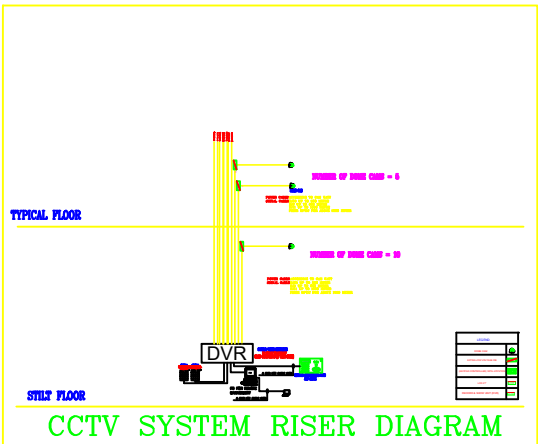

GOOD FOR CONSTRUCTION

Issued by: _____
Issued Date: 03 OCT 2024

REVISION CHART

	REVISION DATE	REV. NO.
1	15-07-2024	R0
2	24-08-2024	R1
3	09-09-2024	R2
4		

COPYRIGHT POLICY

A-SQUARE MEP Consultants (hereafter referred to as "A-SQUARE") retains all copyright and other proprietary rights to the drawings created by A-SQUARE. All drawings created by A-SQUARE are protected by Indian and international copyright laws. Any unauthorized reproduction, distribution, or modification of A-SQUARE's drawings is strictly prohibited. A-SQUARE reserves the right to take legal action against any unauthorized use of its drawings. A-SQUARE grants clients a limited, non-exclusive, non-transferable license to use the drawings for the specific project or purpose for which they were created. Clients may not use the drawings for any other purpose without the express written consent of A-SQUARE. Clients may not modify, reproduce, distribute, transmit, display, perform, publish, license, create derivative works from, transfer, or sell any of A-SQUARE's drawings without the prior written consent of A-SQUARE. Clients may not use any of A-SQUARE's drawings as a basis for the design or construction of any other project without the express written consent of A-SQUARE. Clients may not disclose any of A-SQUARE's drawings to any third party without the prior written consent of A-SQUARE. kindly visit our web-site, to know more.

ENGINEERING CONSULTANTS:



G-31, CEDAR BUILDING, BRIGADE ORCHARDS,
SPINAL ROAD, DEVANAHALLI,
BANGALORE- 562110
Email: Support@a-square.group
Contact No: +91 9845208299
www.a-sqaure.group

ARCHITECT NAME

INNOBUILD LANDHOLDINGS PVT. LTD
#460, 17th cross, 4th sector, CS Towers, HSR
layout, Bangalore 560102

PROJECT NAME:

ALAKANANDA APARTMENTS AT KAVALI

DRAWING TITLE:

CCTV LAYOUT

DRWN	CHD	APPD
VIJAY	AA	ALTAF
SCALE	SHEET SIZE	REV.
NTS	A1	R2