

GENERAL NOTES

- 1) R, Y & B INDICATES PHASES
- 2) The number written near the switch board and power point indicates circuit number, for details of circuits refer distribution board chart
- 3) The size of the wire from switch board to light and fan should be 1.5 sq mm
- 4) For the secondary power point the circuit wire shall be looped from first power point by 2*2.5 sq mm
- 5) PVC junction box size as per conduct size
- 6) Light and power circuit should be drawn in separate conduit
- 7) The opening inside electricals, lv & fire shaft should be sealed at each floor
- 8) No two dissimilar phase circuit / wire shall run together through same conduit
- 9) The position mentioned in the legend is bottom of the switch board
- 10) The conduit using for wiring shall be as follows
 - a) PVC -heavy duty (2mm thick) : in R.C.C SLAB
 - b) PVC -medium duty (1.5mm thick) : in brick wall
 - c) The minimum conduit size in RCC Slab shall be :25mm dia
- 11) EV Churcing wire 2.5sq mm and earthen wire 2.5sqmm 25Ømm pvc conduit
- 12) 6 AMP socket shall be connected to the lighting ckt of that area

LEGEND

SYMBOL	SB MODELS	DESCRIPTION
		6A SOCKET CONNECTED TO RAW POWER
		6/16A SOCKET CONNECTED TO UPS POWER
		16A SOCKET CONNECTED TO UPS POWER
		6A TWO SOCKET CONNECTED TO RAW POWER
		LIGHTING POINT @1350mm LVL ON THE WALL FOR TRAIL RM. FOR COFFEE LIGHTING
		RJ-45 DATA OUTLET
		RJ-11 TELEPHONE OUTLET
		6A SOCKET CONNECTED TO RAW POWER
		INDICATES ONE WAY 6A SP SWITCH CONTROL FOR LIGHTS 1350MM LVL
		CELLING MOUNTING FAN
		RAW POWER CIRCUIT MAIN - 2x4.0 + 1x2.5sqmm FRLS wires in 20mmØ conduit
		LIGHTING CIRCUIT R,Y,B 2X4.0+1X1.5 SQ MM WIRES 25 MM Ø CONDUIT
		WALL MOUNTING EXHAUST FAN
		INTEGRATED PANEL-1 INCLUDES 3 GANG OF 5/13A SOCKET WITH 20 A SWITCH, DATA & TEL SOCK.
		DISTRIBUTION BOARD
		EXTRA LOW VOLTAGE DB
17		SWITCH BOARD
		WALL MOUNTED LIGHT
		LOW WALL LIGHT
		CELLING MOUNTED LIGHT
	MB	METER BOARD
		BELL
		BELL PUSH POINT
		20A SOCKET CONNECTED TO RAW POWER
		CHANDELIER / HANGING LIGHT
		LED FLOOR MOUNTED LIGHT
		FURNITURE MOUNTED SOCKET
		ONE WAY PVC JUNCTION BOX
		TWO WAY PVC JUNCTION BOX
		THREE WAY PVC JUNCTION BOX
		FOUR WAY PVC JUNCTION BOX
		TWO WAY PVC JUNCTION BOX
		CONDUIT DROP
		PVC CONDUIT VERTICAL DROP
		INVERTER 25MM CONDUIT

GOOD FOR CONSTRUCTION

Issued by: _____

Issued Date: 03 OCT 2024

COPYRIGHT POLICY

A-SQUARE MEP Consultants (hereafter referred to as "A-SQUARE") retains all copyright and other proprietary rights to the drawings created by A-SQUARE. All drawings created by A-SQUARE are protected by Indian and international copyright laws. Any unauthorized reproduction, distribution, or modification of A-SQUARE's drawings is strictly prohibited. A-SQUARE reserves the right to take legal action against any unauthorized use of its drawings. A-SQUARE grants clients a limited, non-exclusive, non-transferable license to use the drawings for the specific project or purpose for which they were created. Clients may not use the drawings for any other purpose without the express written consent of A-SQUARE. Clients may not modify, reproduce, distribute, transmit, display, perform, publish, license, create derivative works from, transfer, or sell any of A-SQUARE's drawings without the prior written consent of A-SQUARE. Clients may not use any of A-SQUARE's drawings as a basis for the design or construction of any other project without the express written consent of A-SQUARE. Clients may not disclose any of A-SQUARE's drawings to any third party without the prior written consent of A-SQUARE. kindly visit our web-site, to know more.

REVISION CHART

	REVISION DATE	REV. NO.
1	03 AUG 2024	R0
2	19 AUG 2024	R1
3	07 SEP 2024	R2
4	10 OCT 2024	R3

ENGINEERING CONSULTANTS:



G-31, CEDAR BUILDING, BRIGADE ORCHARDS, SPINAL ROAD, DEVANAHALLI, BANGALORE-562110
 Email: Support@a-square.group
 Contact No: +91 9845208299
 www.a-square.group

ARCHITECT NAME

INNOBUILD LANDHOLDINGS

PROJECT NAME:

ALAKANANDA APARTMENTA -AT KAVALI

DRAWING TITLE:

ELECTRICAL SPECIFICATIONS

DRWN	CHD	APPD
M.F	ABDUL	ALTAF
SCALE	SHEET SIZE	REV.
NTS	A1	R3

GOOD FOR CONSTRUCTION

Issued by: _____

Issued Date: 10 OCT 2024

COPYRIGHT POLICY

A-SQUARE MEP Consultants (hereafter referred to as "A-SQUARE") retains all copyright and other proprietary rights to the drawings created by A-SQUARE. All drawings created by A-SQUARE are protected by Indian and international copyright laws. Any unauthorized reproduction, distribution, or modification of A-SQUARE's drawings is strictly prohibited. A-SQUARE reserves the right to take legal action against any unauthorized use of its drawings. A-SQUARE grants clients a limited, non-exclusive, non-transferable license to use the drawings for the specific project or purpose for which they were created. Clients may not use the drawings for any other purpose without the express written consent of A-SQUARE. Clients may not modify, reproduce, distribute, transmit, display, perform, publish, license, create derivative works from, transfer, or sell any of A-SQUARE's drawings without the prior written consent of A-SQUARE. Clients may not use any of A-SQUARE's drawings as a basis for the design or construction of any other project without the express written consent of A-SQUARE. Clients may not disclose any of A-SQUARE's drawings to any third party without the prior written consent of A-SQUARE. kindly visit our web-site, to know more.

REVISION CHART

	REVISION DATE	REV. NO.
1	03 AUG 2024	R0
2	19 AUG 2024	R1
3	07 SEP 2024	R2
4	10 OCT 2024	R3

ENGINEERING CONSULTANTS:



G-31, CEDAR BUILDING, BRIGADE ORCHARDS, SPINAL ROAD, DEVANAHALLI, BANGALORE-562110
Email: Support@a-square.group
Contact No: +91 9845208299
www.a-square.group

ARCHITECT NAME

INNOBUILD LANDHOLDINGS

PROJECT NAME:


ALAKANANDA APARTMENTA -AT KAVALI


DRAWING TITLE:

STILT FLOOR CONDUIT


DRWN	CHD	APPD
M.F	ABDUL	ALTAF
SCALE	SHEET SIZE	REV.
NTS	A1	R3

STILT FLOOR CONDUIT

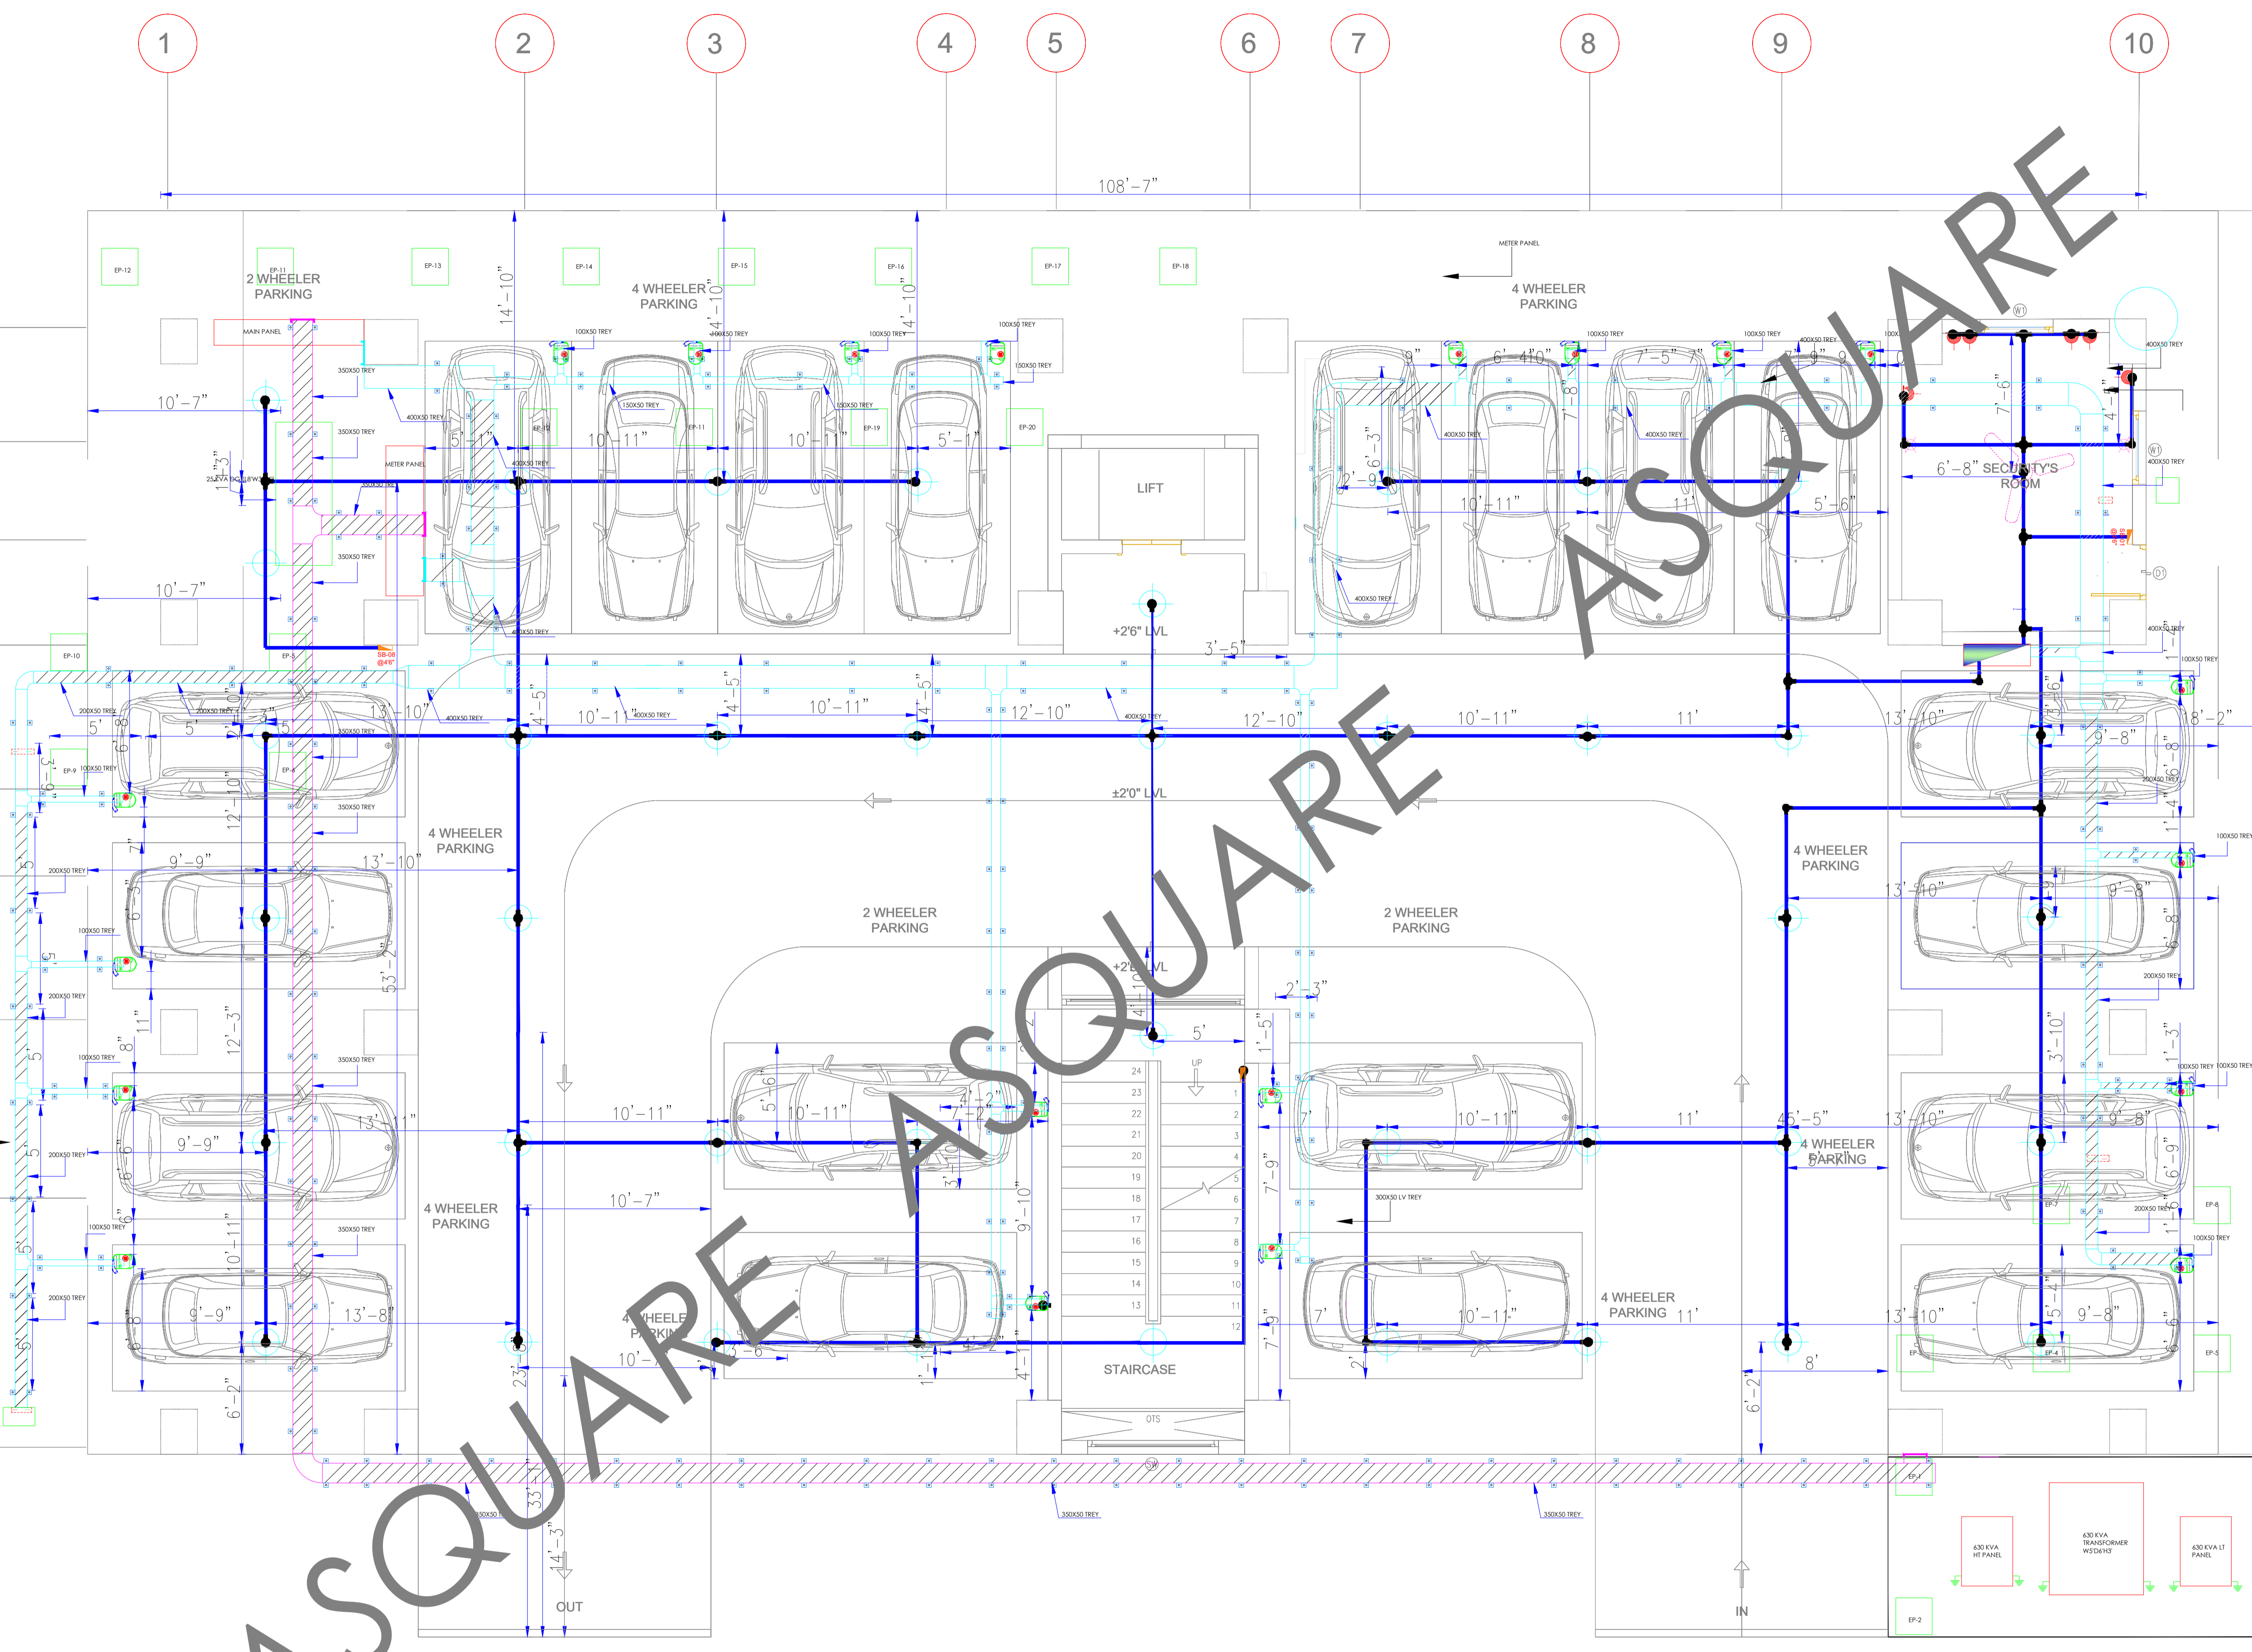


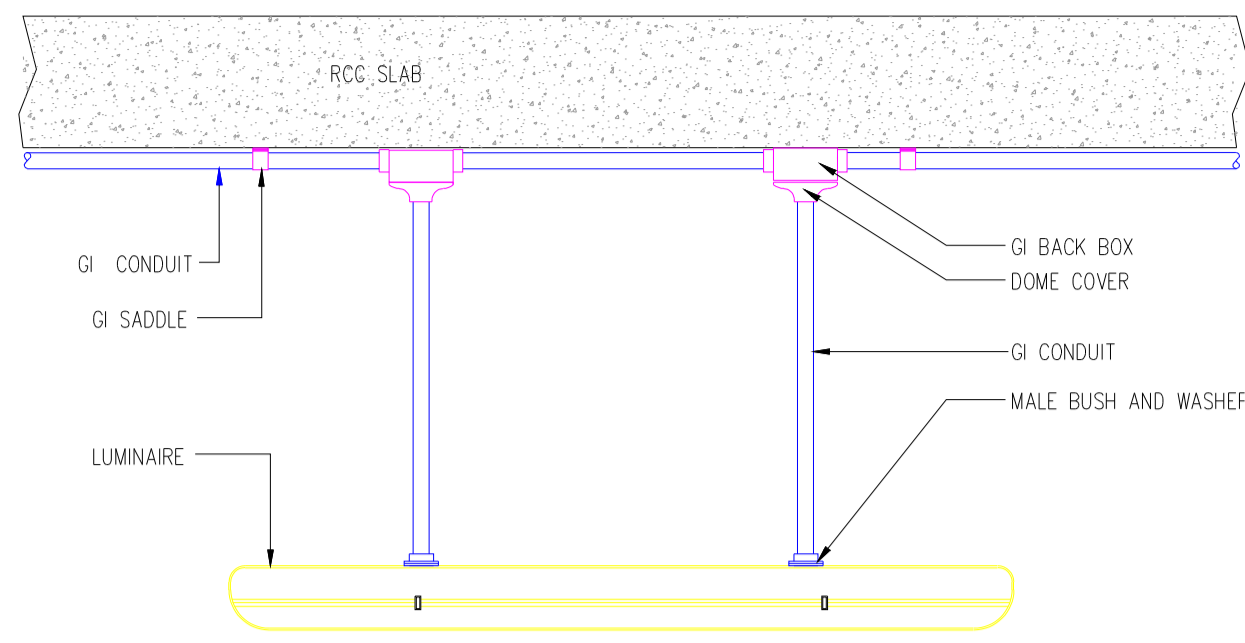


01 TYPICAL INSTALLATION DETAIL FOR SUSPENDED LED LUMINAIRE
SCALE NTS

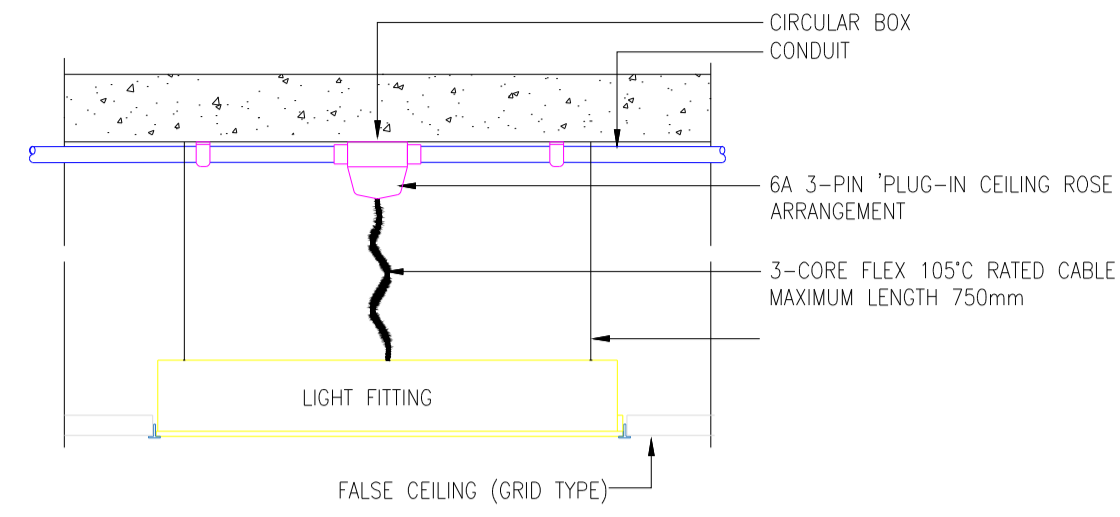


02 TYPICAL INSTALLATION DETAIL FOR RECESSED LED LUMINAIRE
SCALE NTS

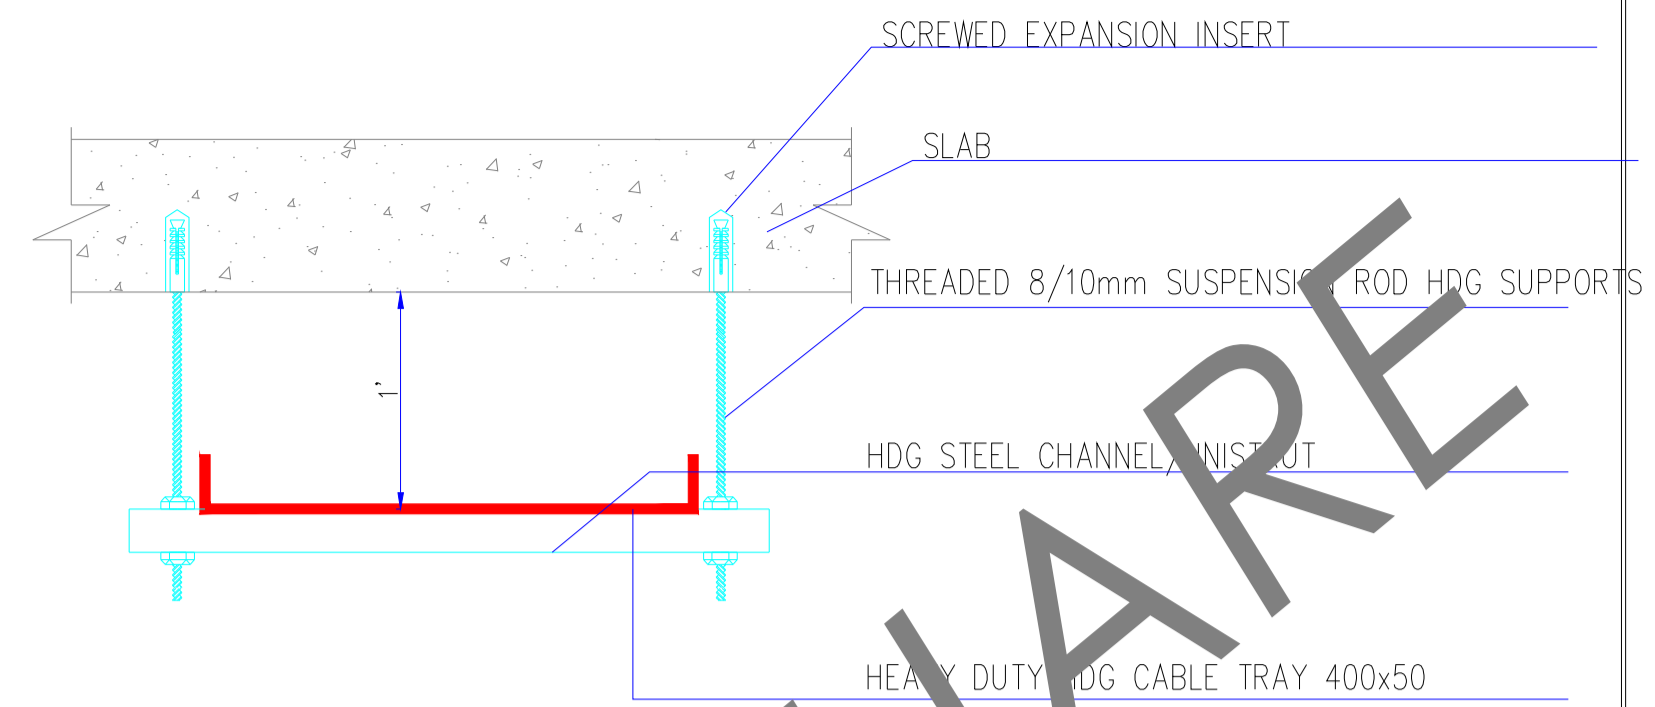


03 CABEL TRAY TYPICAL DETAILS
NTS

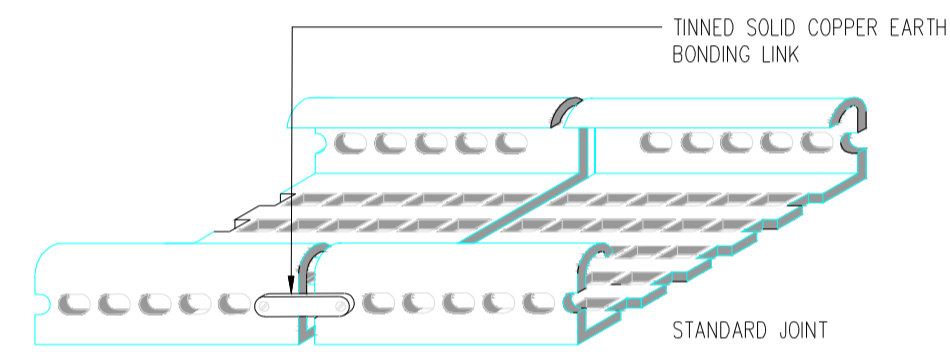


04 CABLE TRAY BONDING
NTS

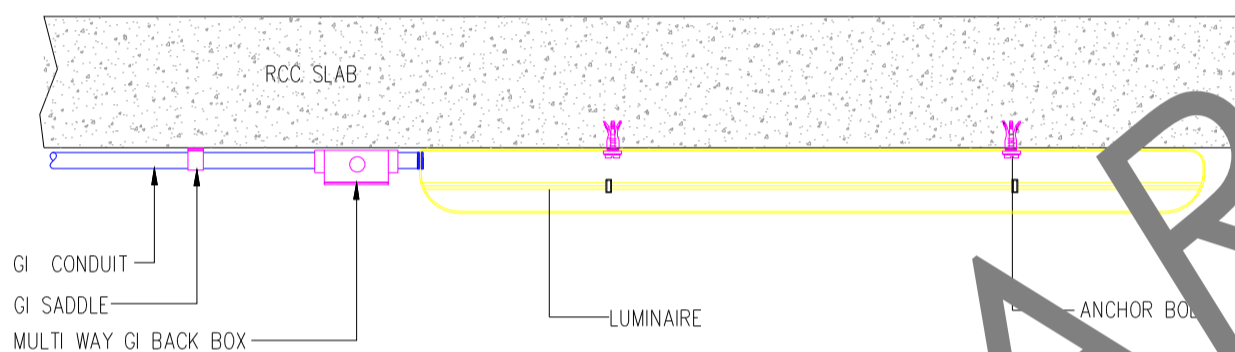


05 TYPICAL INSTALLATION DETAIL FOR SURFACE LED LUMINAIRE
SCALE NTS

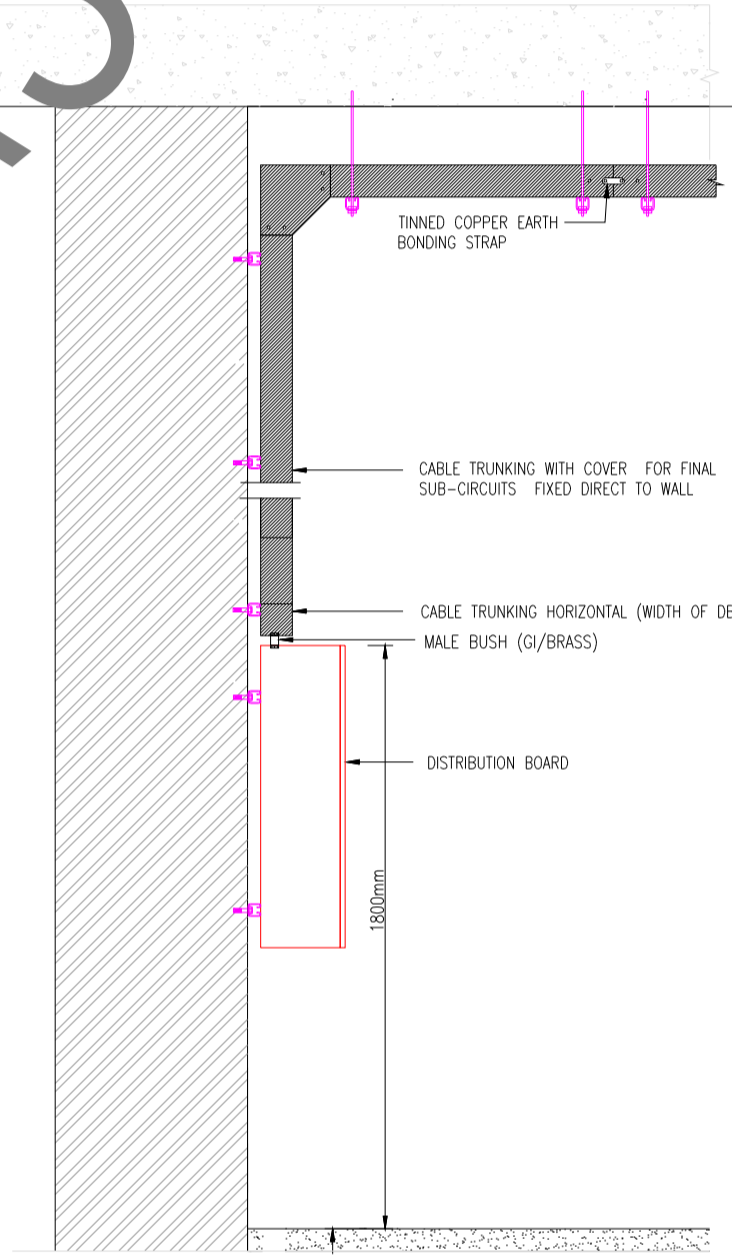


06 SURFACE MOUNTED DISTRIBUTION BOARD
NTS

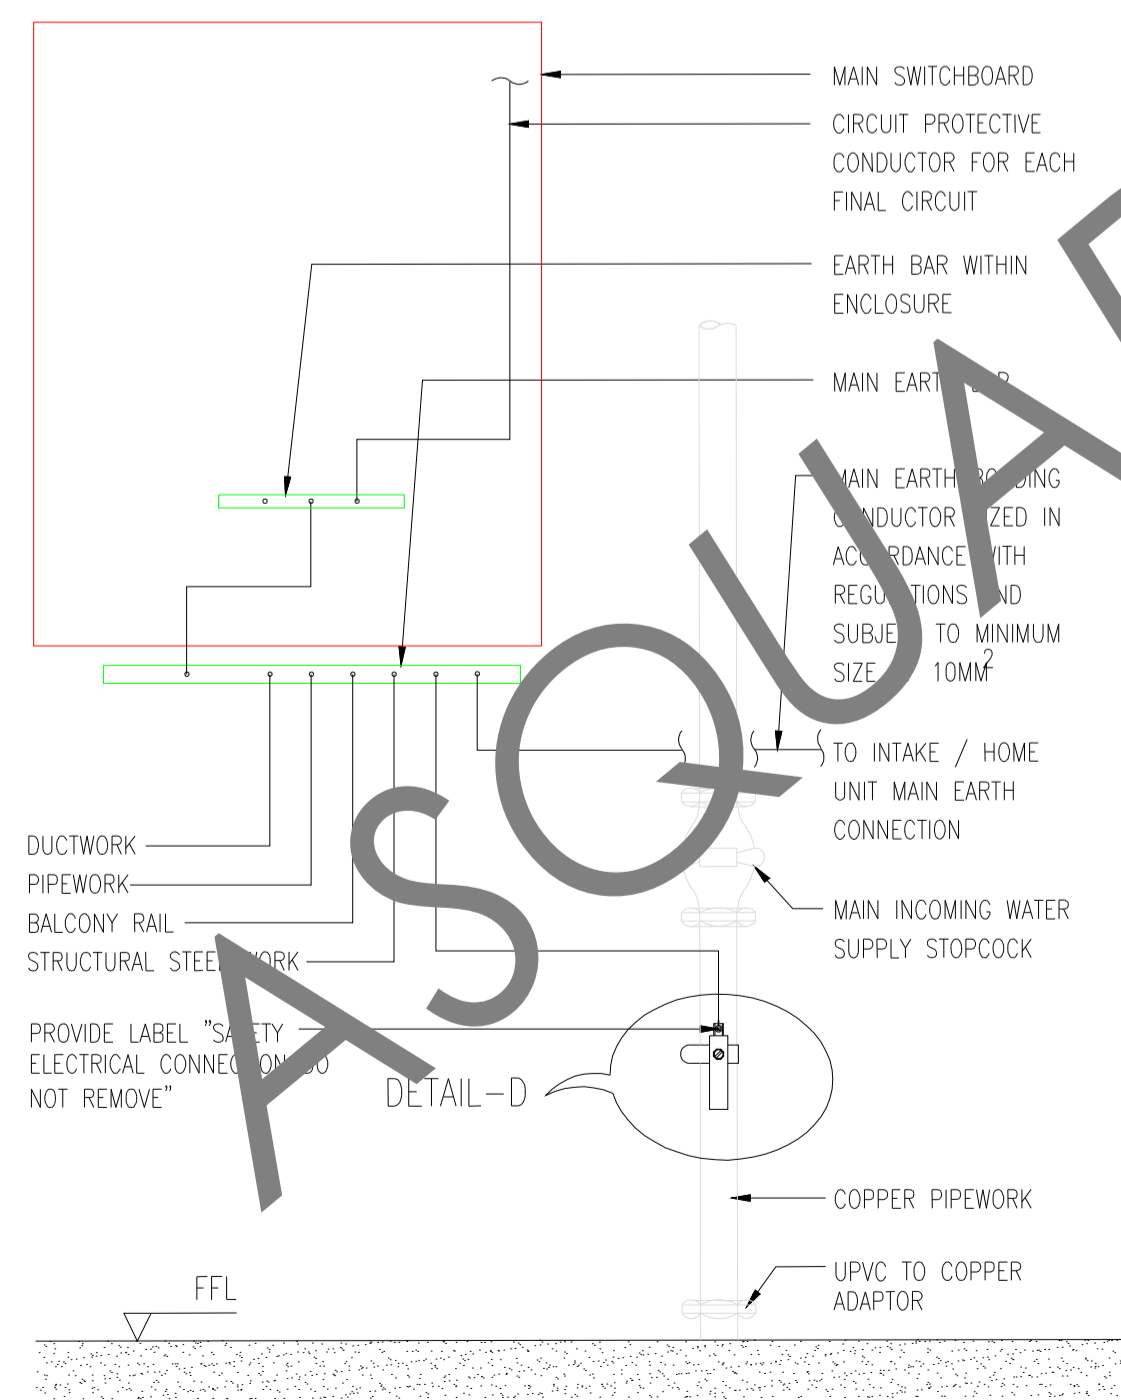

07 TYPICAL EQUIPOTENTIAL BONDING CONNECTIONS
NTS

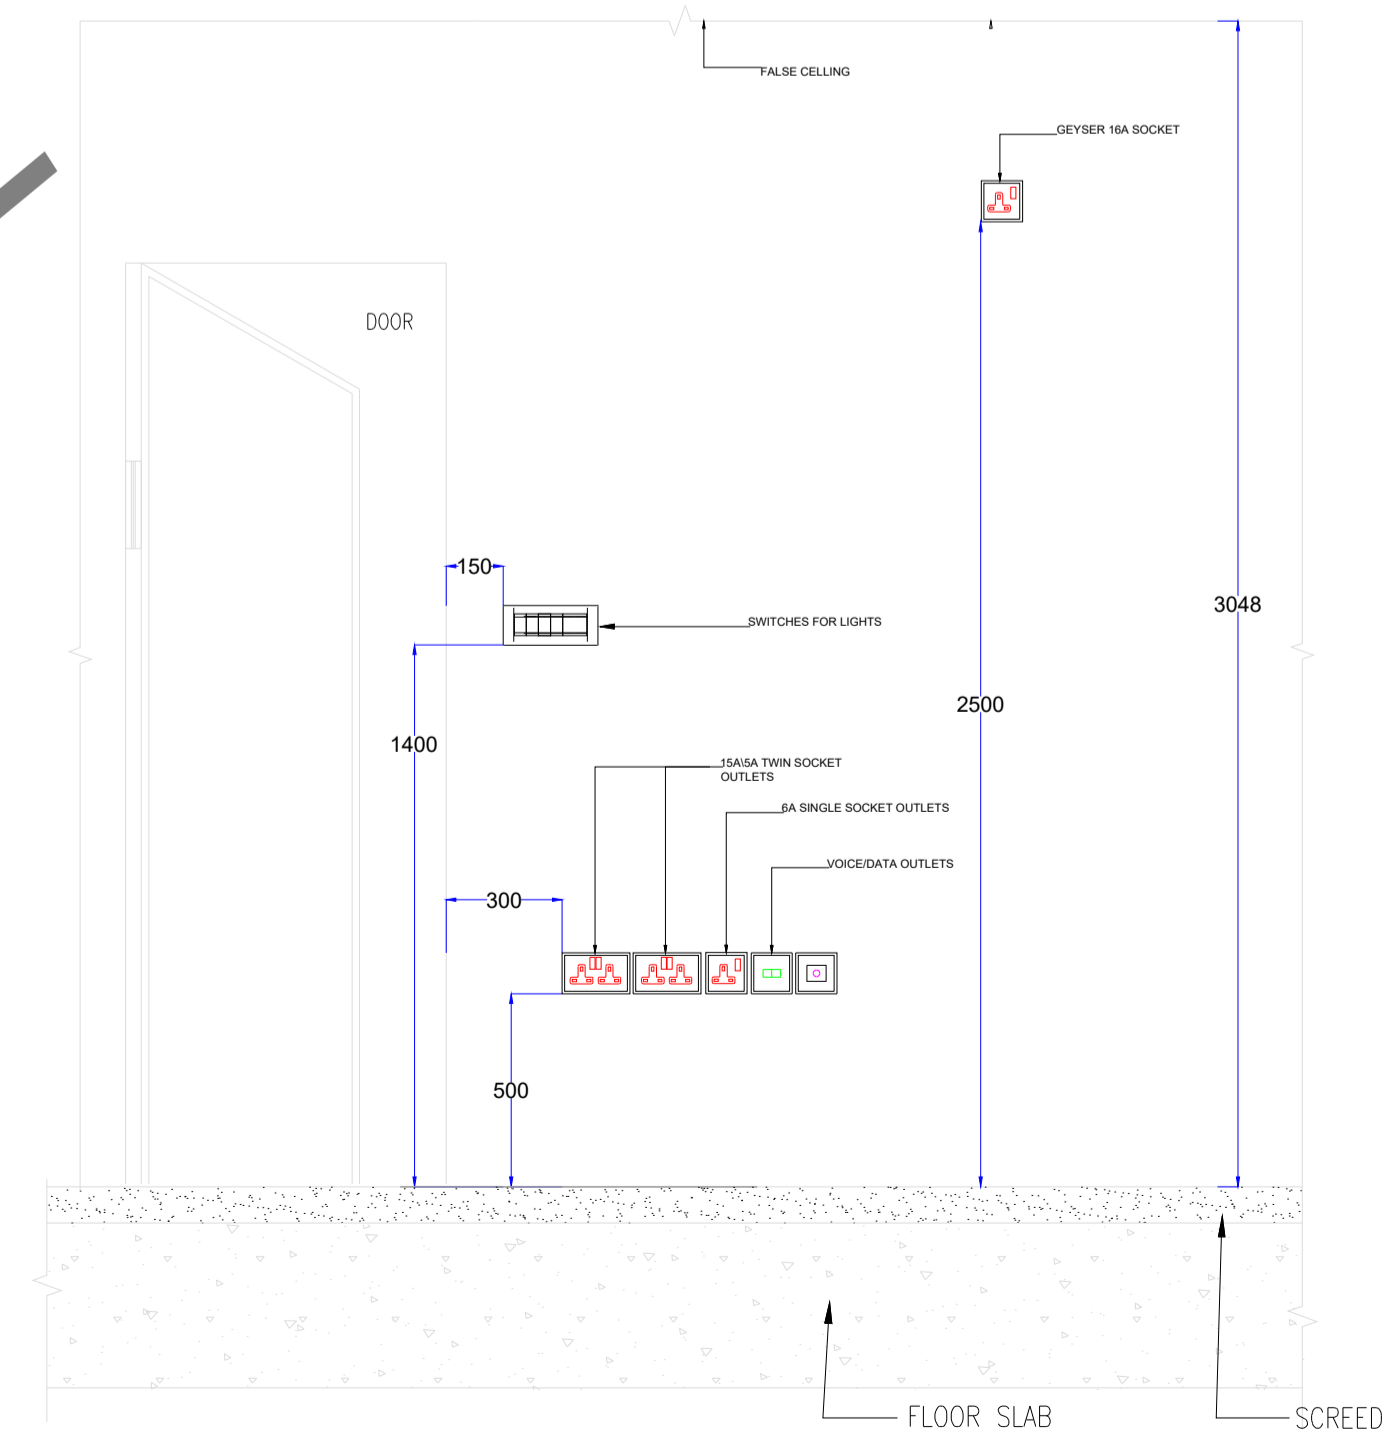

08 SWITCHBOARDS
NTS

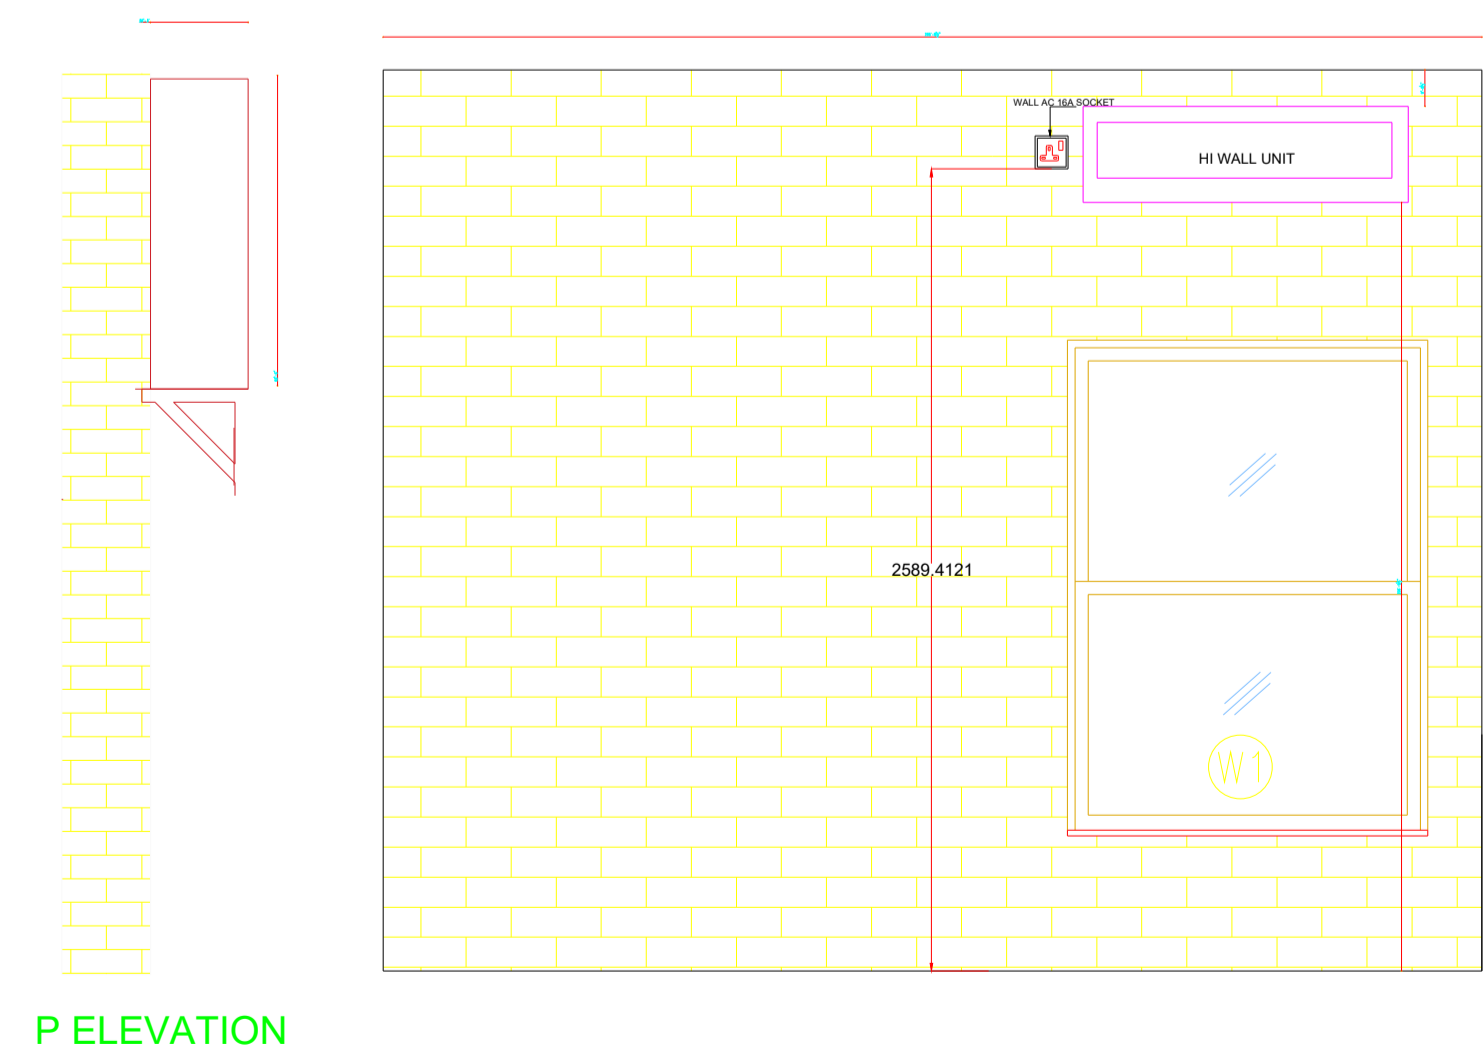

09 WALL AC SOCKET OUTLET
NTS

GOOD FOR CONSTRUCTION

Issued by: _____
Issued Date: 10 OCT 2024

COPYRIGHT POLICY

A-SQUARE MEP Consultants (hereafter referred to as "A-SQUARE") retains all copyright and other proprietary rights to the drawings created by A-SQUARE. All drawings created by A-SQUARE are protected by Indian and international copyright laws. Any unauthorized reproduction, distribution, or modification of A-SQUARE's drawings is strictly prohibited. A-SQUARE reserves the right to take legal action against any unauthorized use of its drawings. A-SQUARE grants clients a limited, non-exclusive, non-transferable license to use the drawings for the specific project or purpose for which they were created. Clients may not use the drawings for any other purpose without the express written consent of A-SQUARE. Clients may not modify, reproduce, distribute, transmit, display, perform, publish, license, create derivative works from, transfer, or sell any of A-SQUARE's drawings without the prior written consent of A-SQUARE. Clients may not use any of A-SQUARE's drawings as a basis for the design or construction of any other project without the express written consent of A-SQUARE. Clients may not disclose any of A-SQUARE's drawings to any third party without the prior written consent of A-SQUARE. kindly visit our web-site, to know more.

REVISION CHART

	REVISION DATE	REV. NO.
1	03 AUG 2024	R0
2	19 AUG 2024	R1
3	07 SEP 2024	R2
4	10 OCT 2024	R3

ENGINEERING CONSULTANTS:



G-31, CEDAR BUILDING, BRIGADE ORCHARDS, SPINAL ROAD, DEVANAHALLI, BANGALORE-562110
Email: Support@a-square.group
Contact No: +91 9845208299
www.a-square.group

ARCHITECT NAME

INNOBUILD LANDHOLDINGS

PROJECT NAME:

ALAKANANDA APARTMENTA -AT KAVALI

DRAWING TITLE:

ELECTRICAL SECTIONS

DRWN	CHD	APPD
M.F	ABDUL	ALTAF
SCALE	SHEET SIZE	REV.
NTS	A1	R3

GOOD FOR CONSTRUCTION

Issued by: _____

Issued Date: 03 OCT 2024

COPYRIGHT POLICY

A-SQUARE MEP Consultants (hereafter referred to as "A-SQUARE") retains all copyright and other proprietary rights to the drawings created by A-SQUARE. All drawings created by A-SQUARE are protected by Indian and international copyright laws. Any unauthorized reproduction, distribution, or modification of A-SQUARE's drawings is strictly prohibited. A-SQUARE reserves the right to take legal action against any unauthorized use of its drawings. A-SQUARE grants clients a limited, non-exclusive, non-transferable license to use the drawings for the specific project or purpose for which they were created. Clients may not use the drawings for any other purpose without the express written consent of A-SQUARE. Clients may not modify, reproduce, distribute, transmit, display, perform, publish, license, create derivative works from, transfer, or sell any of A-SQUARE's drawings without the prior written consent of A-SQUARE. Clients may not use any of A-SQUARE's drawings as a basis for the design or construction of any other project without the express written consent of A-SQUARE. Clients may not disclose any of A-SQUARE's drawings to any third party without the prior written consent of A-SQUARE. kindly visit our web-site, to know more.

REVISION CHART

	REVISION DATE	REV. NO.
1	03 AUG 2024	R0
2	19 AUG 2024	R1
3	07 SEP 2024	R2
4	10 OCT 2024	R3

ENGINEERING CONSULTANTS:



G-31, CEDAR BUILDING, BRIGADE ORCHARDS, SPINAL ROAD, DEVANAHALLI, BANGALORE-562110
 Email: Support@a-square.group
 Contact No: +91 9845208299
 www.a-square.group

ARCHITECT NAME

INNOBUILD LANDHOLDINGS

PROJECT NAME:

ALAKANANDA APARTMENTA -AT KAVALI

DRAWING TITLE:


STILT FLOOR LOOPING

DRWN CHD APPD

M.F ABDUL ALTAF

SCALE SHEET SIZE REV.

NTS A1 R3

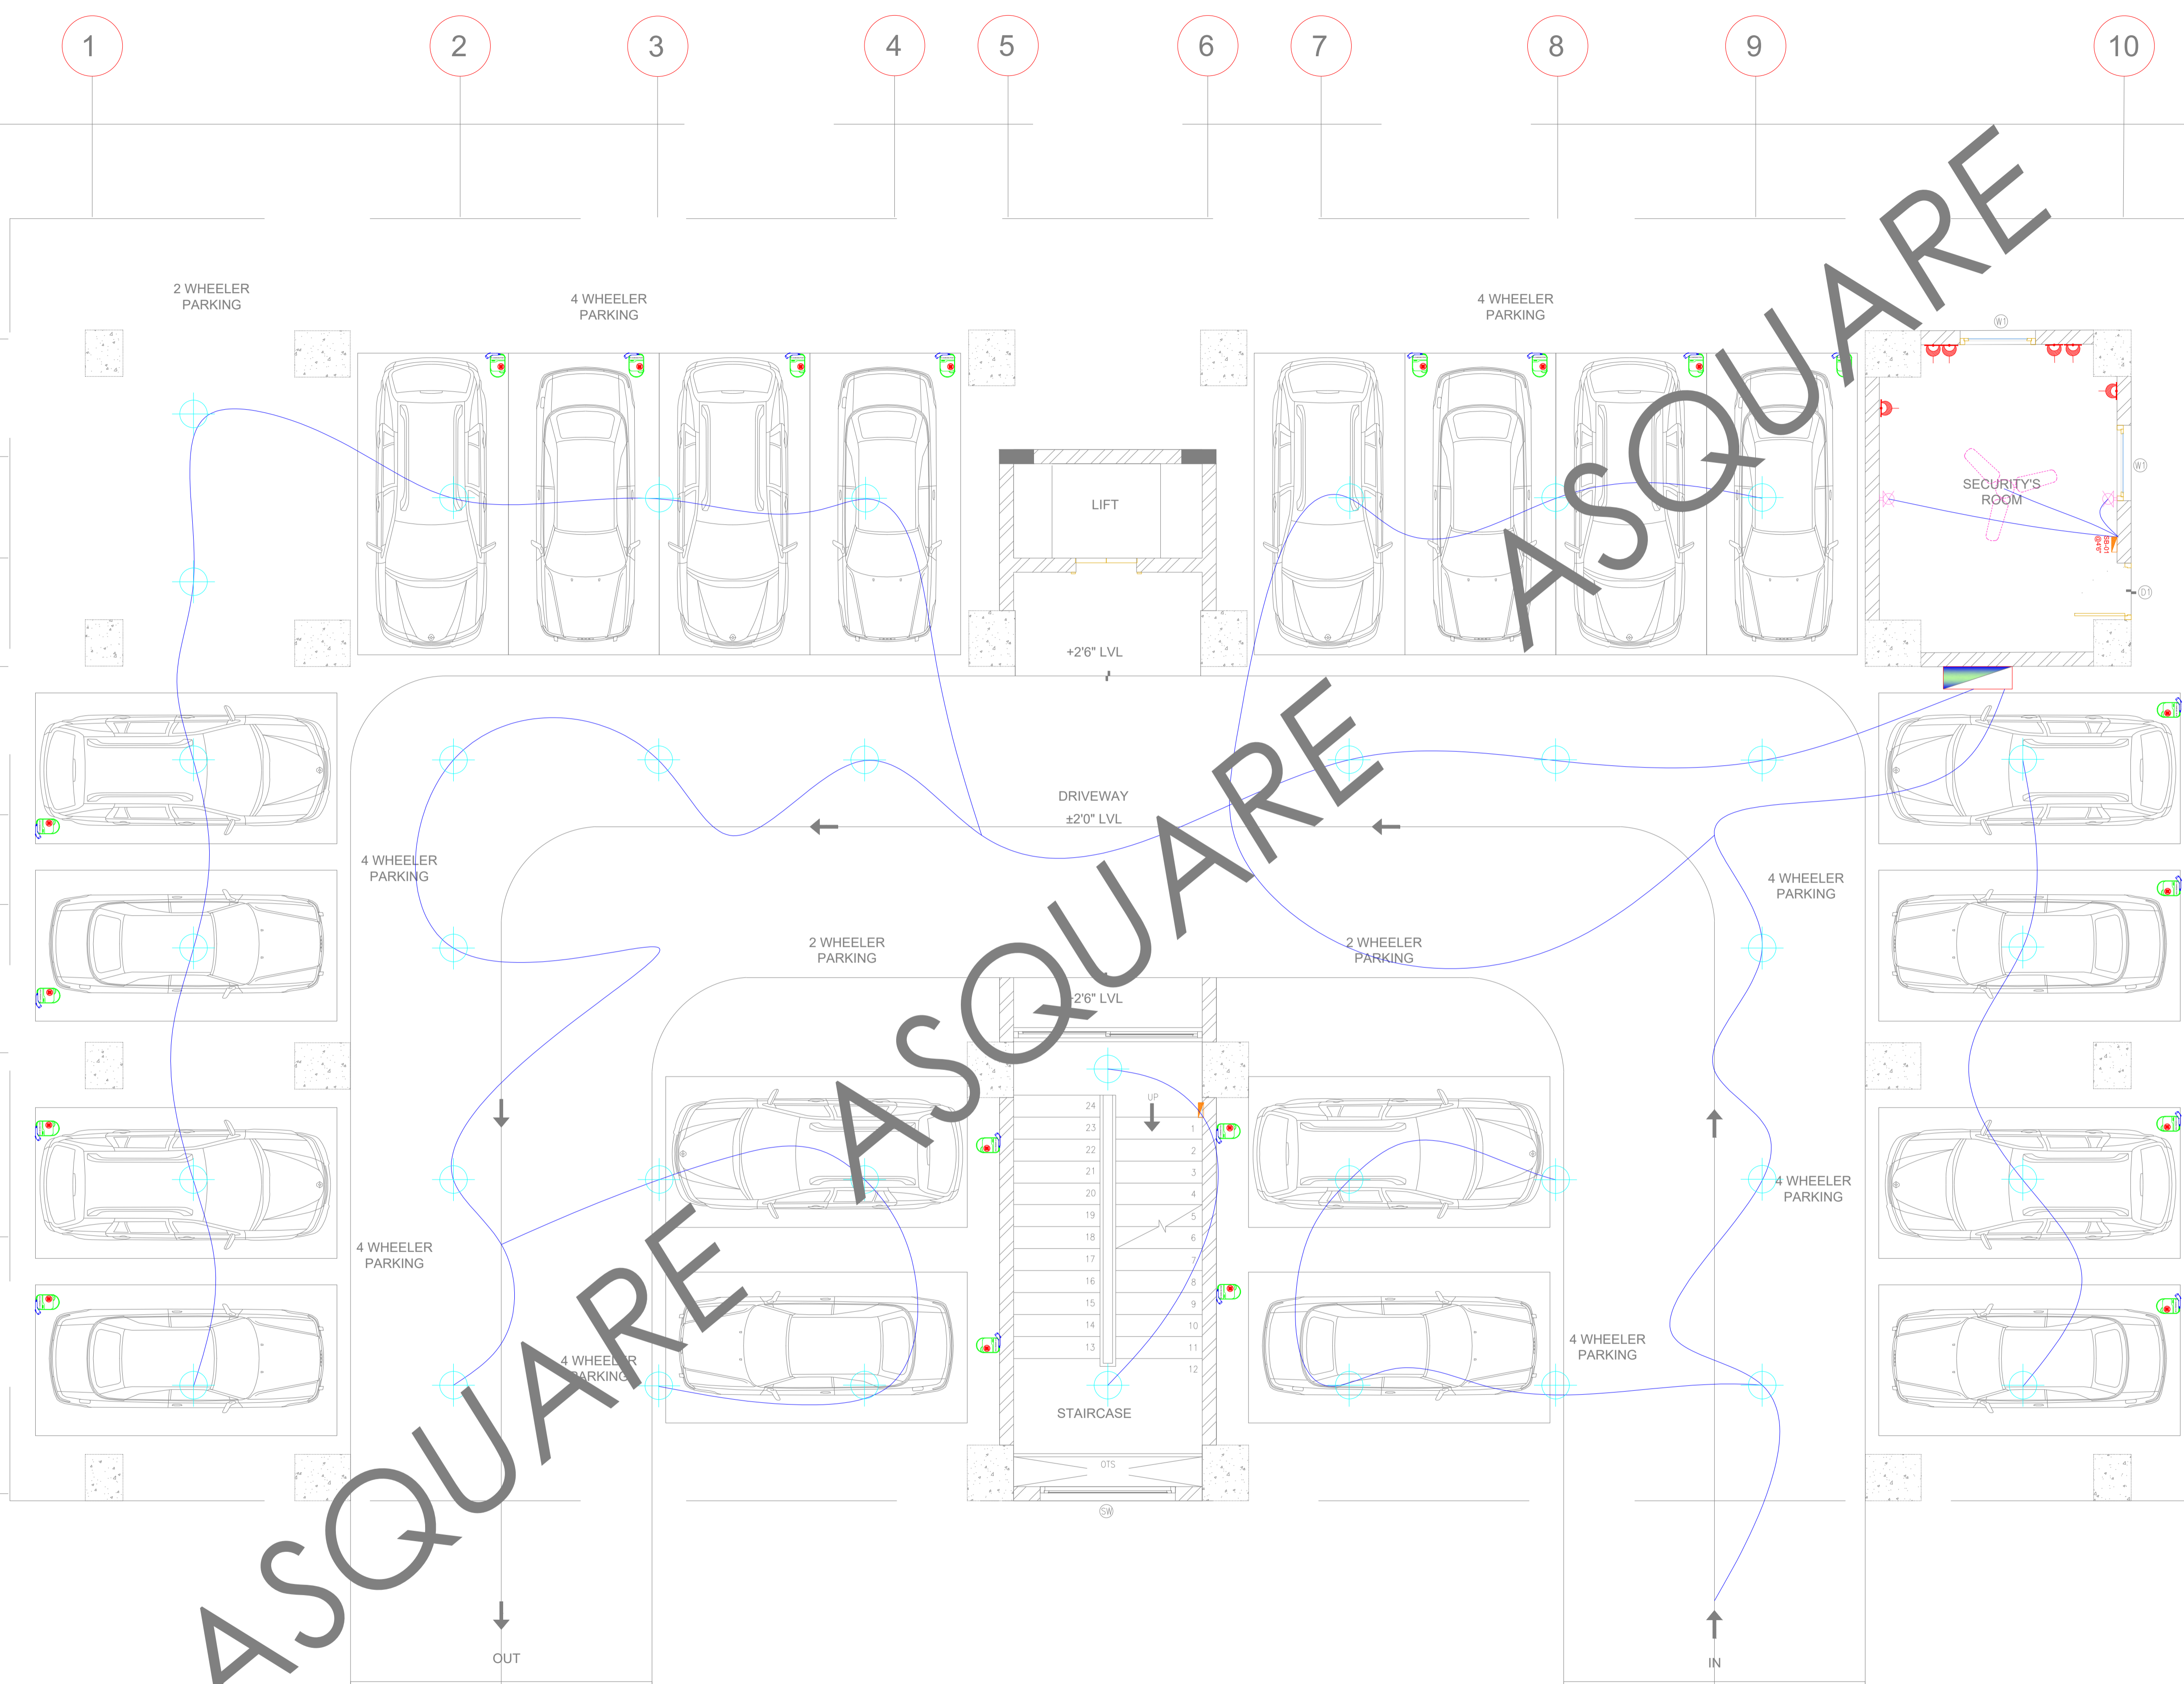

COPYRIGHT POLICY

A-SQUARE MEP Consultants (hereafter referred to as "A-SQUARE" retains all copyright and other proprietary rights to the drawings created by A-SQUARE. All drawings created by A-SQUARE are protected by Indian and international copyright laws. Any unauthorized reproduction, distribution, or modification of A-SQUARE's drawings is strictly prohibited. A-SQUARE reserves the right to take legal action against any unauthorized use of its drawings. A-SQUARE grants clients a limited, non-exclusive, non-transferable license to use the drawings for the specific project or purpose for which they were created. Clients may not use the drawings for any other purpose without the express written consent of A-SQUARE. Clients may not modify, reproduce, distribute, transmit, display, perform, publish, license, create derivative works from, transfer, or sell any of A-SQUARE's drawings without the prior written consent of A-SQUARE. Clients may not use any of A-SQUARE's drawings as a basis for the project or construction of any other project without the express written consent of A-SQUARE. Clients may not disclose any of A-SQUARE's drawings to any third party without the prior written consent of A-SQUARE. kindly visit our web-site, to know more.

REVISION CHART

	REVISION DATE	REV. NO.
1	03 AUG 2024	R0
2	19 AUG 2024	R1
3	07 SEP 2024	R2
4	10 OCT 2024	R3

ENGINEERING CONSULTANTS:



G-31, CEDAR BUILDING, BRIGADE ORCHARDS, SPINAL ROAD, DEVANAHALLI, BANGALORE-562110
 Email: Support@a-square.group
 Contact No: +91 9845208299
www.a-square.group

ARCHITECT NAME

INNOBUILD LANDHOLDINGS

PROJECT NAME:


ALAKANANDA APARTMENTA -AT KAVALI

DRAWING TITLE:




TYPICAL FLOOR LOOPING

DRWN	CHD	APPD
M.F	ABDUL	ALTAF
SCALE	SHEET SIZE	REV.
NTS	A1	R3

TYPICAL FLOOR LOOPING

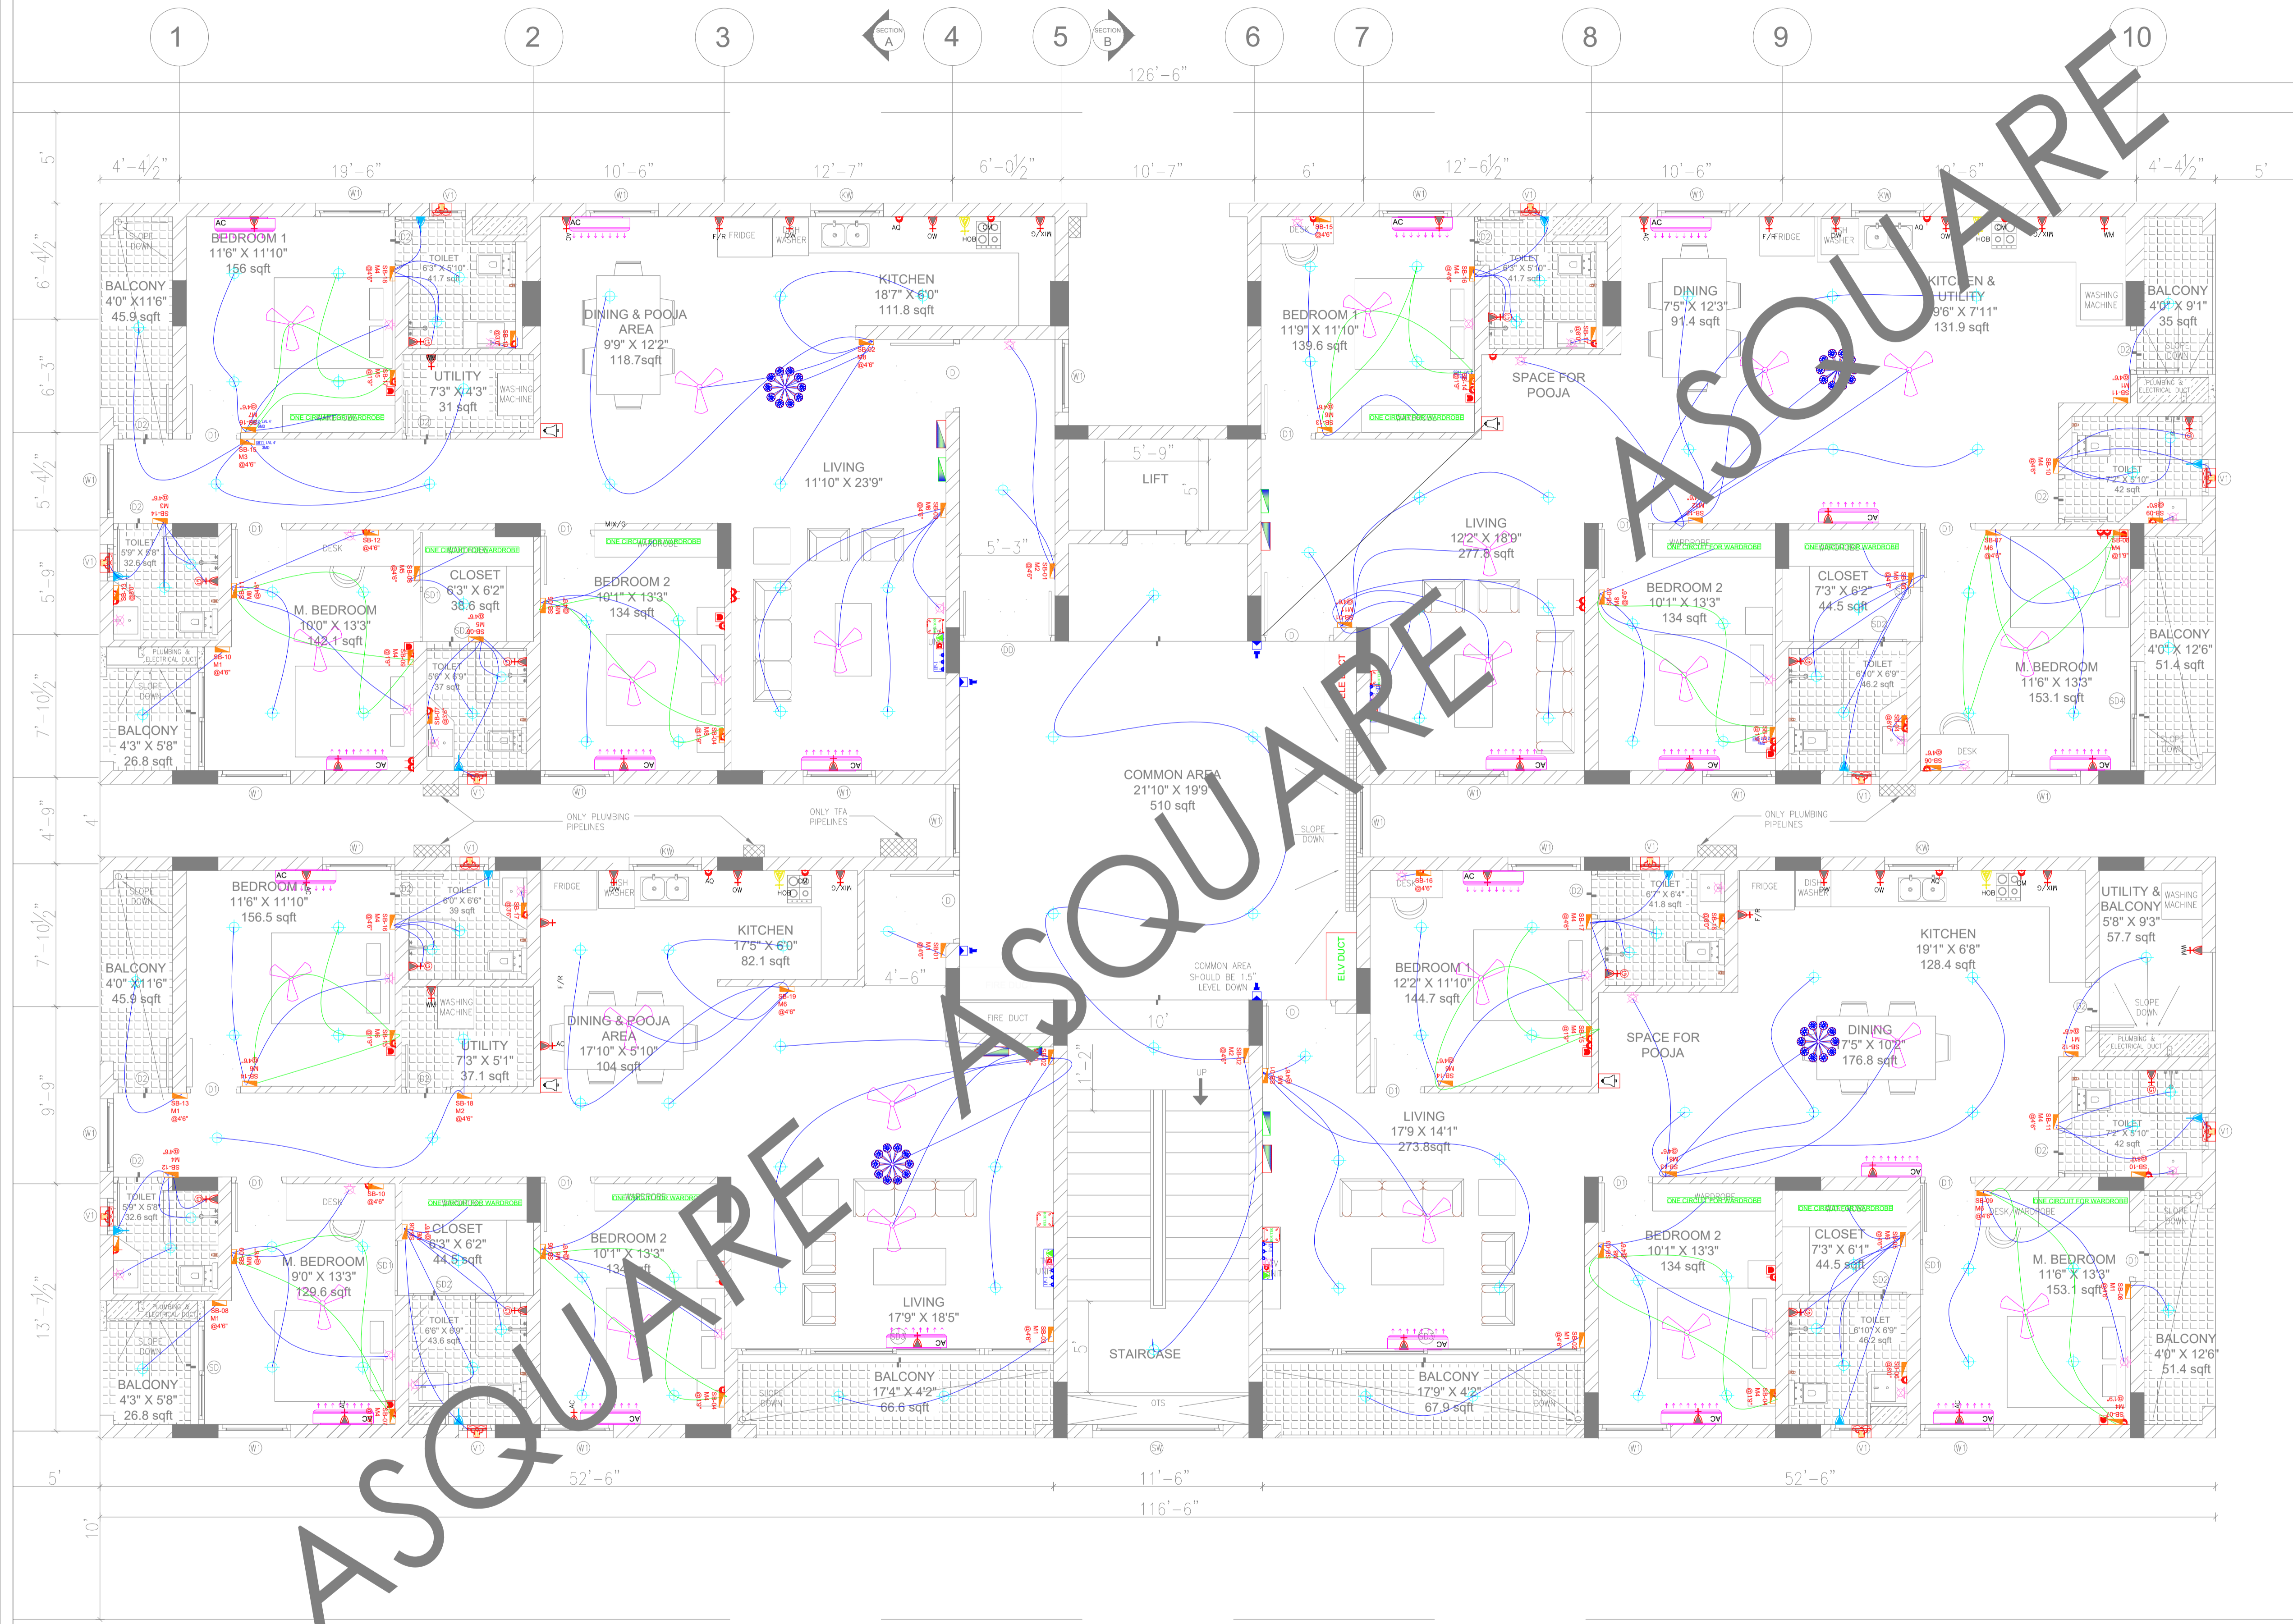

POWER SLD

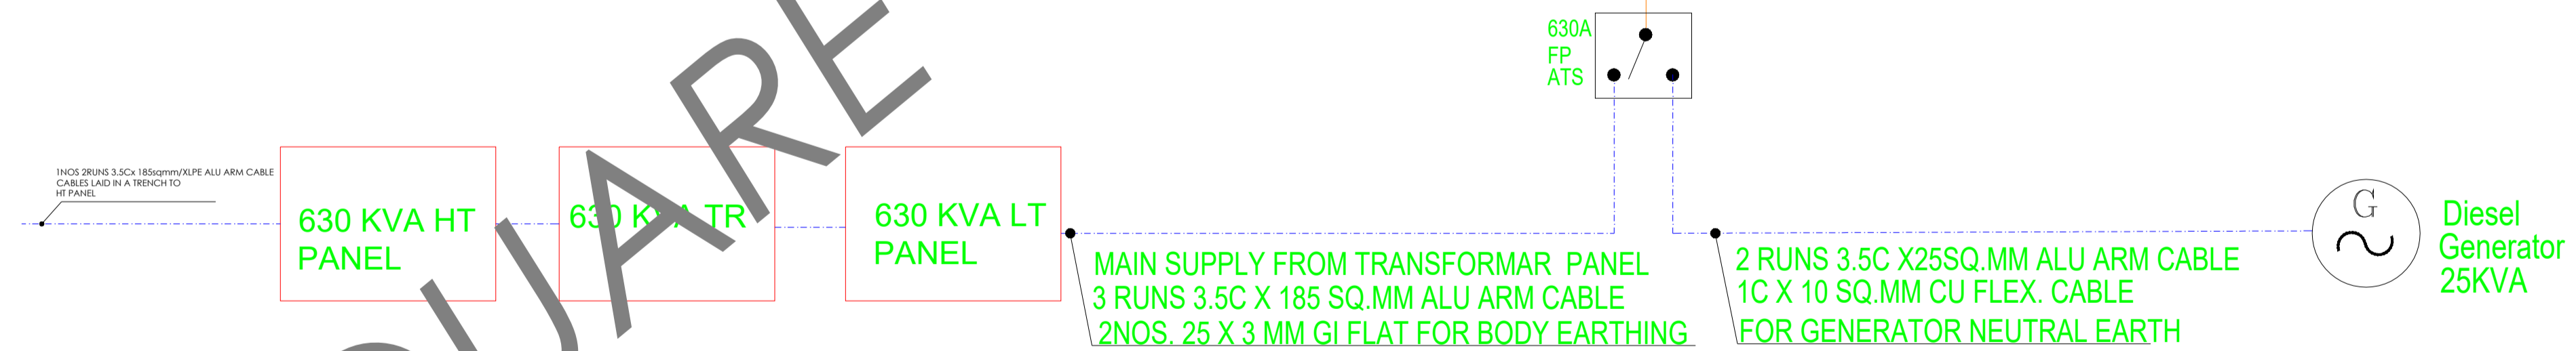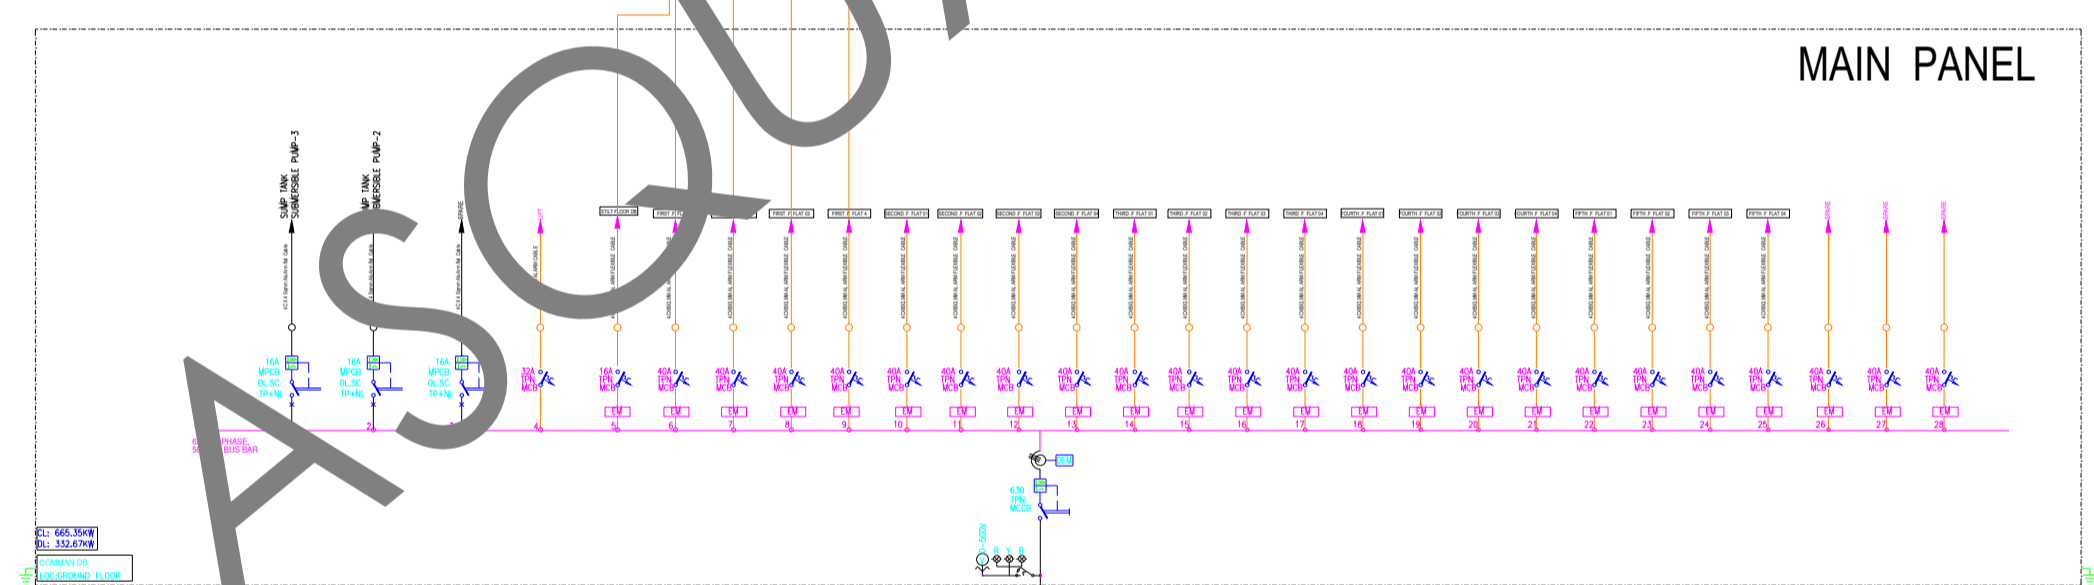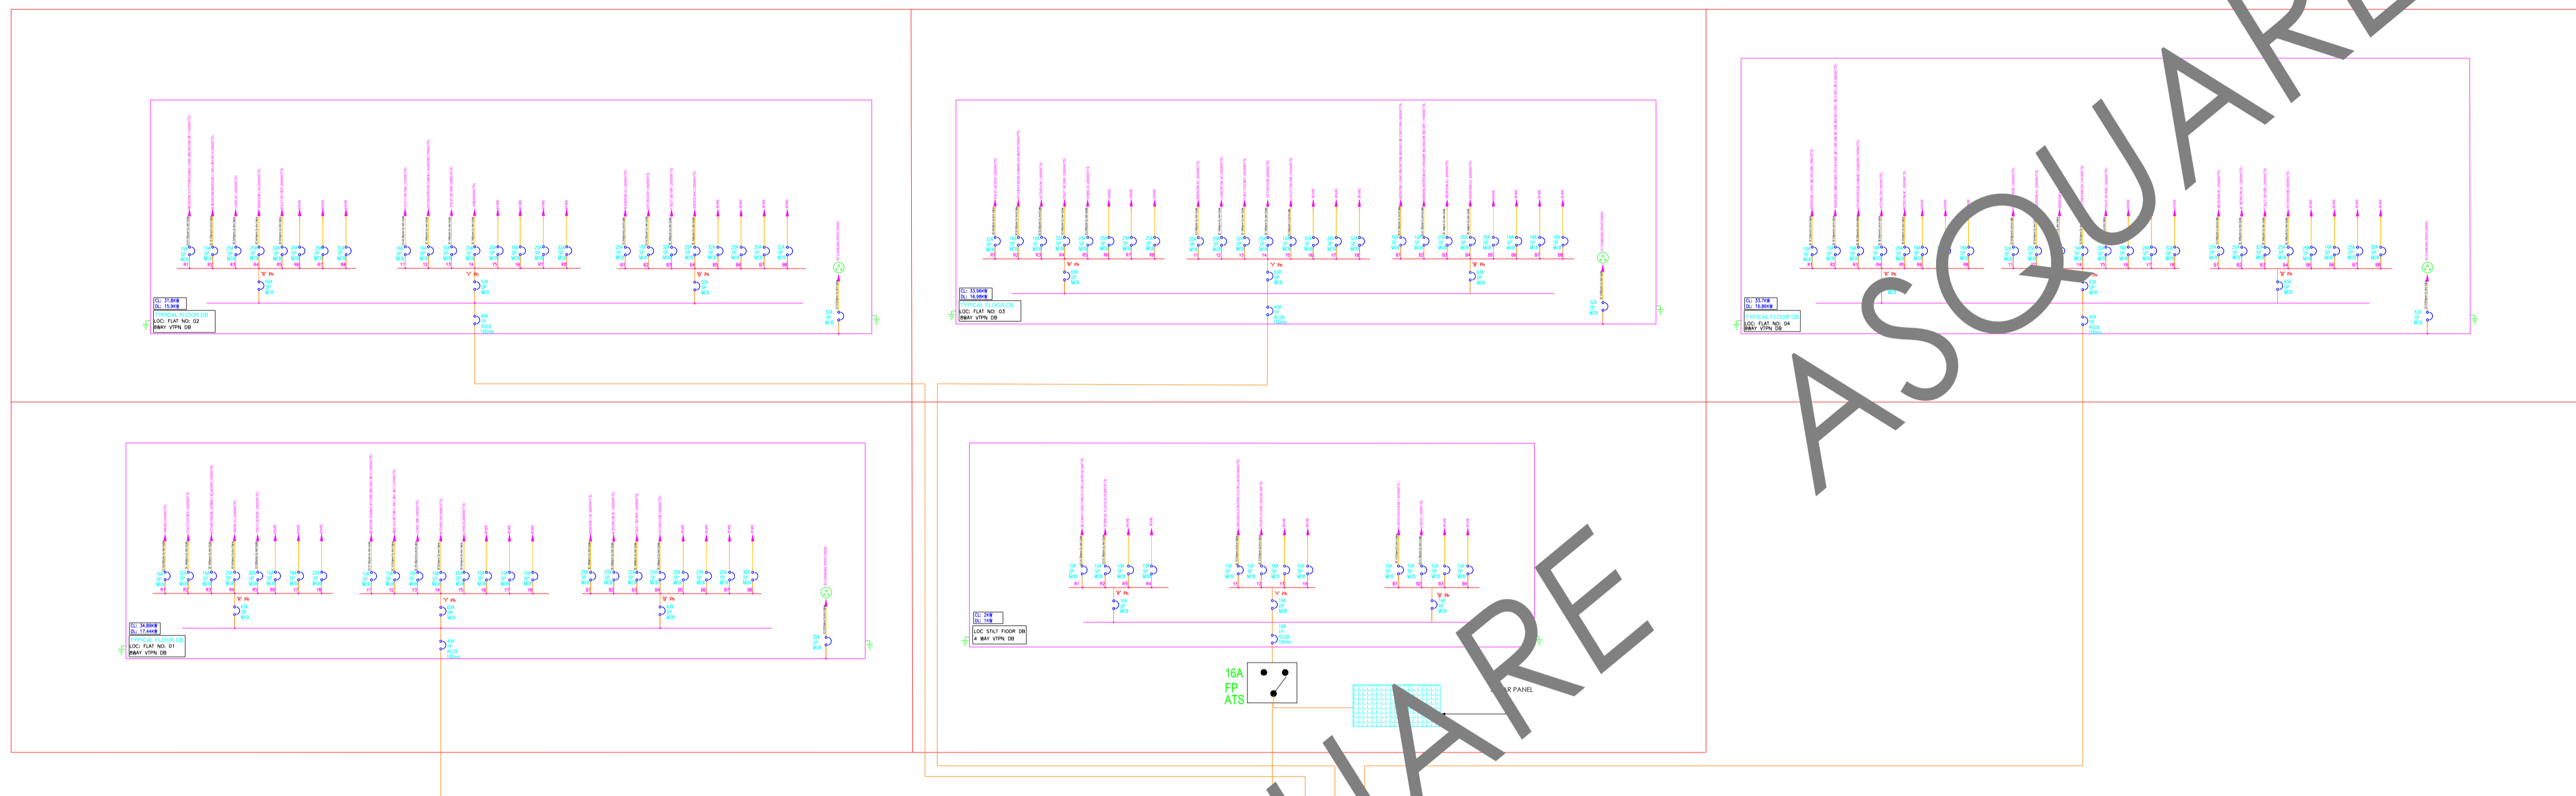

NOTE
DG IS SELECTED AS PER THE REQUIRED LIGHTING LOAD

GOOD FOR CONSTRUCTION

Issued by: _____

Issued Date: 03 OCT 2024

COPYRIGHT POLICY

A-SQUARE MEP Consultants (hereafter referred to as "A-SQUARE" retains all copyright and other proprietary rights to the drawings created by A-SQUARE. All drawings created by A-SQUARE are protected by Indian and international copyright laws. Any unauthorized reproduction, distribution, or modification of A-SQUARE's drawings is strictly prohibited. A-SQUARE reserves the right to take legal action against any unauthorized use of its drawings. A-SQUARE grants clients a limited, non-exclusive, non-transferable license to use the drawings for the specific project or purpose for which they were created. Clients may not use the drawings for any other purpose without the express written consent of A-SQUARE. Clients may not modify, reproduce, distribute, transmit, display, perform, publish, license, create derivative works from, transfer, or sell any of A-SQUARE's drawings without the prior written consent of A-SQUARE. Clients may not use any of A-SQUARE's drawings as a basis for the design or construction of any other project without the express written consent of A-SQUARE. Clients may not disclose any of A-SQUARE's drawings to any third party without the prior written consent of A-SQUARE. kindly visit our web-site, to know more.

REVISION CHART

	REVISION DATE	REV. NO.
1	03 AUG 2024	R0
2	19 AUG 2024	R1
3	07 SEP 2024	R2
4	10 OCT 2024	R3

ENGINEERING CONSULTANTS:



G-31, CEDAR BUILDING, BRIGADE ORCHARDS, SPINAL ROAD, DEVANAHALLI, BANGALORE-562110
Email: Support@a-square.group
Contact No: +91 9845208299
www.a-square.group

ARCHITECT NAME

INNOBUILD LANDHOLDINGS

PROJECT NAME:

ALAKANANDA APARTMENTA -AT KAVALI

DRAWING TITLE:

POWER SLD

DRWN	CHD	APPD
M.F	ABDUL	ALTAF
SCALE	SHEET SIZE	REV.
NTS	A1	R3

DIESEL GENERATOR SLD

GOOD FOR CONSTRUCTION

Issued by: _____

Issued Date: 10 OCT 2024

COPYRIGHT POLICY

A-SQUARE MEP Consultants (hereafter referred to as "A-SQUARE") retains all copyright and other proprietary rights to the drawings created by A-SQUARE. All drawings created by A-SQUARE are protected by Indian and international copyright laws. Any unauthorized reproduction, distribution, or modification of A-SQUARE's drawings is strictly prohibited. A-SQUARE reserves the right to take legal action against any unauthorized use of its drawings. A-SQUARE grants clients a limited, non-exclusive, non-transferable license to use the drawings for the specific project or purpose for which they were created. Clients may not use the drawings for any other purpose without the express written consent of A-SQUARE. Clients may not modify, reproduce, distribute, transmit, display, perform, publish, license, create derivative works from, transfer, or sell any of A-SQUARE's drawings without the prior written consent of A-SQUARE. Clients may not use any of A-SQUARE's drawings as a basis for the design or construction of any other project without the express written consent of A-SQUARE. Clients may not disclose any of A-SQUARE's drawings to any third party without the prior written consent of A-SQUARE. kindly visit our web-site, to know more.

REVISION CHART

	REVISION DATE	REV. NO.
1	03 AUG 2024	R0
2	19 AUG 2024	R1
3	07 SEP 2024	R2
4	10 OCT 2024	R3

ENGINEERING CONSULTANTS:



G-31, CEDAR BUILDING, BRIGADE ORCHARDS, SPINAL ROAD, DEVANAHALLI, BANGALORE-562110
 Email: Support@a-square.group
 Contact No: +91 9845208299
www.a-square.group

ARCHITECT NAME

INNOBUILD LANDHOLDINGS

PROJECT NAME:

ALAKANANDA APARTMENTA -AT KAVALI

DRAWING TITLE:

DG SLD



DRWN CHD APPD

M.F ABDUL ALTAF

SCALE SHEET SIZE REV.

NTS A1 R3

TYPICAL FLOOR DB

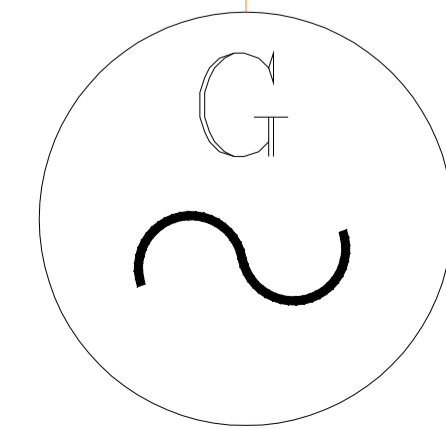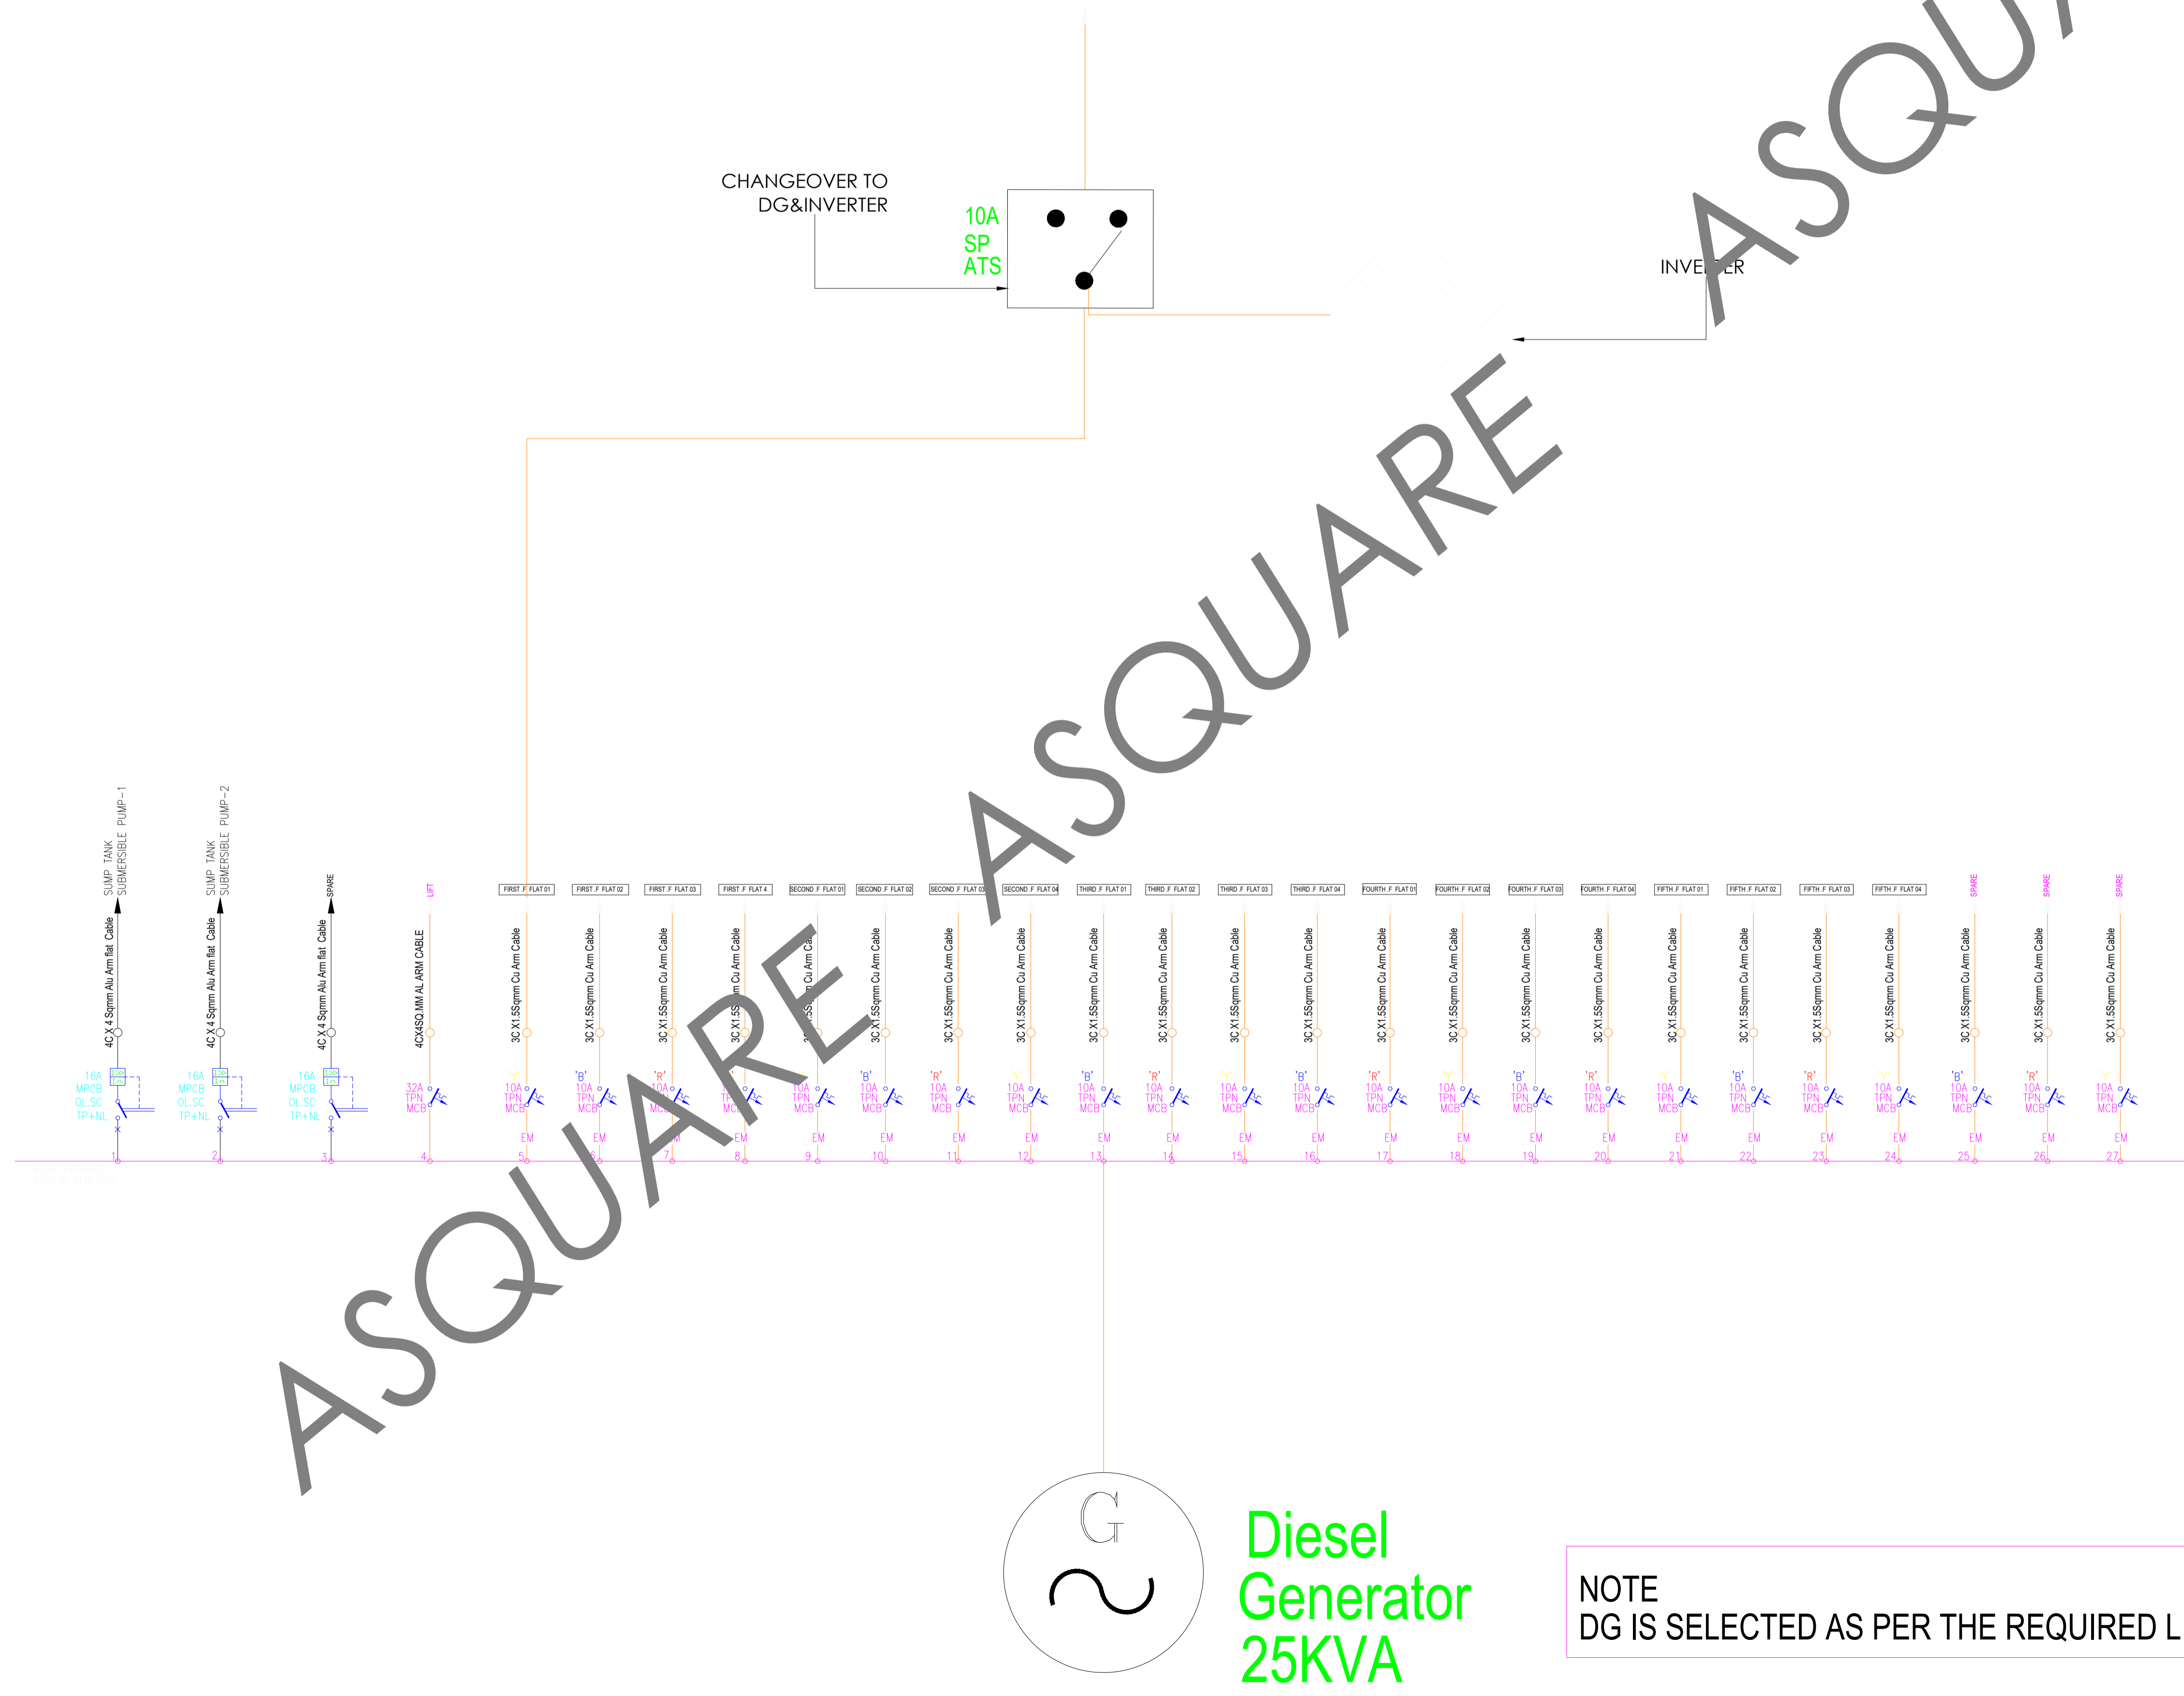

Diesel Generator 25KVA

NOTE
 DG IS SELECTED AS PER THE REQUIRED LIGHTING LOAD

GOOD FOR CONSTRUCTION

Issued by: _____

Issued Date: 03 OCT 2024

COPYRIGHT POLICY

A-SQUARE MEP Consultants (hereafter referred to as "A-SQUARE" retains all copyright and other proprietary rights to the drawings created by A-SQUARE. All drawings created by A-SQUARE are protected by Indian and international copyright laws. Any unauthorized reproduction, distribution, or modification of A-SQUARE's drawings is strictly prohibited. A-SQUARE reserves the right to take legal action against any unauthorized use of its drawings. A-SQUARE grants clients a limited, non-exclusive, non-transferable license to use the drawings for the specific project or purpose for which they were created. Clients may not use the drawings for any other purpose without the express written consent of A-SQUARE. Clients may not modify, reproduce, distribute, transmit, display, perform, publish, license, create derivative works from, transfer, or sell any of A-SQUARE's drawings without the prior written consent of A-SQUARE. Clients may not use any of A-SQUARE's drawings as a basis for the design or construction of any other project without the express written consent of A-SQUARE. Clients may not disclose any of A-SQUARE's drawings to any third party without the prior written consent of A-SQUARE. kindly visit our web-site, to know more.

REVISION CHART

	REVISION DATE	REV. NO.
1	03 AUG 2024	R0
2	19 AUG 2024	R1
3	07 SEP 2024	R2
4	10 OCT 2024	R3

ENGINEERING CONSULTANTS:



G-31, CEDAR BUILDING, BRIGADE ORCHARDS, SPINAL ROAD, DEVANAHALLI, BANGALORE-562110
 Email: Support@a-square.group
 Contact No: +91 9845208299
 www.a-square.group

ARCHITECT NAME

INNOBUILD LANDHOLDINGS

PROJECT NAME:


ALAKANANDA APARTMENTA -AT KAVALI

DRAWING TITLE:


EARTHING SLD

DRWN	CHD	APPD
M.F	ABDUL	ALTAF
SCALE	SHEET SIZE	REV.
NTS	A1	R3


Transformer Neutral Earthing

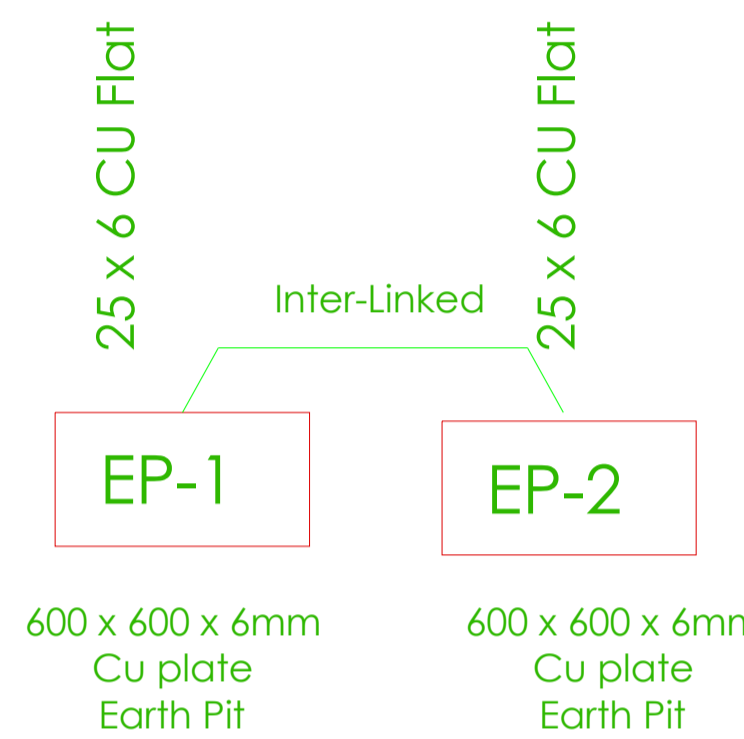


HT PANEL EARTHING

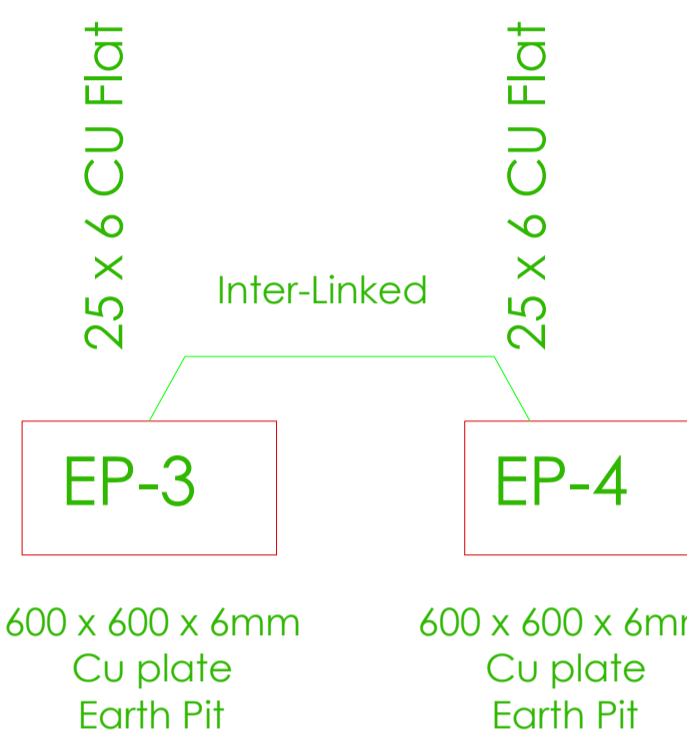


DG ERTHING

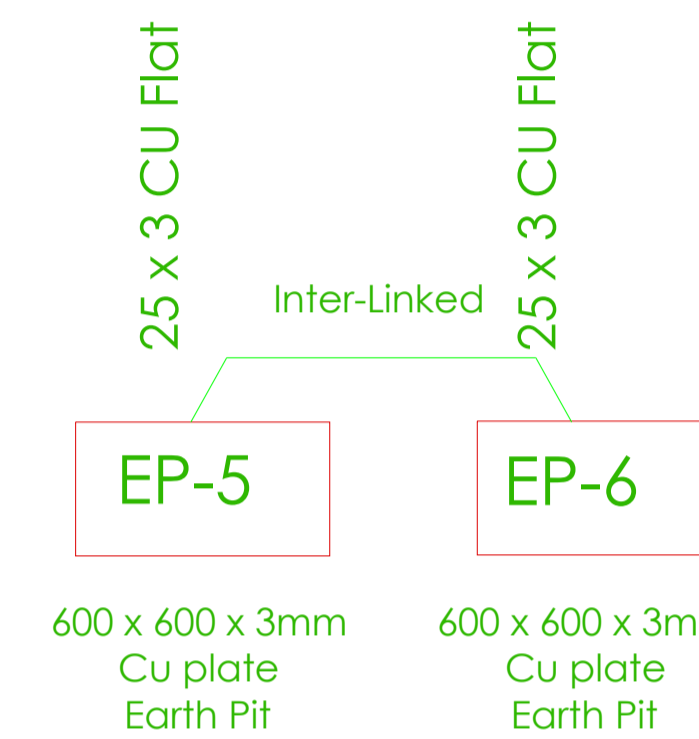


LT PANEL EARTHING

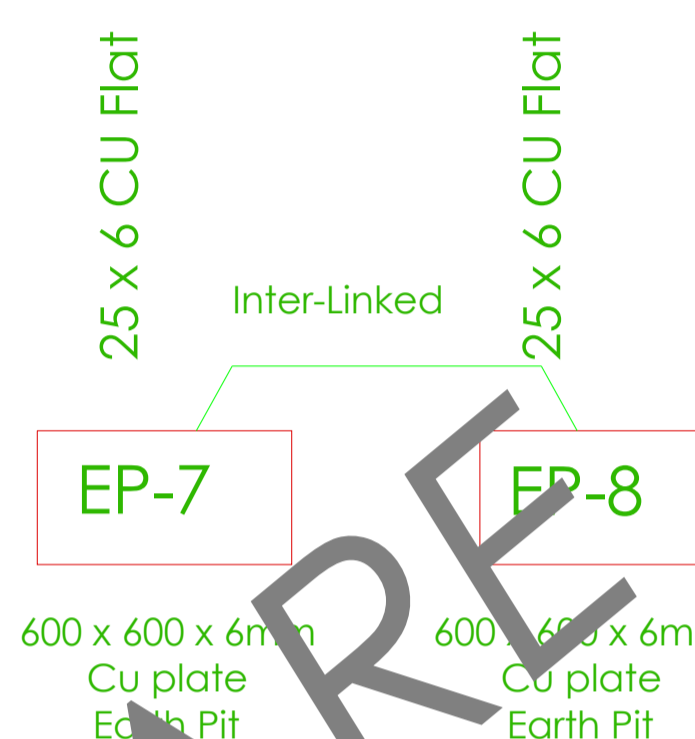

XMER, DG, CT/PT UNIT BODY EARTHING

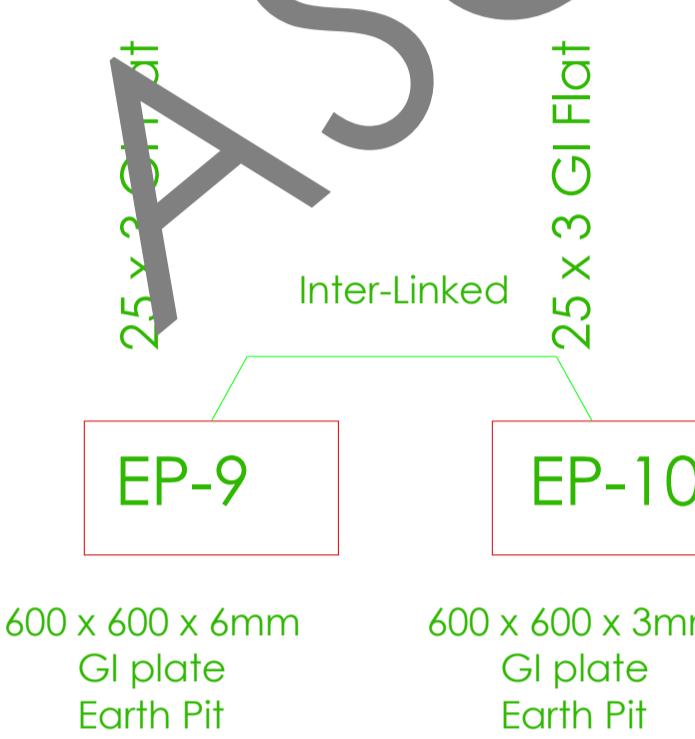


General Body Earthing

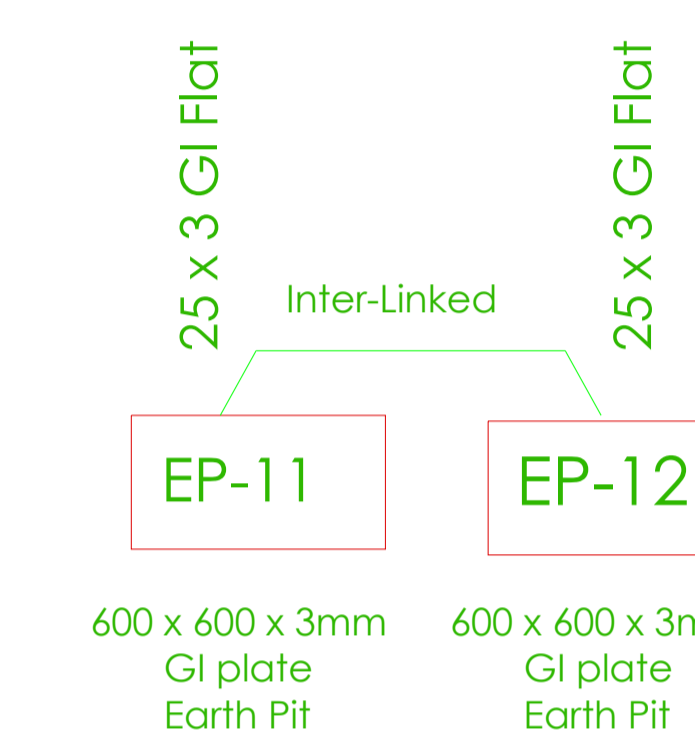


EV CHARGING Earthing



EV CHARGING Earthing

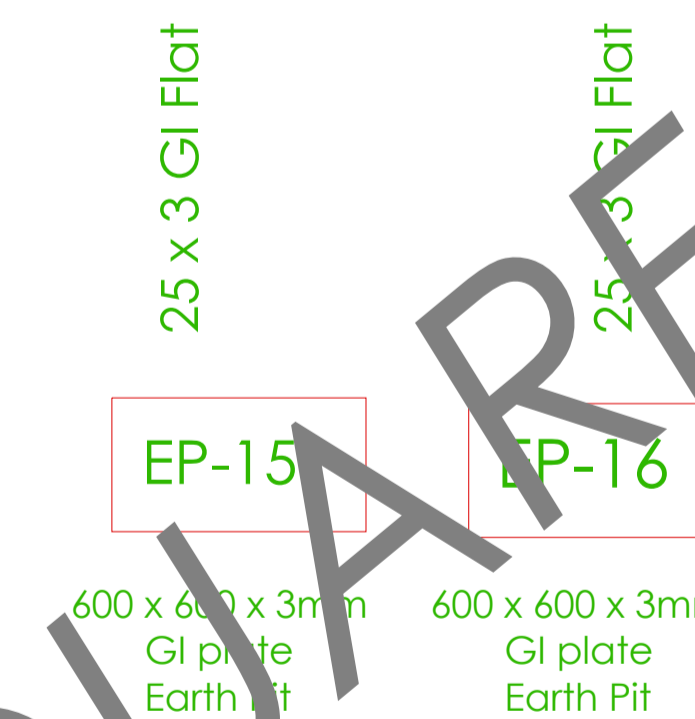

EV CHARGING Earthing

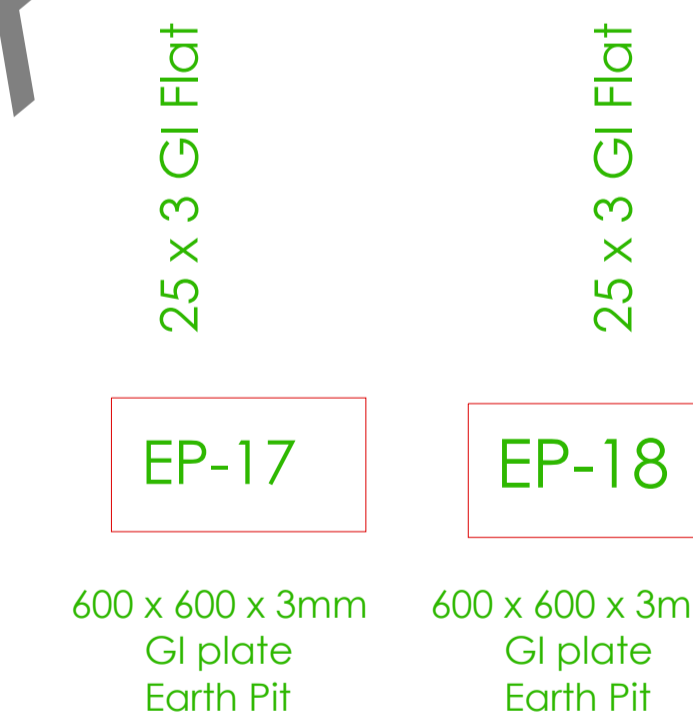

EV CHARGING Earthing



GOOD FOR CONSTRUCTION

Issued by: _____

Issued Date: 03 OCT 2024

COPYRIGHT POLICY

A-SQUARE MEP Consultants (hereafter referred to as "A-SQUARE") retains all copyright and other proprietary rights to the drawings created by A-SQUARE. All drawings created by A-SQUARE are protected by Indian and international copyright laws. Any unauthorized reproduction, distribution, or modification of A-SQUARE's drawings is strictly prohibited. A-SQUARE reserves the right to take legal action against any unauthorized use of its drawings. A-SQUARE grants clients a limited, non-exclusive, non-transferable license to use the drawings for the specific project or purpose for which they were created. Clients may not use the drawings for any other purpose without the express written consent of A-SQUARE. Clients may not modify, reproduce, distribute, transmit, display, perform, publish, license, create derivative works from, transfer, or sell any of A-SQUARE's drawings without the prior written consent of A-SQUARE. Clients may not use any of A-SQUARE's drawings as a basis for the design or construction of any other project without the express written consent of A-SQUARE. Clients may not disclose any of A-SQUARE's drawings to any third party without the prior written consent of A-SQUARE. kindly visit our web-site, to know more.

REVISION CHART

	REVISION DATE	REV. NO.
1	15-07-2024	
2	24-08-2024	
3	09-09-2024	
4	03-10-2024	GFC

ENGINEERING CONSULTANTS:



G-31, CEDAR BUILDING, BRIGADE ORCHARDS, SPINAL ROAD, DEVANAHALLI, BANGALORE- 562110
 Email: Support@a-square.group
 Contact No: +91 9845208299
 www.a-square.group

ARCHITECT NAME

INNOBUILD LANDHOLDINGS PVT. LTD
 #460, 17th cross, 4th sector, CS Towers, HSR layout, Bangalore 560102

PROJECT NAME:

ALAKANANDA APARTMENTS AT KAVALI

DRAWING TITLE:

PLUMBING SPECIFICATIONS

DRWN	CHD	APPD
REJISHNAV	SWETHA	ALTAF

SCALE	SHEET SIZE	REV.
NTS	A1	R2


PLUMBING SPECIFICATIONS

NOTES

HWS	HOT WATER SUPPLY
PD	PLUMBING DUCT
DWS	DOMESTIC WATER SUPPLY
AFFL	ABOVE FINISHED FLOOR LEVEL
ESL	EXTERNAL SOIL LINE
GT	GULLY TRAP
MH	MANHOLE
SANITARY WATER INLET LEVEL	
SHOWER	@2100AFFL
SPOUT	@700AFFL
SINGLE LEVER DIVERTER	@1000AFFL
ABLUTION FAUCET	@ 650 AFFL
SINKCOCK INLET	@ 1000AFFL
CONSEALED STOPCOCK:--TOILET	@1800, KITCHEN@450
ANGLE VALVE:--	
ABLUTION FAUCET	@ 450AFFL
WASH BASIN	@ 500AFFL
AQUA GUARD	@ 1000AFFL
WASHING MACHINE	@ 1000AFFL
GEYSER	@ 2700AFFL

LEGEND

(---S---)	SOIL PIPE
(---W---)	WASTE PIPE
(---DWS---)	DWS
(---HWS---)	HWS
(---SL---)	ESL
	GEYSER
	FLOOR TRAP
	STOP COCK
	ANGLE VALVE
	ABLUTION FAUCET
	GT
	MH
WATER SUPPLY LINES LEVEL (INSIDE WALL)	
DWS	@600 MM FROM AFFL (INSIDE KITCHEN & TOILET)
HWS	@700 MM FROM AFFL (INSIDE TOILET)

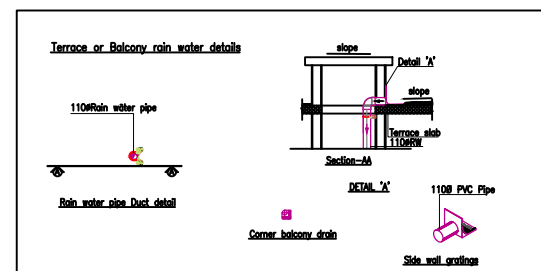

SPECIFICATIONS:-

Under Ground Drinage system
 SOIL & WASTE PIPE - HDPE PIPE/IS14333:1996

Drainage pipe(Toilet inside&Shaft)PVC
 SOIL & WASTE PIPE - 6 kgf/cm2 IS 4985
 RW & BD PIPE - 4 kgf/cm2 IS 4985

Water supply pipe (Toilet inside concealed)
 DWS & HWS - CPVC SDR-11

Water supply pipe (Kitchen, WA and external)
 ASTM Sch-40

GOOD FOR CONSTRUCTION

Issued by: _____

Issued Date: 03 OCT 2024

COPYRIGHT POLICY

A-SQUARE MEP Consultants (hereafter referred to as "A-SQUARE") retains all copyright and other proprietary rights to the drawings created by A-SQUARE. All drawings created by A-SQUARE are protected by Indian and international copyright laws. Any unauthorized reproduction, distribution, or modification of A-SQUARE's drawings is strictly prohibited. A-SQUARE reserves the right to take legal action against any unauthorized use of its drawings. A-SQUARE grants clients a limited, non-exclusive, non-transferable license to use the drawings for the specific project or purpose for which they were created. Clients may not use the drawings for any other purpose without the express written consent of A-SQUARE. Clients may not modify, reproduce, distribute, transmit, display, perform, publish, license, create derivative works from, transfer, or sell any of A-SQUARE's drawings without the prior written consent of A-SQUARE. Clients may not use any of A-SQUARE's drawings as a basis for the design or construction of any other project without the express written consent of A-SQUARE. Clients may not disclose any of A-SQUARE's drawings to any third party without the prior written consent of A-SQUARE. kindly visit our web-site, to know more.

REVISION CHART

	REVISION DATE	REV. NO.
1	15-07-2024	R0
2	24-08-2024	R1
3	09-09-2024	R2
4	03-10-2024	GFC

ENGINEERING CONSULTANTS:



G-31, CEDAR BUILDING, BRIGADE ORCHARDS, SPINAL ROAD, DEVANAHALLI, BANGALORE- 562110
 Email: Support@a-square.group
 Contact No: +91 9845208299
 www.a-sqaure.group

ARCHITECT NAME

INNOBUILD LANDHOLDINGS PVT. LTD
 #460, 17th cross, 4th sector, CS Towers, HSR layout, Bangalore 560102


PROJECT NAME:

ALAKANANDA APARTMENTS AT KAVALI

DRAWING TITLE:

PLUMBING LAYOUT
 STILT FLOOR

DRWN	CHD	APPD
REJISHNAV	SWETHA	ALTAF
SCALE	SHEET SIZE	REV.
NTS	A1	R2

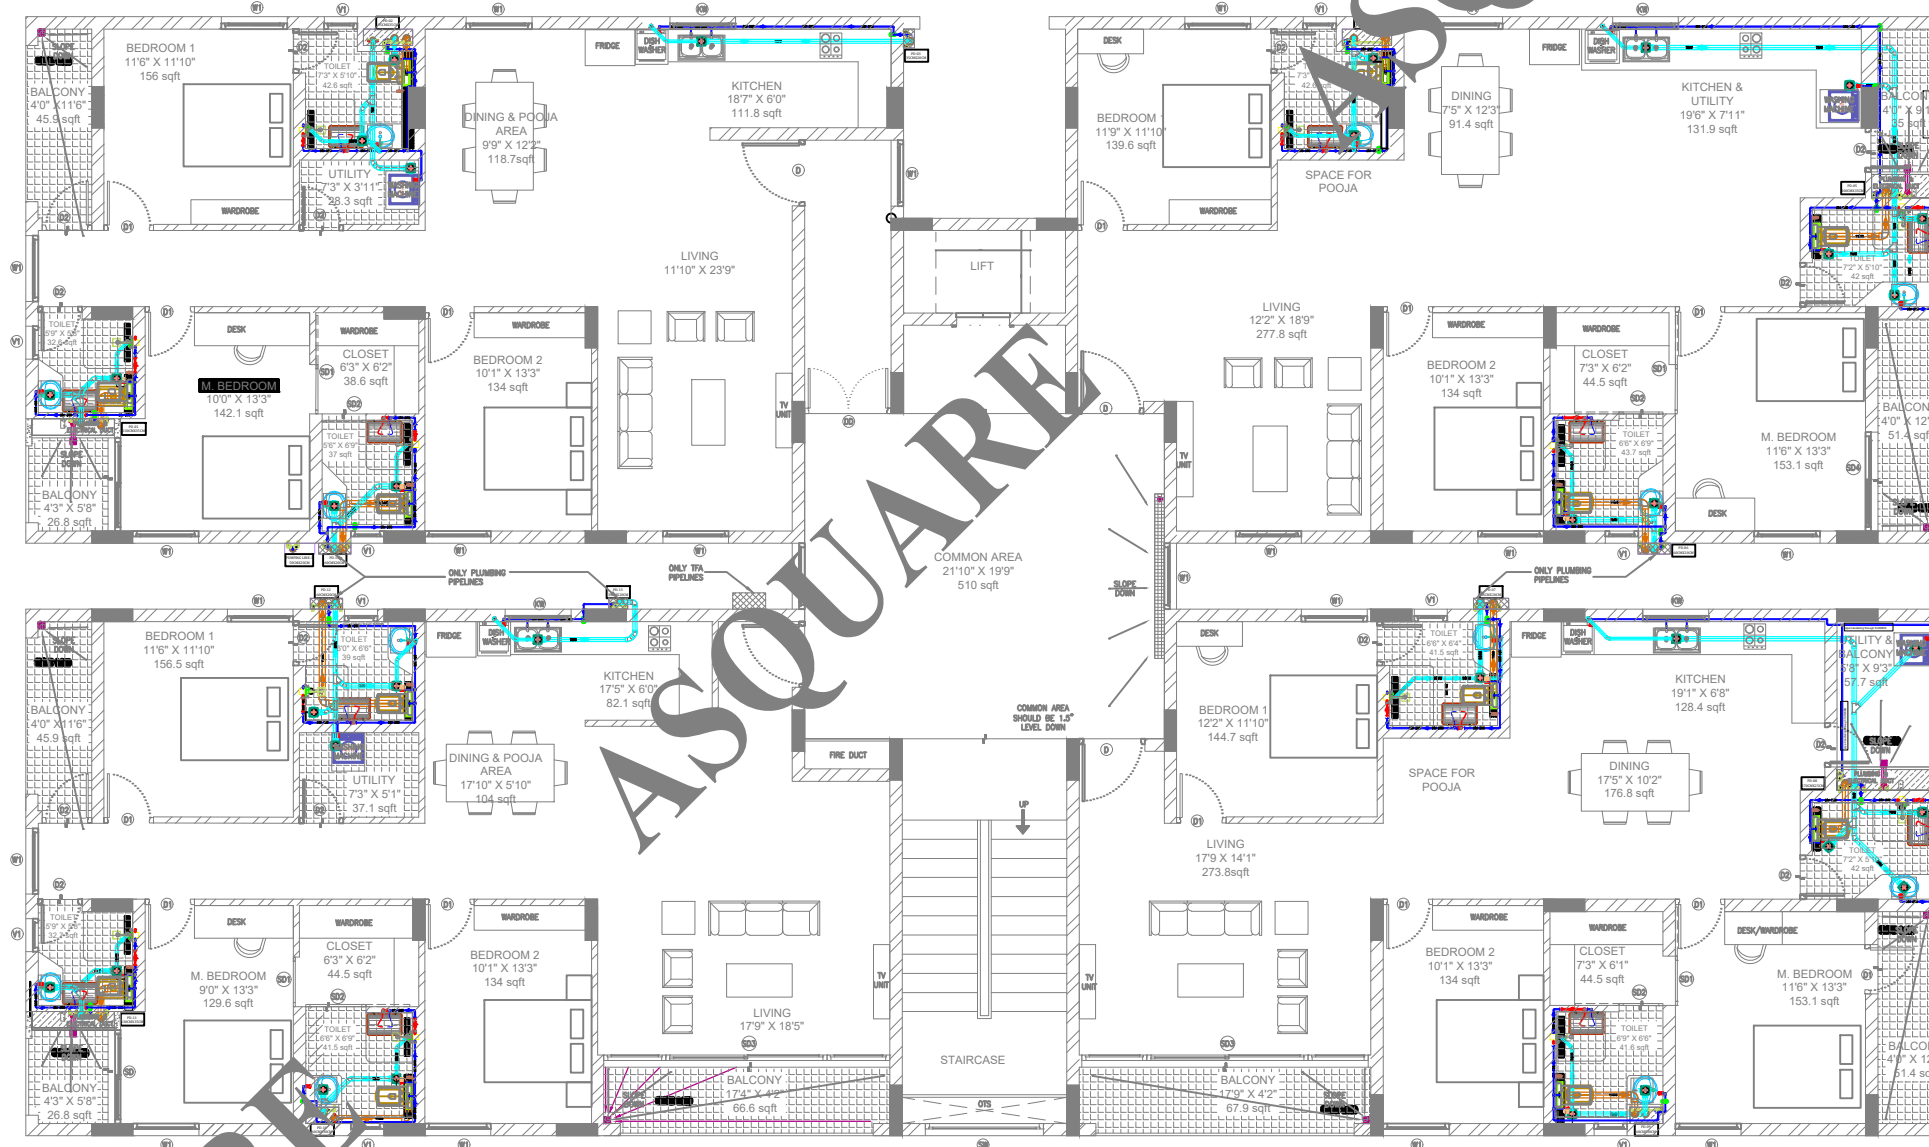

ROAD

GOOD FOR CONSTRUCTION

Issued by: _____

Issued Date: 03 OCT 2024

COPYRIGHT POLICY

A-SQUARE MEP Consultants (hereafter referred to as "A-SQUARE") retains all copyright and other proprietary rights to the drawings created by A-SQUARE. All drawings created by A-SQUARE are protected by Indian and international copyright laws. Any unauthorized reproduction, distribution, or modification of A-SQUARE's drawings is strictly prohibited. A-SQUARE reserves the right to take legal action against any unauthorized use of its drawings. A-SQUARE grants clients a limited, non-exclusive, non-transferable license to use the drawings for the specific project or purpose for which they were created. Clients may not use the drawings for any other purpose without the express written consent of A-SQUARE. Clients may not modify, reproduce, distribute, transmit, display, perform, publish, license, create derivative works from, transfer, or sell any of A-SQUARE's drawings without the prior written consent of A-SQUARE. Clients may not use any of A-SQUARE's drawings as a basis for the design or construction of any other project without the express written consent of A-SQUARE. Clients may not disclose any of A-SQUARE's drawings to any third party without the prior written consent of A-SQUARE. kindly visit our web-site, to know more.

REVISION CHART

	REVISION DATE	REV. NO.
1	15-07-2024	R0
2	24-08-2024	R1
3	09-09-2024	R2
4	03-10-2024	GFC

ENGINEERING CONSULTANTS:



G-31, CEDAR BUILDING, BRIGADE ORCHARDS, SPINAL ROAD, DEVANAHALLI, BANGALORE- 562110
 Email: Support@a-square.group
 Contact No: +91 9845208299
 www.a-sqaure.group

ARCHITECT NAME

INNOBUILD LANDHOLDINGS PVT. LTD
 #460, 17th cross, 4th sector, CS Towers, HSR layout, Bangalore 560102


PROJECT NAME:

ALAKANANDA APARTMENTS AT KAVALI

DRAWING TITLE:

PLUMBING LAYOUT
 STILT FLOOR

DRWN	CHD	APPD
REJISHNAV	SWETHA	ALTAF
SCALE	SHEET SIZE	REV.
NTS	A1	R2

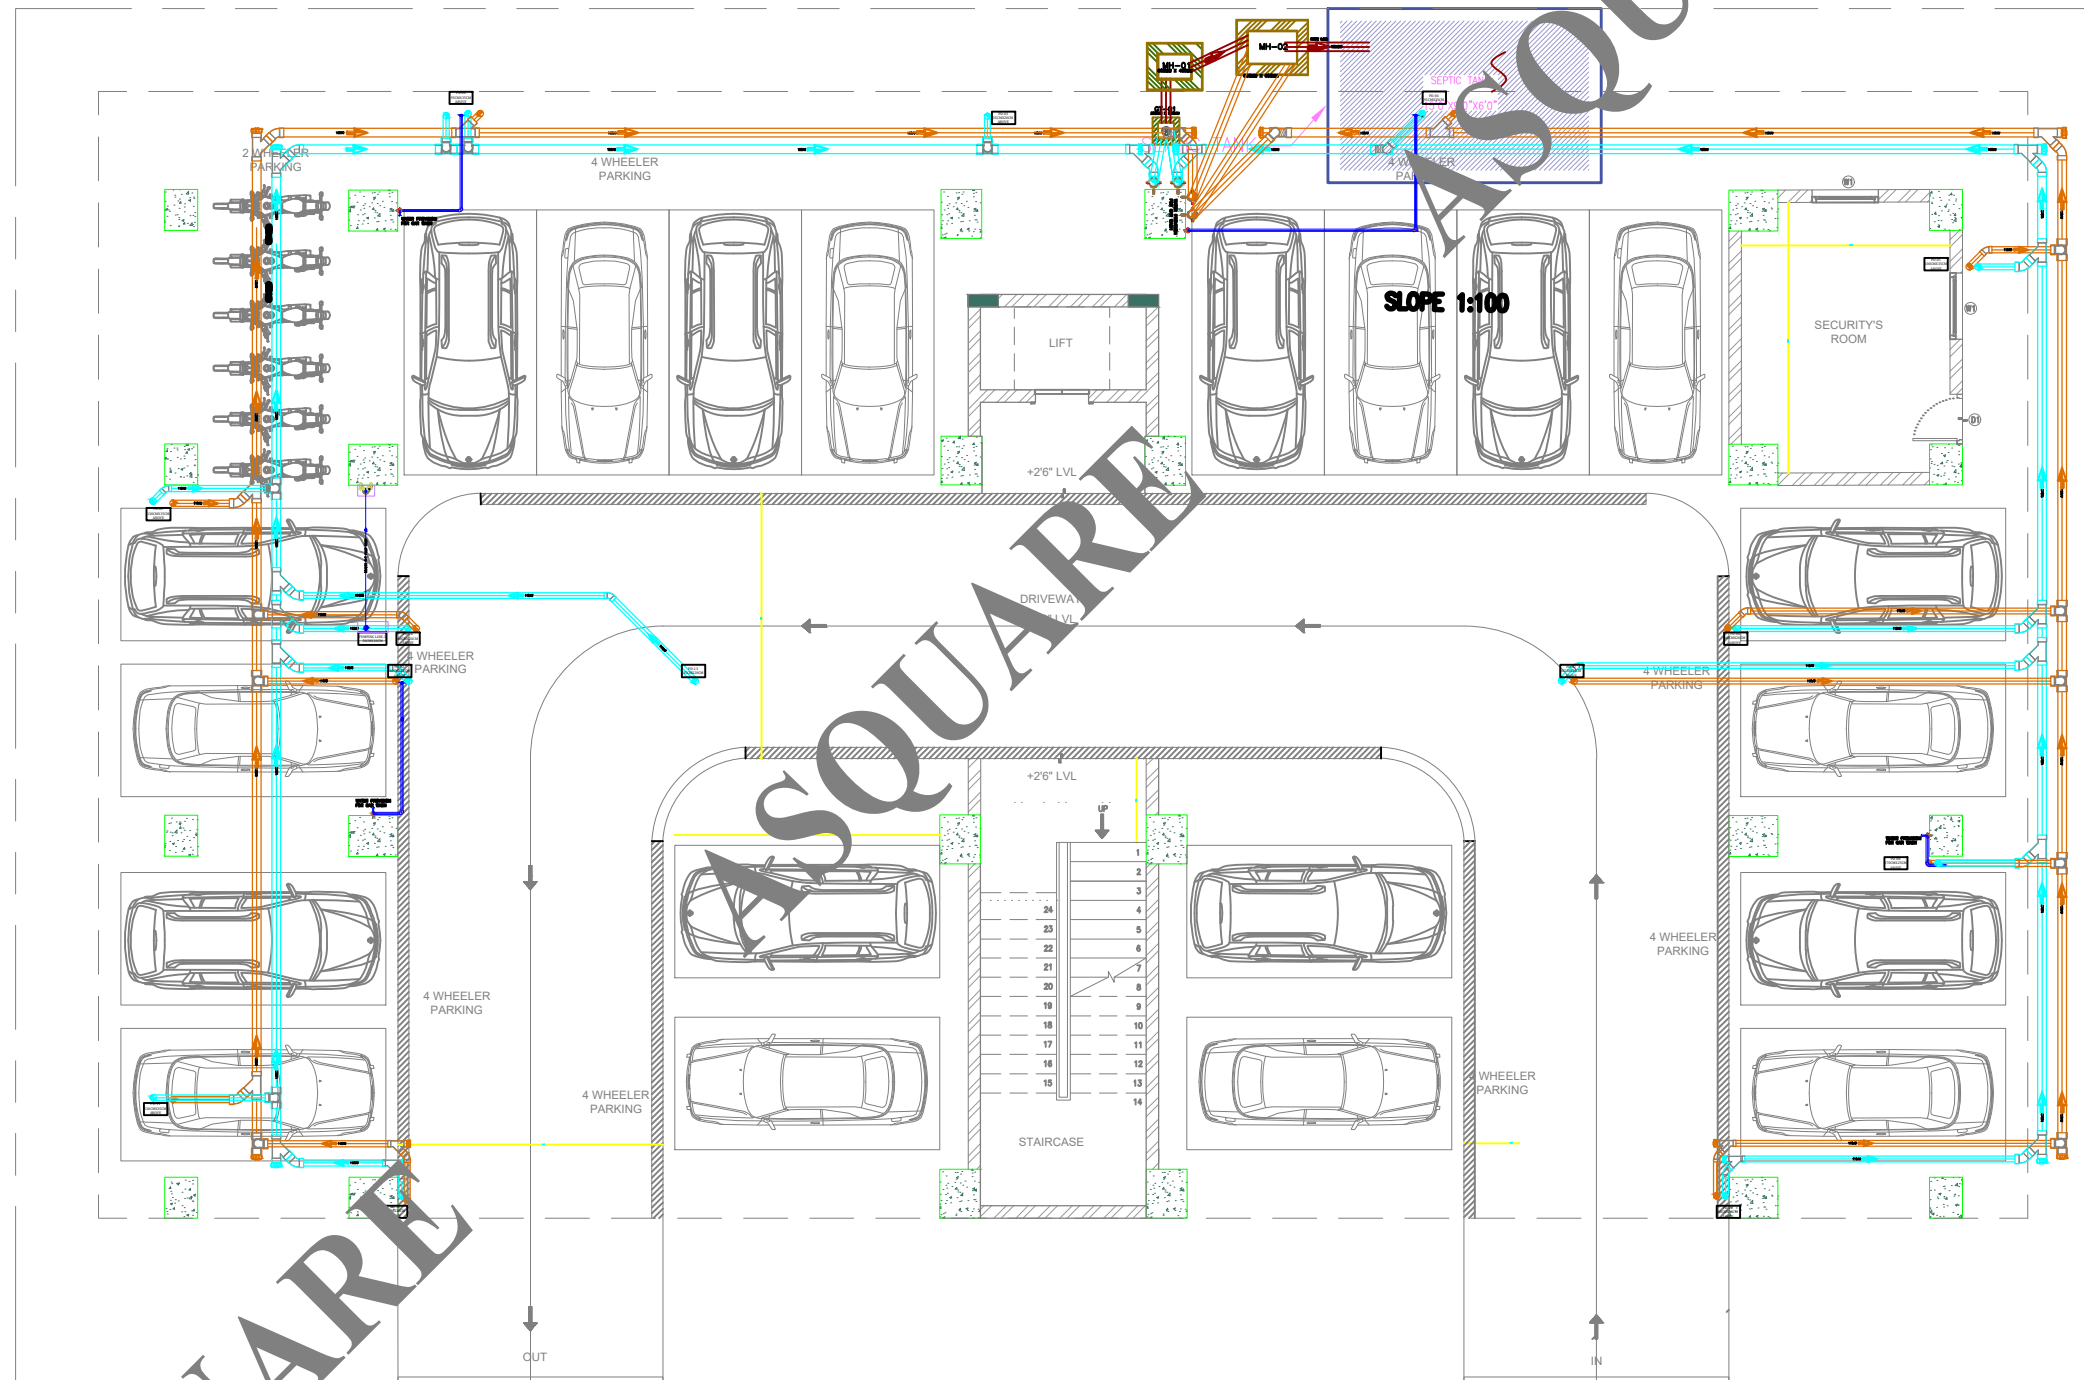

ROAD

A-SQUARE

GOOD FOR CONSTRUCTION

Issued by: _____

Issued Date: 03 OCT 2024

COPYRIGHT POLICY

A-SQUARE MEP Consultants (hereafter referred to as "A-SQUARE") retains all copyright and other proprietary rights to the drawings created by A-SQUARE. All drawings created by A-SQUARE are protected by Indian and international copyright laws. Any unauthorized reproduction, distribution, or modification of A-SQUARE's drawings is strictly prohibited. A-SQUARE reserves the right to take legal action against any unauthorized use of its drawings. A-SQUARE grants clients a limited, non-exclusive, non-transferable license to use the drawings for the specific project or purpose for which they were created. Clients may not use the drawings for any other purpose without the express written consent of A-SQUARE. Clients may not modify, reproduce, distribute, transmit, display, perform, publish, license, create derivative works from, transfer, or sell any of A-SQUARE's drawings without the prior written consent of A-SQUARE. Clients may not use any of A-SQUARE's drawings as a basis for the design or construction of any other project without the express written consent of A-SQUARE. Clients may not disclose any of A-SQUARE's drawings to any third party without the prior written consent of A-SQUARE. kindly visit our web-site, to know more.

REVISION CHART

	REVISION DATE	REV. NO.
1	15-07-2024	R0
2	24-08-2024	R1
3	09-09-2024	R2
4	03-10-2024	GFC

ENGINEERING CONSULTANTS:



G-31, CEDAR BUILDING, BRIGADE ORCHARDS, SPINAL ROAD, DEVANAHALLI, BANGALORE- 562110
 Email: Support@a-square.group
 Contact No: +91 9845208299
 www.a-square.group

ARCHITECT NAME

INNOBUILD LANDHOLDINGS PVT. LTD
 #460, 17th cross, 4th sector, CS Towers, HSR layout, Bangalore 560102


PROJECT NAME:

ALAKANANDA APARTMENTS AT KAVALI

DRAWING TITLE:

PLUMBING LAYOUT
 STILT FLOOR

DRWN	CHD	APPD
REJISHNAV	SWETHA	ALTAF
SCALE	SHEET SIZE	REV.
NTS	A1	R2

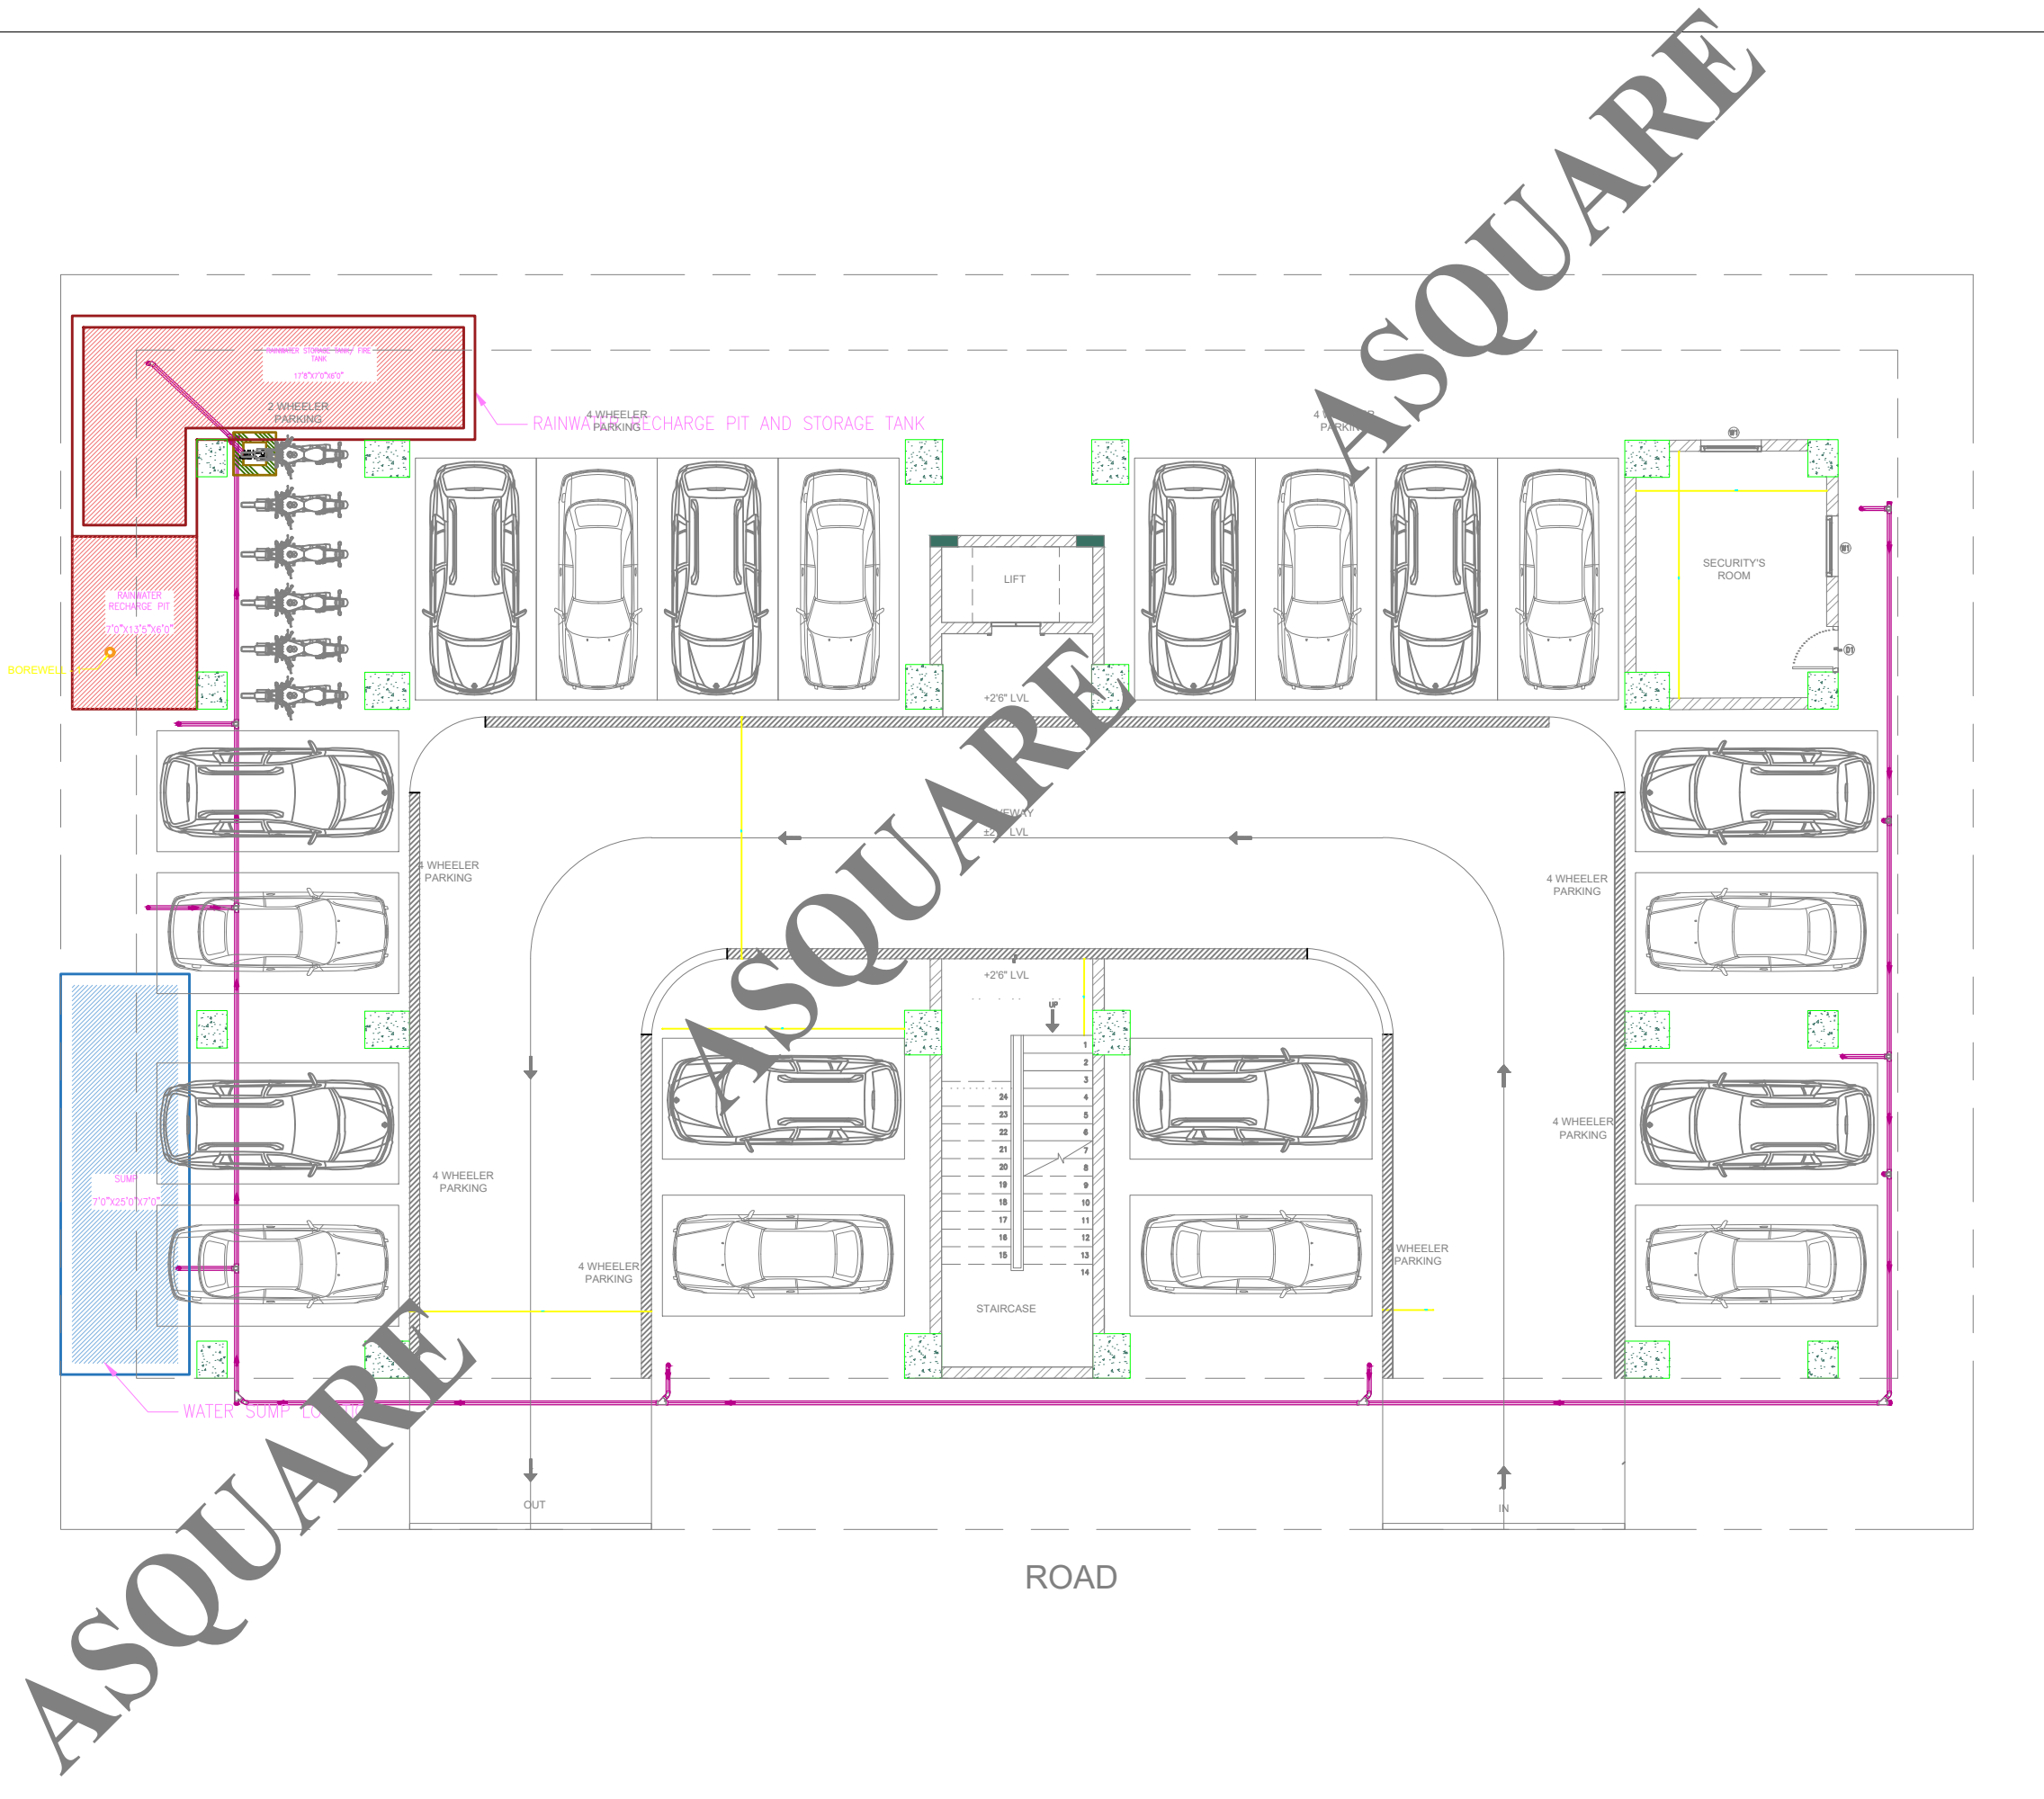

GOOD FOR CONSTRUCTION

Issued by: _____

Issued Date: 03 OCT 2024

COPYRIGHT POLICY

A-SQUARE MEP Consultants (hereafter referred to as "A-SQUARE") retains all copyright and other proprietary rights to the drawings created by A-SQUARE. All drawings created by A-SQUARE are protected by Indian and international copyright laws. Any unauthorized reproduction, distribution, or modification of A-SQUARE's drawings is strictly prohibited. A-SQUARE reserves the right to take legal action against any unauthorized use of its drawings. A-SQUARE grants clients a limited, non-exclusive, non-transferable license to use the drawings for the specific project or purpose for which they were created. Clients may not use the drawings for any other purpose without the express written consent of A-SQUARE. Clients may not modify, reproduce, distribute, transmit, display, perform, publish, license, create derivative works from, transfer, or sell any of A-SQUARE's drawings without the prior written consent of A-SQUARE. Clients may not use any of A-SQUARE's drawings as a basis for the design or construction of any other project without the express written consent of A-SQUARE. Clients may not disclose any of A-SQUARE's drawings to any third party without the prior written consent of A-SQUARE. kindly visit our web-site, to know more.

REVISION CHART

	REVISION DATE	REV. NO.
1	15-07-2024	R0
2	24-08-2024	R1
3	09-09-2024	R2
4	03-10-2024	GFC

ENGINEERING CONSULTANTS:



G-31, CEDAR BUILDING, BRIGADE ORCHARDS, SPINAL ROAD, DEVANAHALLI, BANGALORE- 562110
 Email: Support@a-square.group
 Contact No: +91 9845208299
 www.a-square.group

ARCHITECT NAME

INNOBUILD LANDHOLDINGS PVT. LTD
 #460, 17th cross, 4th sector, CS Towers, HSR layout, Bangalore 560102


PROJECT NAME:

ALAKANANDA APARTMENTS AT KAVALI


DRAWING TITLE:

PLUMBING LAYOUT
 STILT FLOOR

DRWN	CHD	APPD
REJISHNAV	SWETHA	ALTAFA
SCALE	SHEET SIZE	REV.
NTS	A1	R2

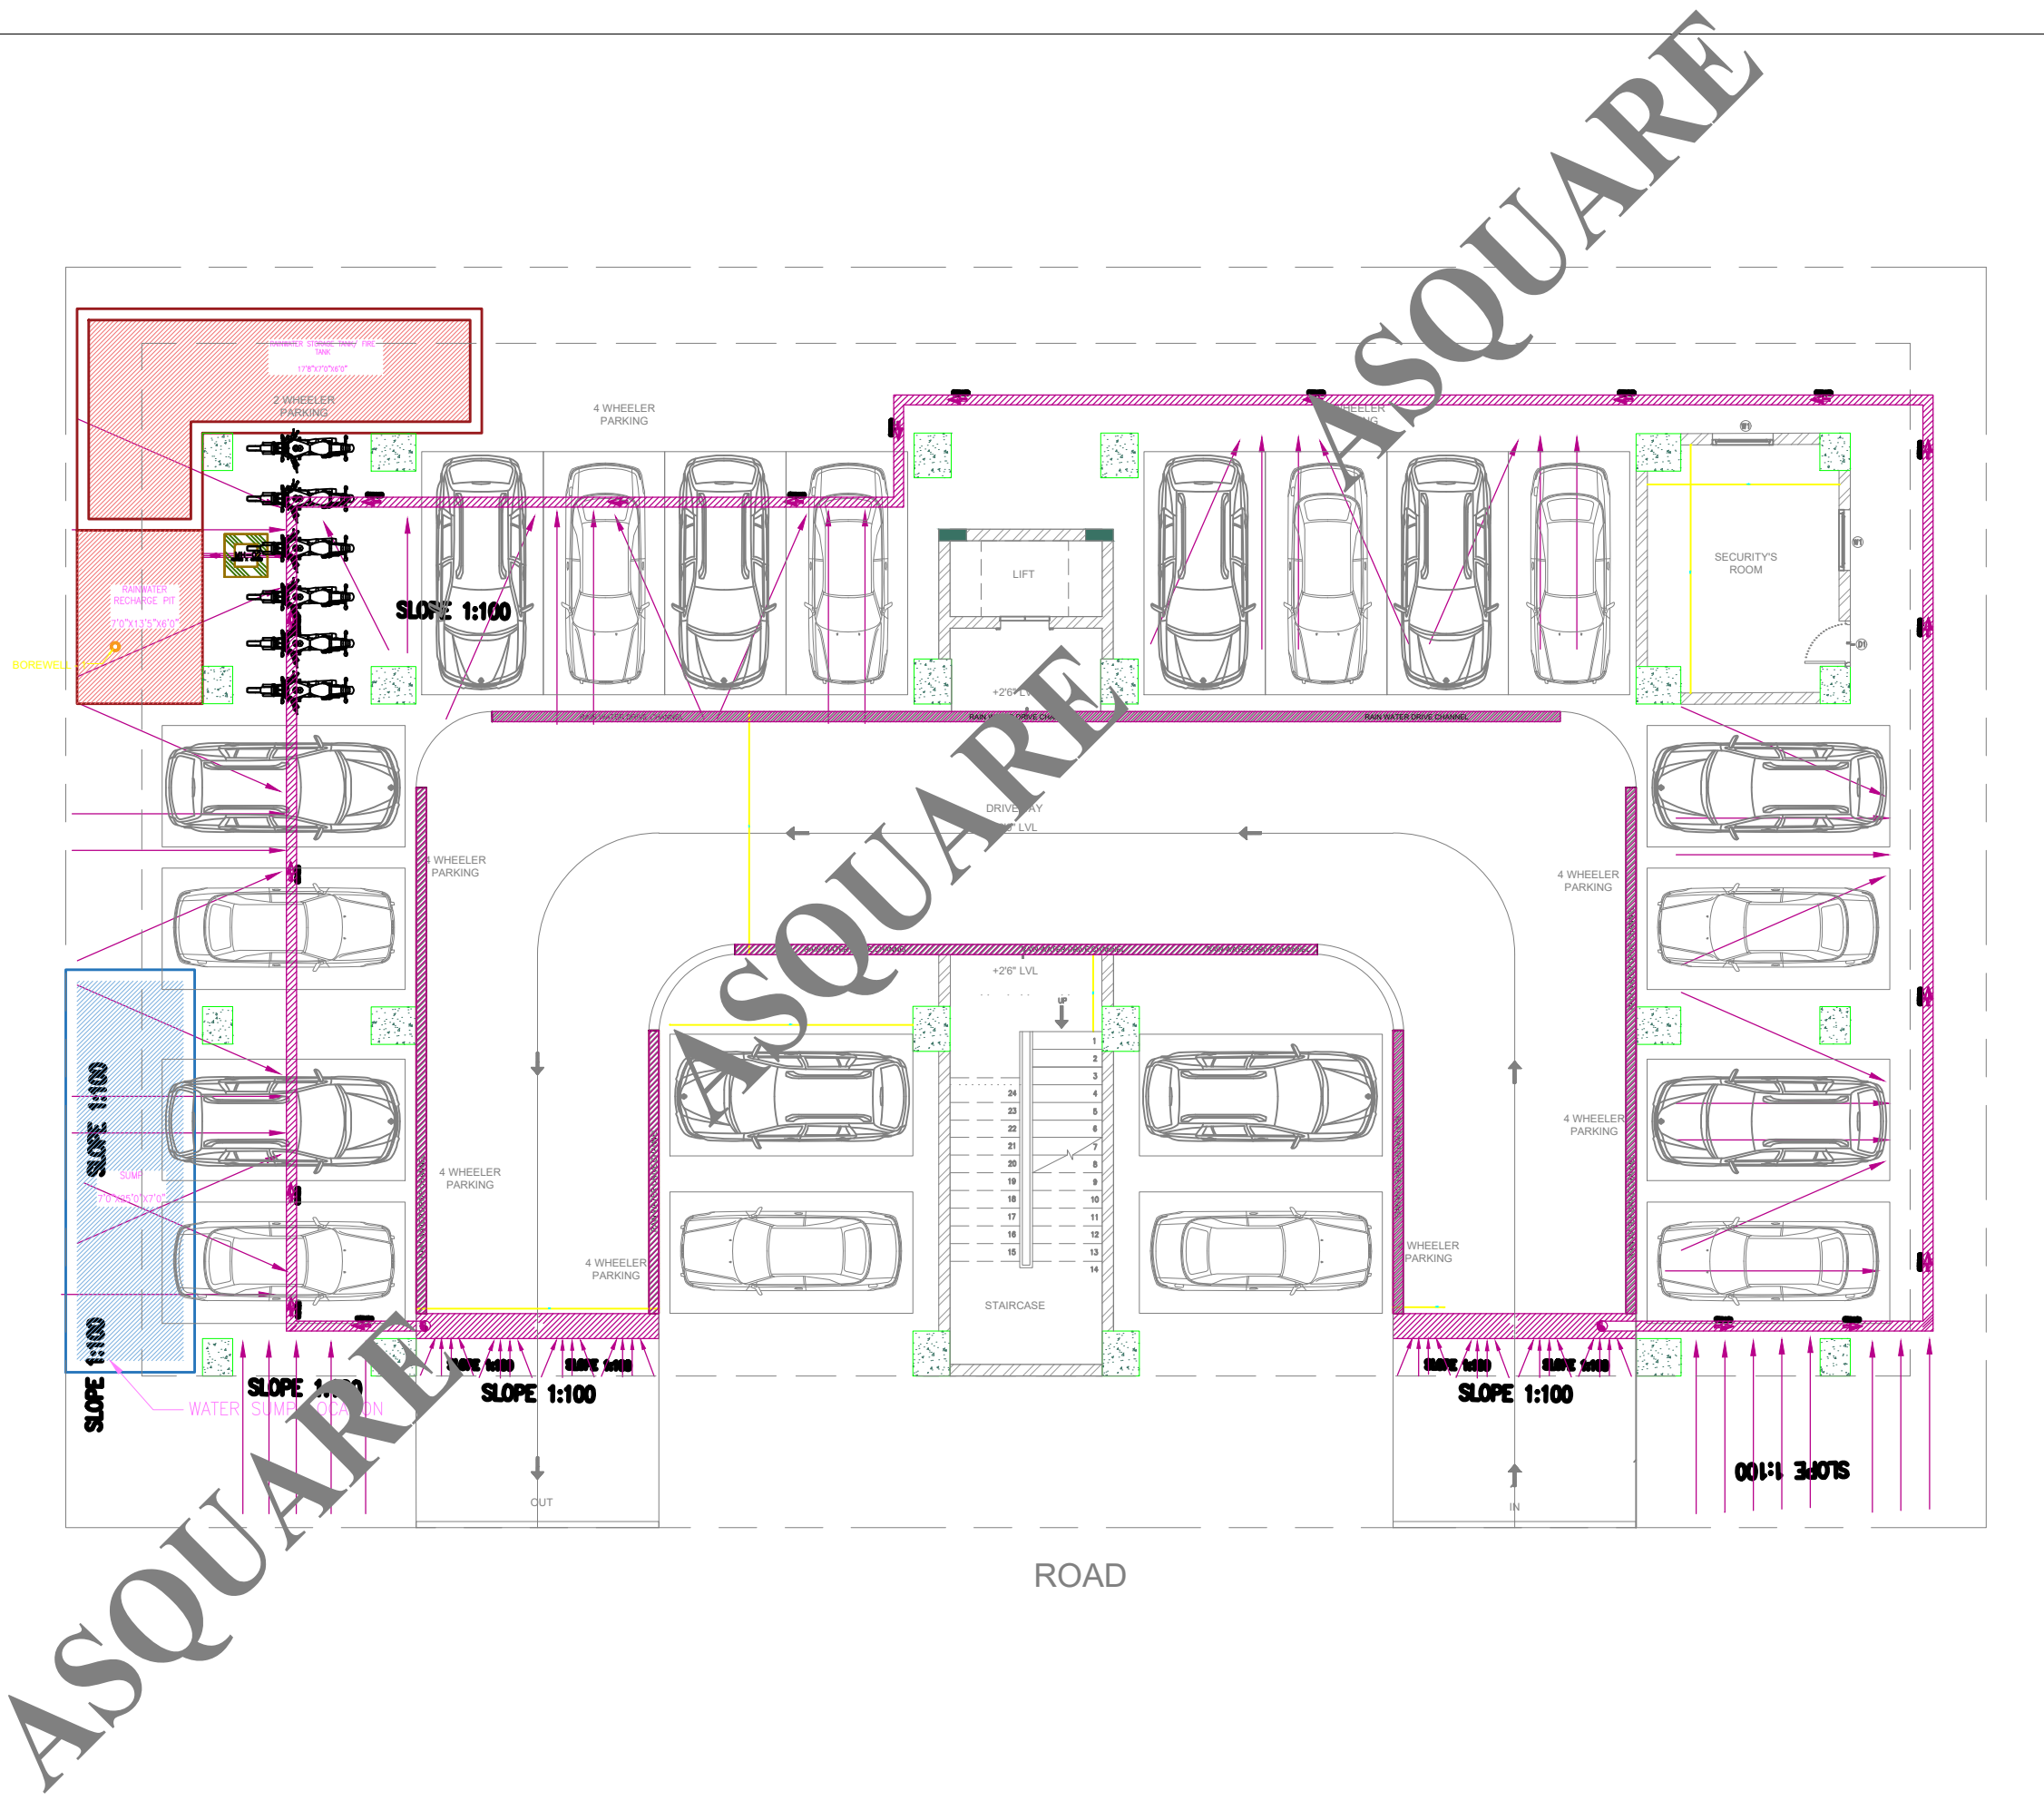

A-SQUARE

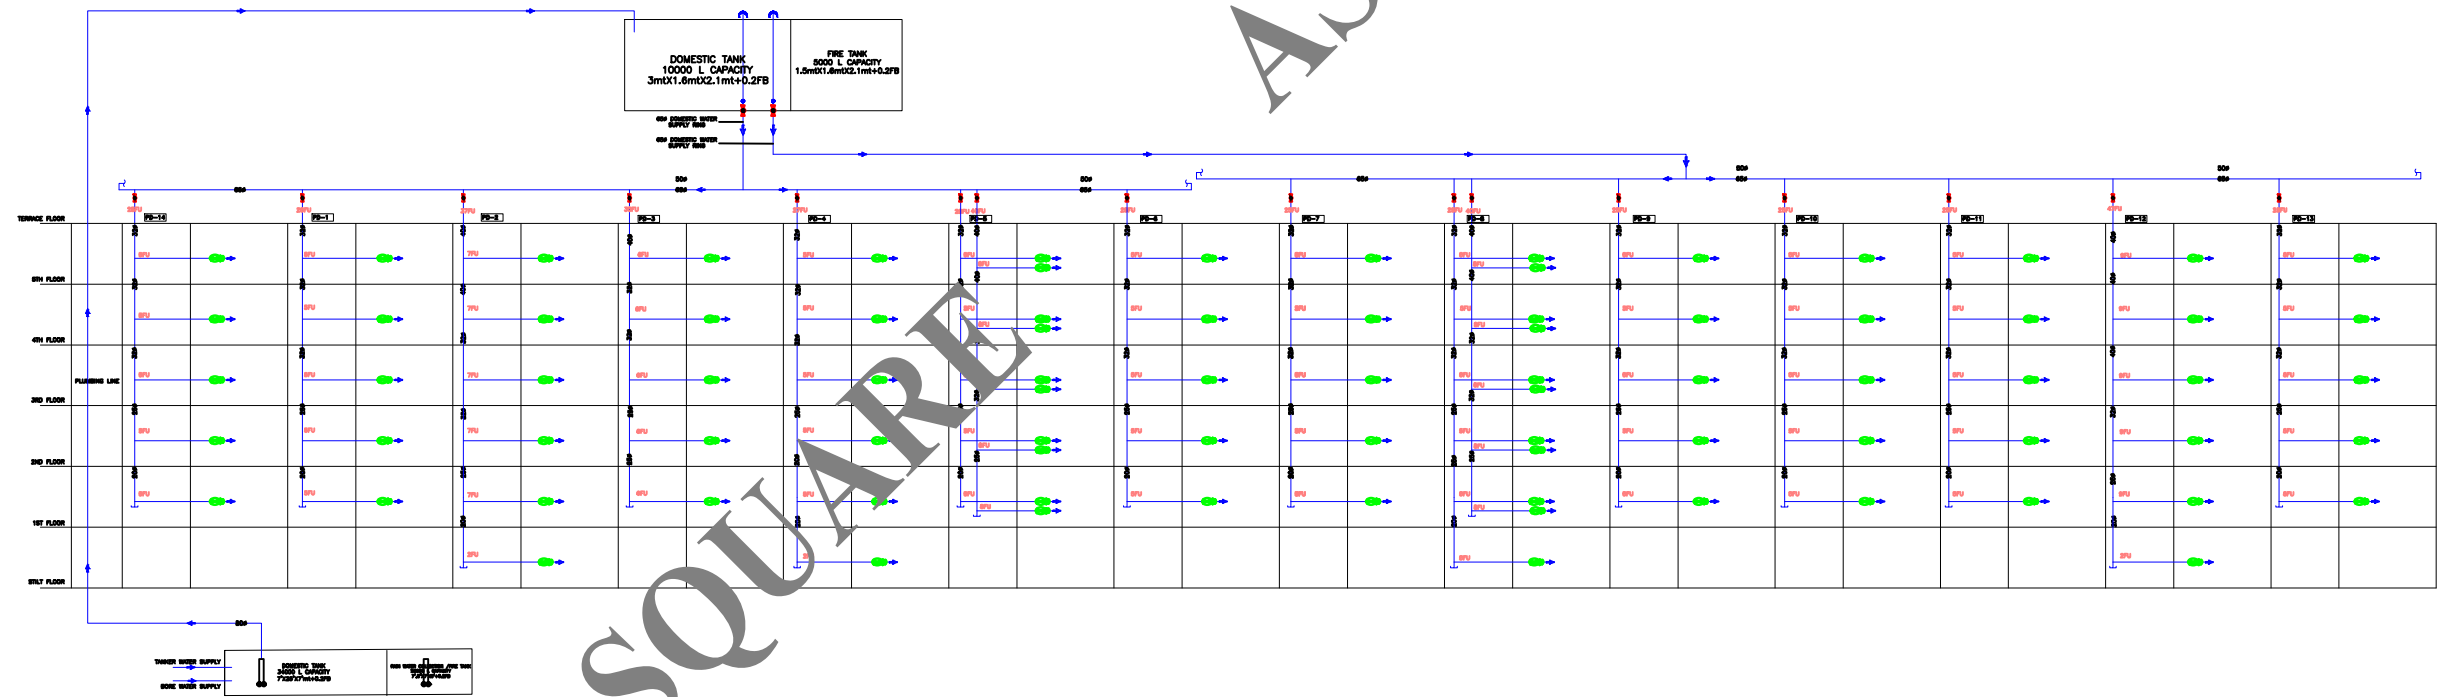

WATER SUPPLY SCHEMATIC DETAILS

A-SQUARE

GOOD FOR CONSTRUCTION

Issued by: _____
 Issued Date: 03 OCT 2024

COPYRIGHT POLICY

A-SQUARE MEP Consultants (hereafter referred to as "A-SQUARE") retains all copyright and other proprietary rights to the drawings created by A-SQUARE. All drawings created by A-SQUARE are protected by Indian and international copyright laws. Any unauthorized reproduction, distribution, or modification of A-SQUARE's drawings is strictly prohibited. A-SQUARE reserves the right to take legal action against any unauthorized use of its drawings. A-SQUARE grants clients a limited, non-exclusive, non-transferable license to use the drawings for the specific project or purpose for which they were created. Clients may not use the drawings for any other purpose without the express written consent of A-SQUARE. Clients may not modify, reproduce, distribute, transmit, display, perform, publish, license, create derivative works from, transfer, or sell any of A-SQUARE's drawings without the prior written consent of A-SQUARE. Clients may not use any of A-SQUARE's drawings as a basis for the design or construction of any other project without the express written consent of A-SQUARE. Clients may not disclose any of A-SQUARE's drawings to any third party without the prior written consent of A-SQUARE. kindly visit our web-site, to know more.

ENGINEERING CONSULTANTS:



G-31, CEDAR BUILDING, BRIGADE ORCHARDS, SPINAL ROAD, DEVANAHALLI, BANGALORE- 562110
 Email: Support@a-square.group
 Contact No: +91 9845208299
 www.a-square.group

ARCHITECT NAME

INNOBUILD LANDHOLDINGS PVT. LTD
 #460, 17th cross, 4th sector, CS Towers, HSR layout, Bangalore 560102

PROJECT NAME:

ALAKANANDA APARTMENTS AT KAVALI

DRAWING TITLE:


PLUMBING LAYOUT
 WATER SUPPLY SCHEMATIC DIAGRAM

DRWN	CHD	APPD
REJISHNAV	SWETHA	ALTAF
SCALE	SHEET SIZE	REV.
NTS	A1	R2

REVISION CHART

NO.	REVISION DATE	REV. NO.
1	15-07-2024	R0
2	24-08-2024	R1
3	09-09-2024	R2
4	03-10-2024	GFC

A-SQUARE

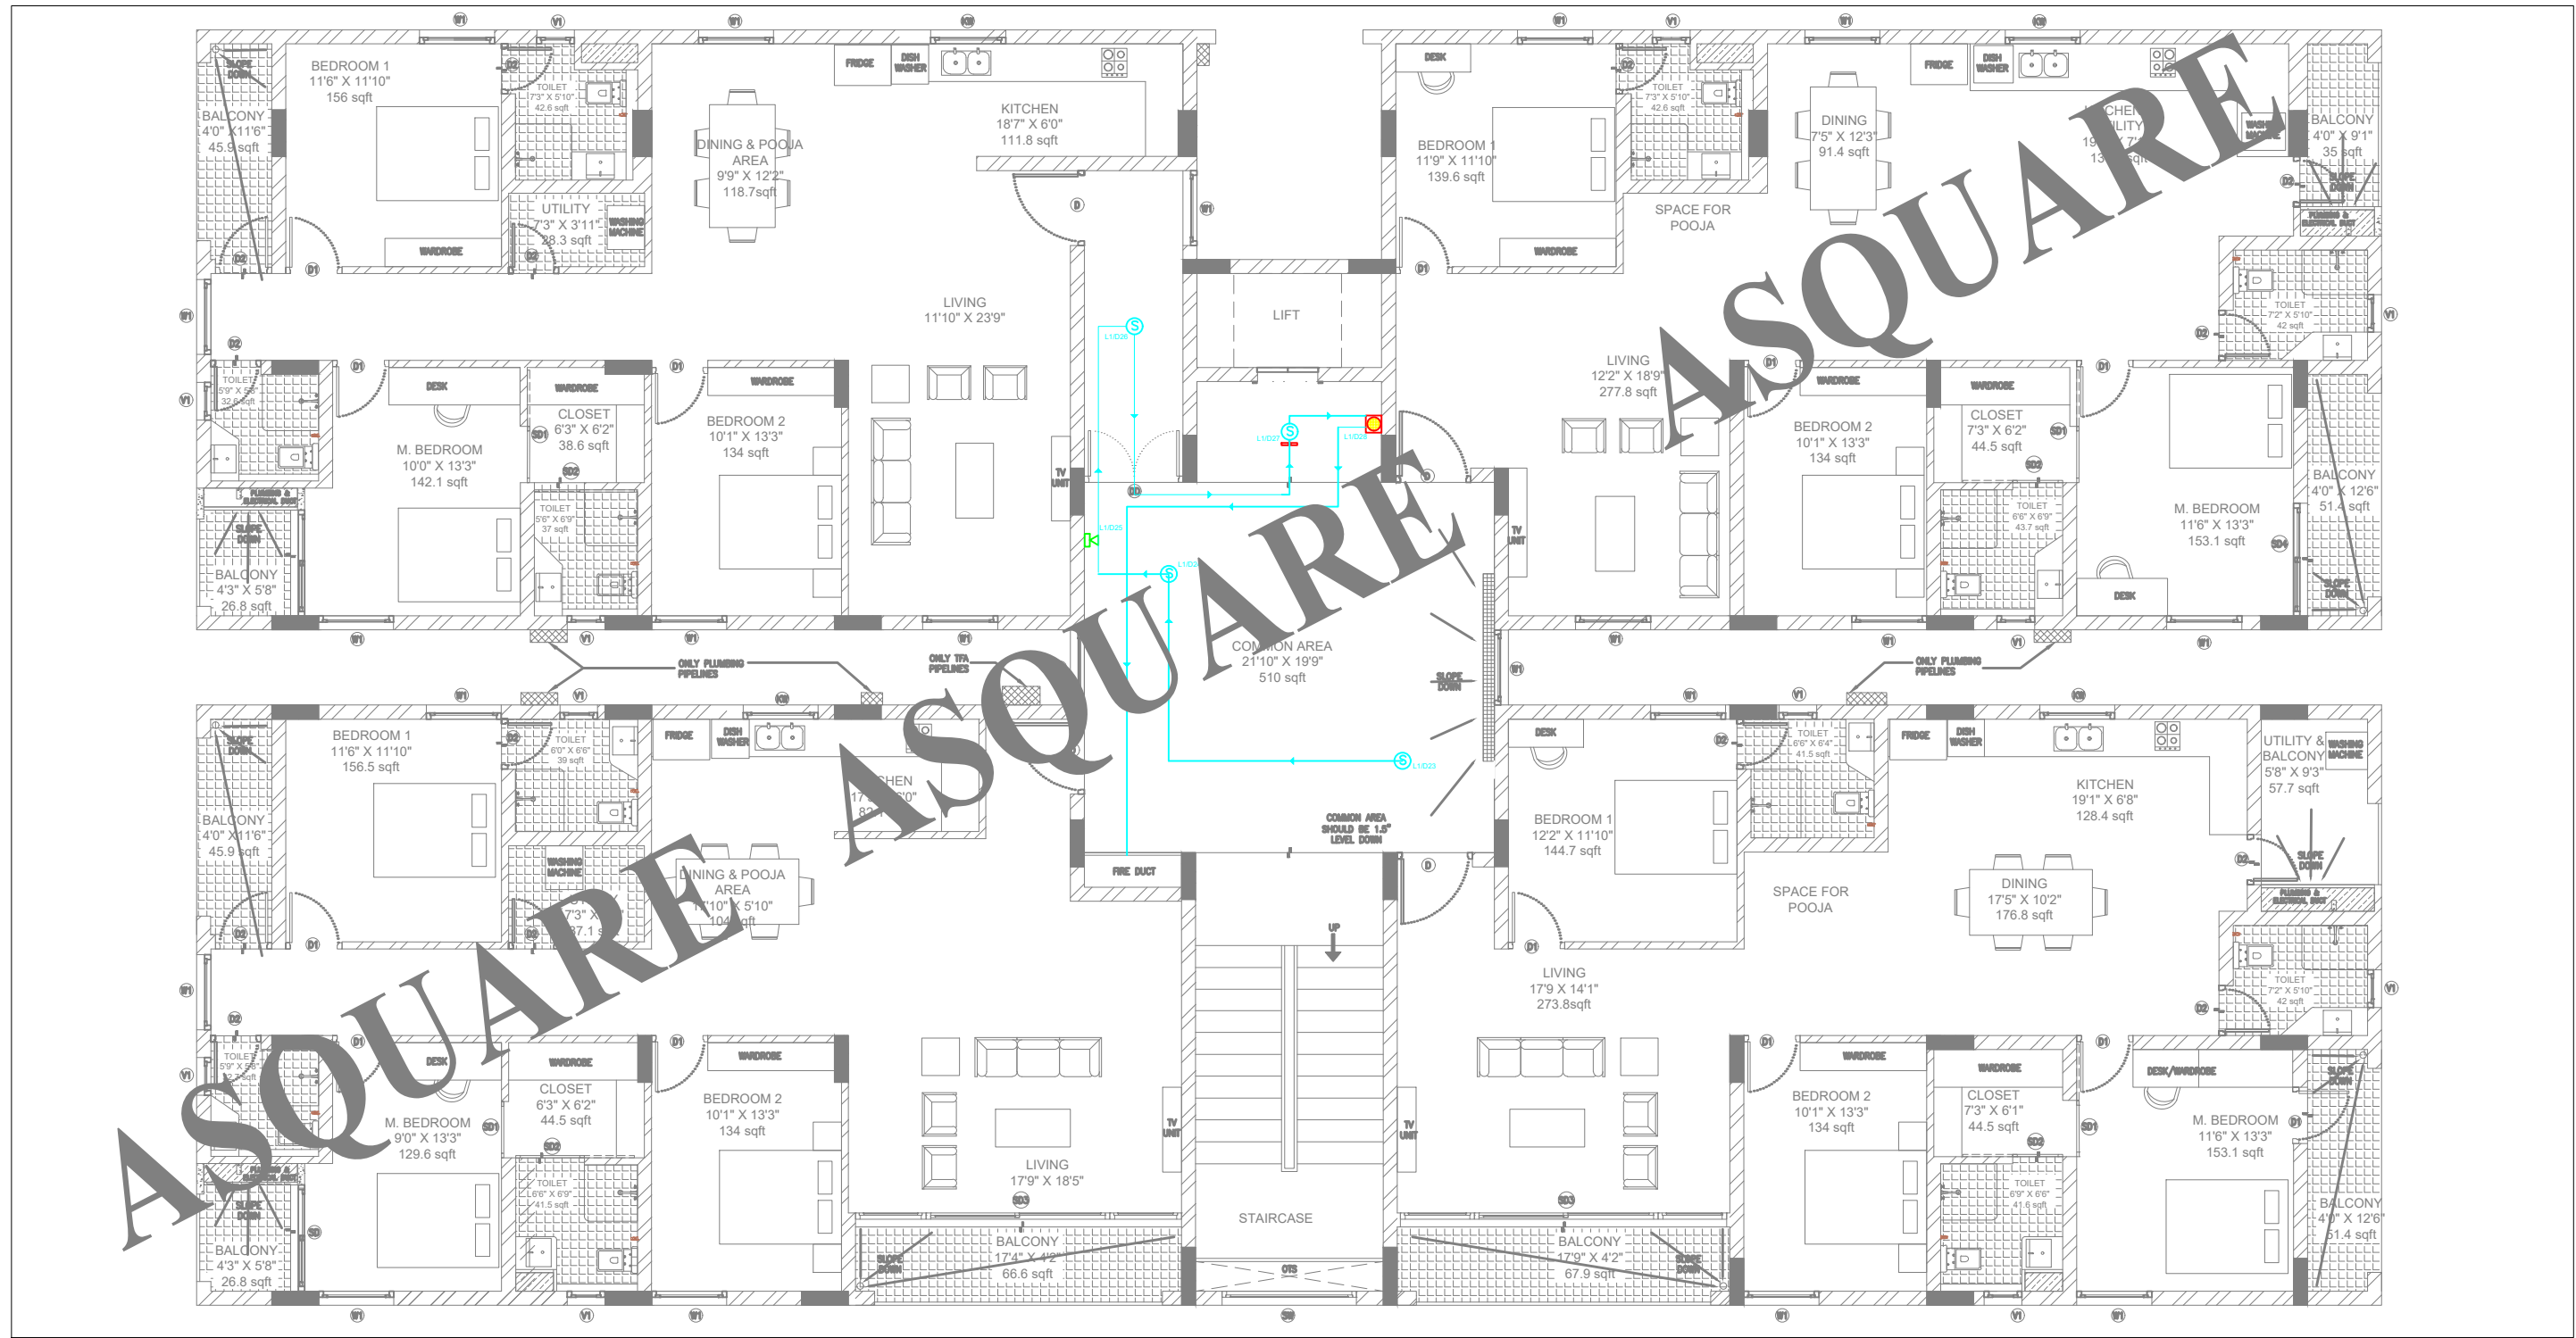

GOOD FOR CONSTRUCTION

Issued by: _____
 Issued Date: 03 OCT 2024

COPYRIGHT POLICY

A-SQUARE MEP Consultants (hereafter referred to as "A-SQUARE") retains all copyright and other proprietary rights to the drawings created by A-SQUARE. All drawings created by A-SQUARE are protected by Indian and international copyright laws. Any unauthorized reproduction, distribution, or modification of A-SQUARE's drawings is strictly prohibited. A-SQUARE reserves the right to take legal action against any unauthorized use of its drawings. A-SQUARE grants clients a limited, non-exclusive, non-transferable license to use the drawings for the specific project or purpose for which they were created. Clients may not use the drawings for any other purpose without the express written consent of A-SQUARE. Clients may not modify, reproduce, distribute, transmit, display, perform, publish, license, create derivative works from, transfer, or sell any of A-SQUARE's drawings without the prior written consent of A-SQUARE. Clients may not use any of A-SQUARE's drawings as a basis for the design or construction of any other project without the express written consent of A-SQUARE. Clients may not disclose any of A-SQUARE's drawings to any third party without the prior written consent of A-SQUARE. kindly visit our web-site, to know more.

ENGINEERING CONSULTANTS:



G-31, CEDAR BUILDING, BRIGADE ORCHARDS, SPINAL ROAD, DEVANAHALLI, BANGALORE-562110
 Email: Support@a-square.group
 Contact No: +91 9845208299
 www.a-square.group

PROJECT NAME:
ALAKANANDA APARTMENTS AT KAVALI

DRWN	CHD	APPD
ASHIK	VIJAY	ALTAF

REVISION CHART

	REVISION DATE	REV. NO.
1	15-07-2024	R0
2	24-08-2024	R1
3	09-09-2024	R2
4		


ARCHITECT NAME

INNOBUILD LANDHOLDINGS PVT. LTD
 #460, 17th cross, 4th sector, CS Towers, HSR layout, Bangalore 560102

DRAWING TITLE:

SMOKE LAYOUT

SCALE	SHEET SIZE	REV.
NTS	A1	R2

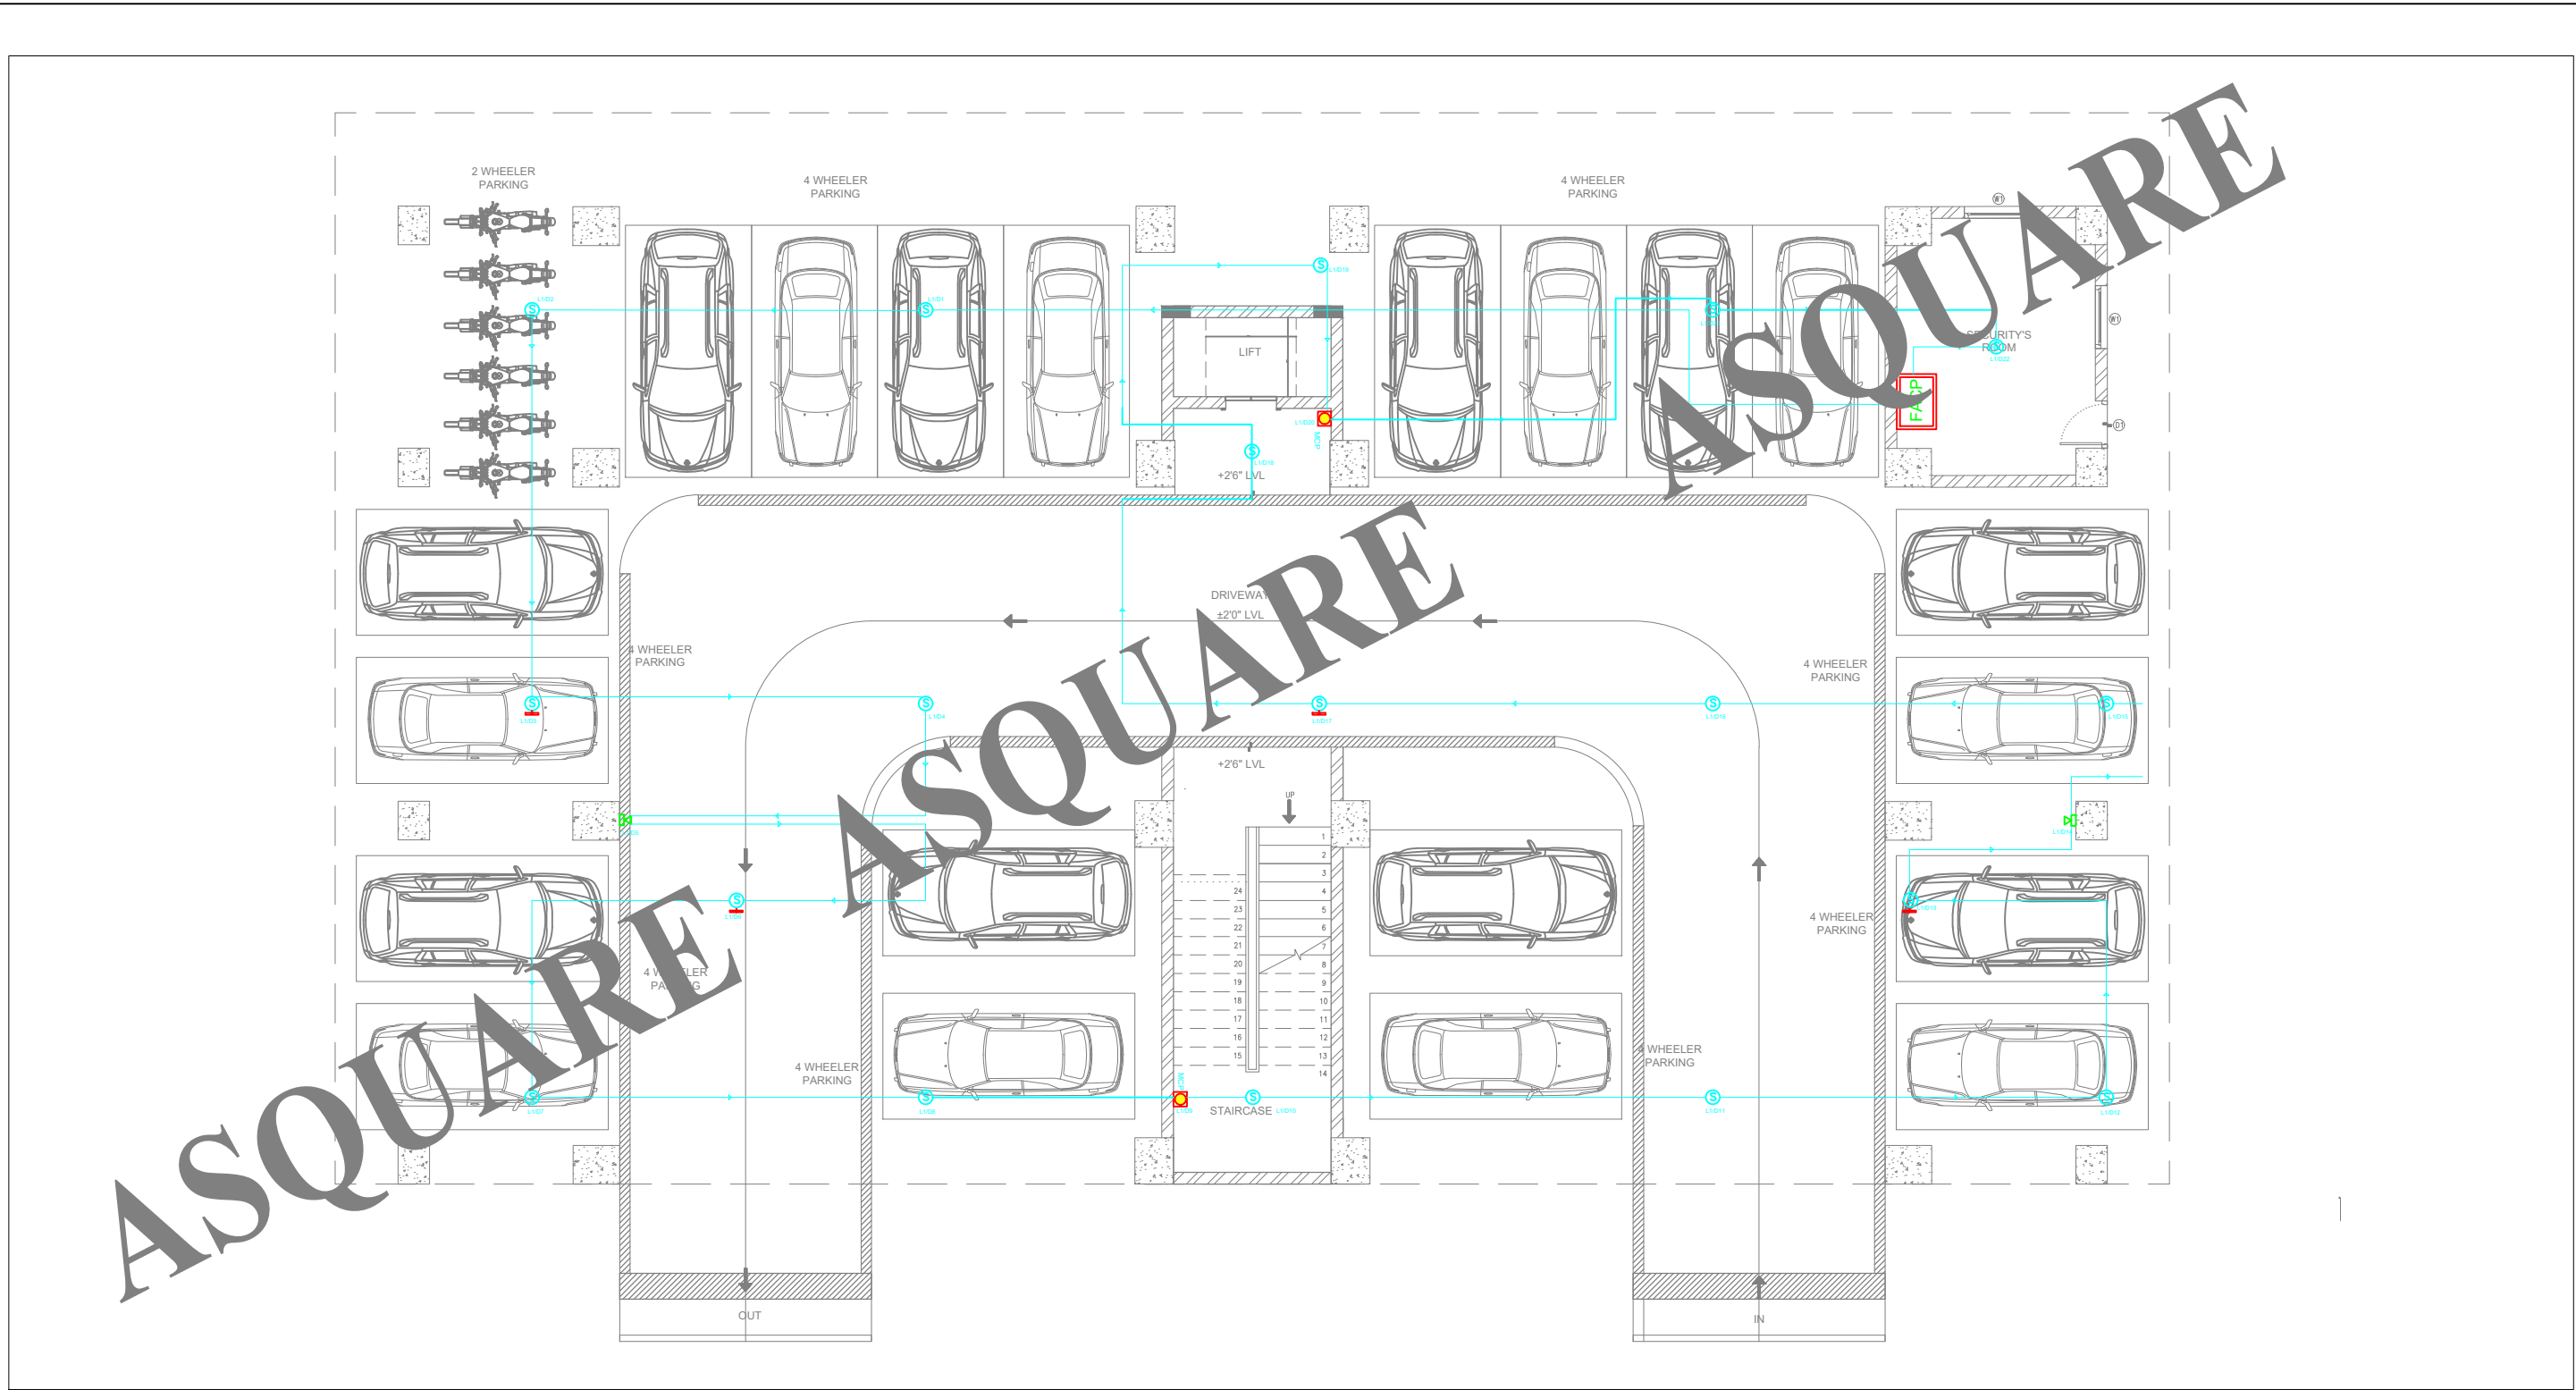

GOOD FOR CONSTRUCTION

Issued by: _____
 Issued Date: 03 OCT 2024

COPYRIGHT POLICY

A-SQUARE MEP Consultants (hereafter referred to as "A-SQUARE") retains all copyright and other proprietary rights to the drawings created by A-SQUARE. All drawings created by A-SQUARE are protected by Indian and international copyright laws. Any unauthorized reproduction, distribution, or modification of A-SQUARE's drawings is strictly prohibited. A-SQUARE reserves the right to take legal action against any unauthorized use of its drawings. A-SQUARE grants clients a limited, non-exclusive, non-transferable license to use the drawings for the specific project or purpose for which they were created. Clients may not use the drawings for any other purpose without the express written consent of A-SQUARE. Clients may not modify, reproduce, distribute, transmit, display, perform, publish, license, create derivative works from, transfer, or sell any of A-SQUARE's drawings without the prior written consent of A-SQUARE. Clients may not use any of A-SQUARE's drawings as a basis for the design or construction of any other project without the express written consent of A-SQUARE. Clients may not disclose any of A-SQUARE's drawings to any third party without the prior written consent of A-SQUARE. kindly visit our web-site, to know more.

ENGINEERING CONSULTANTS:



G-31, CEDAR BUILDING, BRIGADE ORCHARDS, SPINAL ROAD, DEVANAHALLI, BANGALORE-562110
 Email: Support@a-square.group
 Contact No: +91 9845208299
 www.a-square.group

PROJECT NAME:

ALAKANANDA APARTMENTS AT KAVALI

DRWN	CHD	APPD
------	-----	------

ASHIK	VIJAY	ALTAF
--------------	--------------	--------------

REVISION CHART

	REVISION DATE	REV. NO.
1	15-07-2024	R0
2	24-08-2024	R1
3	09-09-2024	R2
4		

ARCHITECT NAME

INNOBUILD LANDHOLDINGS PVT. LTD
 #460, 17th cross, 4th sector, CS Towers, HSR layout, Bangalore 560102

DRAWING TITLE:



SMOKE LAYOUT

SCALE	SHEET SIZE	REV.
-------	------------	------



NTS	A1	R2
-----	----	----

A-SQUARE

LEGENDS		
SYMBOLS	DESCRIPTION	QUANTITY
	FIRE ALARM CONTROL PANEL	1
	ADDRESSABLE INTELLIGENT MANUAL CALL POINT	2
	SMOKE DETECTORS	18
	HOOTER	2
	WALL MOUNTED SMOKE DETECTORS	
	RESPONSE INDICTER	3

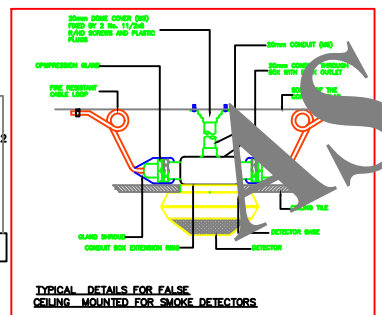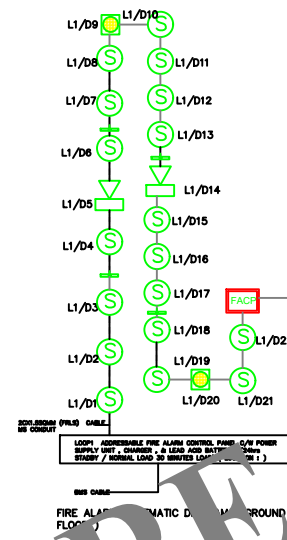

LEGENDS		
SYMBOLS	DESCRIPTION	QUANTITY
	FIRE ALARM CONTROL PANEL	1
	ADDRESSABLE INTELLIGENT MANUAL CALL POINT	1
	SMOKE DETECTORS	2
	HOOTER	1
	WALL MOUNTED SMOKE DETECTORS	2
	RESPONSE INDICTER	1

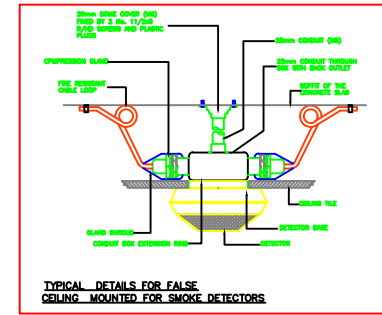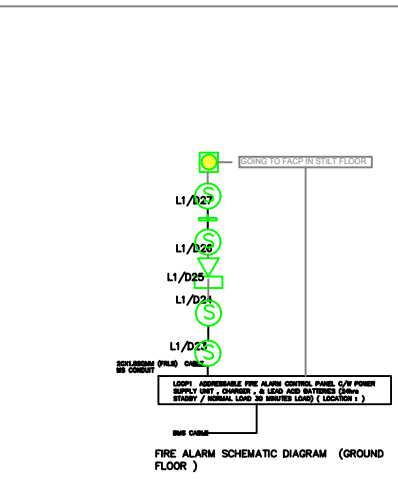

NOTE : All Cable Should be FRLS cable Drawn in MS conduit

GOOD FOR CONSTRUCTION

Issued by: _____
 Issued Date: 03 OCT 2024

REVISION CHART		
	REVISION DATE	REV. NO.
1	15-07-2024	R0
2	24-08-2024	R1
3	09-09-2024	R2
4		

COPYRIGHT POLICY

A-SQUARE MEP Consultants (hereafter referred to as "A-SQUARE") retains all copyright and other proprietary rights to the drawings created by A-SQUARE. All drawings created by A-SQUARE are protected by Indian and international copyright laws. Any unauthorized reproduction, distribution, or modification of A-SQUARE's drawings is strictly prohibited. A-SQUARE reserves the right to take legal action against any unauthorized use of its drawings. A-SQUARE grants clients a limited, non-exclusive, non-transferable license to use the drawings for the specific project or purpose for which they were created. Clients may not use the drawings for any other purpose without the express written consent of A-SQUARE. Clients may not modify, reproduce, distribute, transmit, display, perform, publish, license, create derivative works from, transfer, or sell any of A-SQUARE's drawings without the prior written consent of A-SQUARE. Clients may not use any of A-SQUARE's drawings as a basis for the design or construction of any other project without the express written consent of A-SQUARE. Clients may not disclose any of A-SQUARE's drawings to any third party without the prior written consent of A-SQUARE. kindly visit our web-site, to know more.

ENGINEERING CONSULTANTS:



G-31, CEDAR BUILDING, BRIGADE ORCHARDS, SPINAL ROAD, DEVANAHALLI, BANGALORE-562110
 Email: Support@a-square.group
 Contact No: +91 9845208299
 www.a-sqaure.group

ARCHITECT NAME

INNOBUILD LANDHOLDINGS PVT. LTD
 #460, 17th cross, 4th sector, CS Towers, HSR layout, Bangalore 560102


PROJECT NAME:

ALAKANANDA APARTMENTS AT KAVALI

DRAWING TITLE:

SMOKE LAYOUT

DRWN	CHD	APPD
ASHIK	VIJAY	ALTAF
SCALE	SHEET SIZE	REV.
NTS	A1	R2

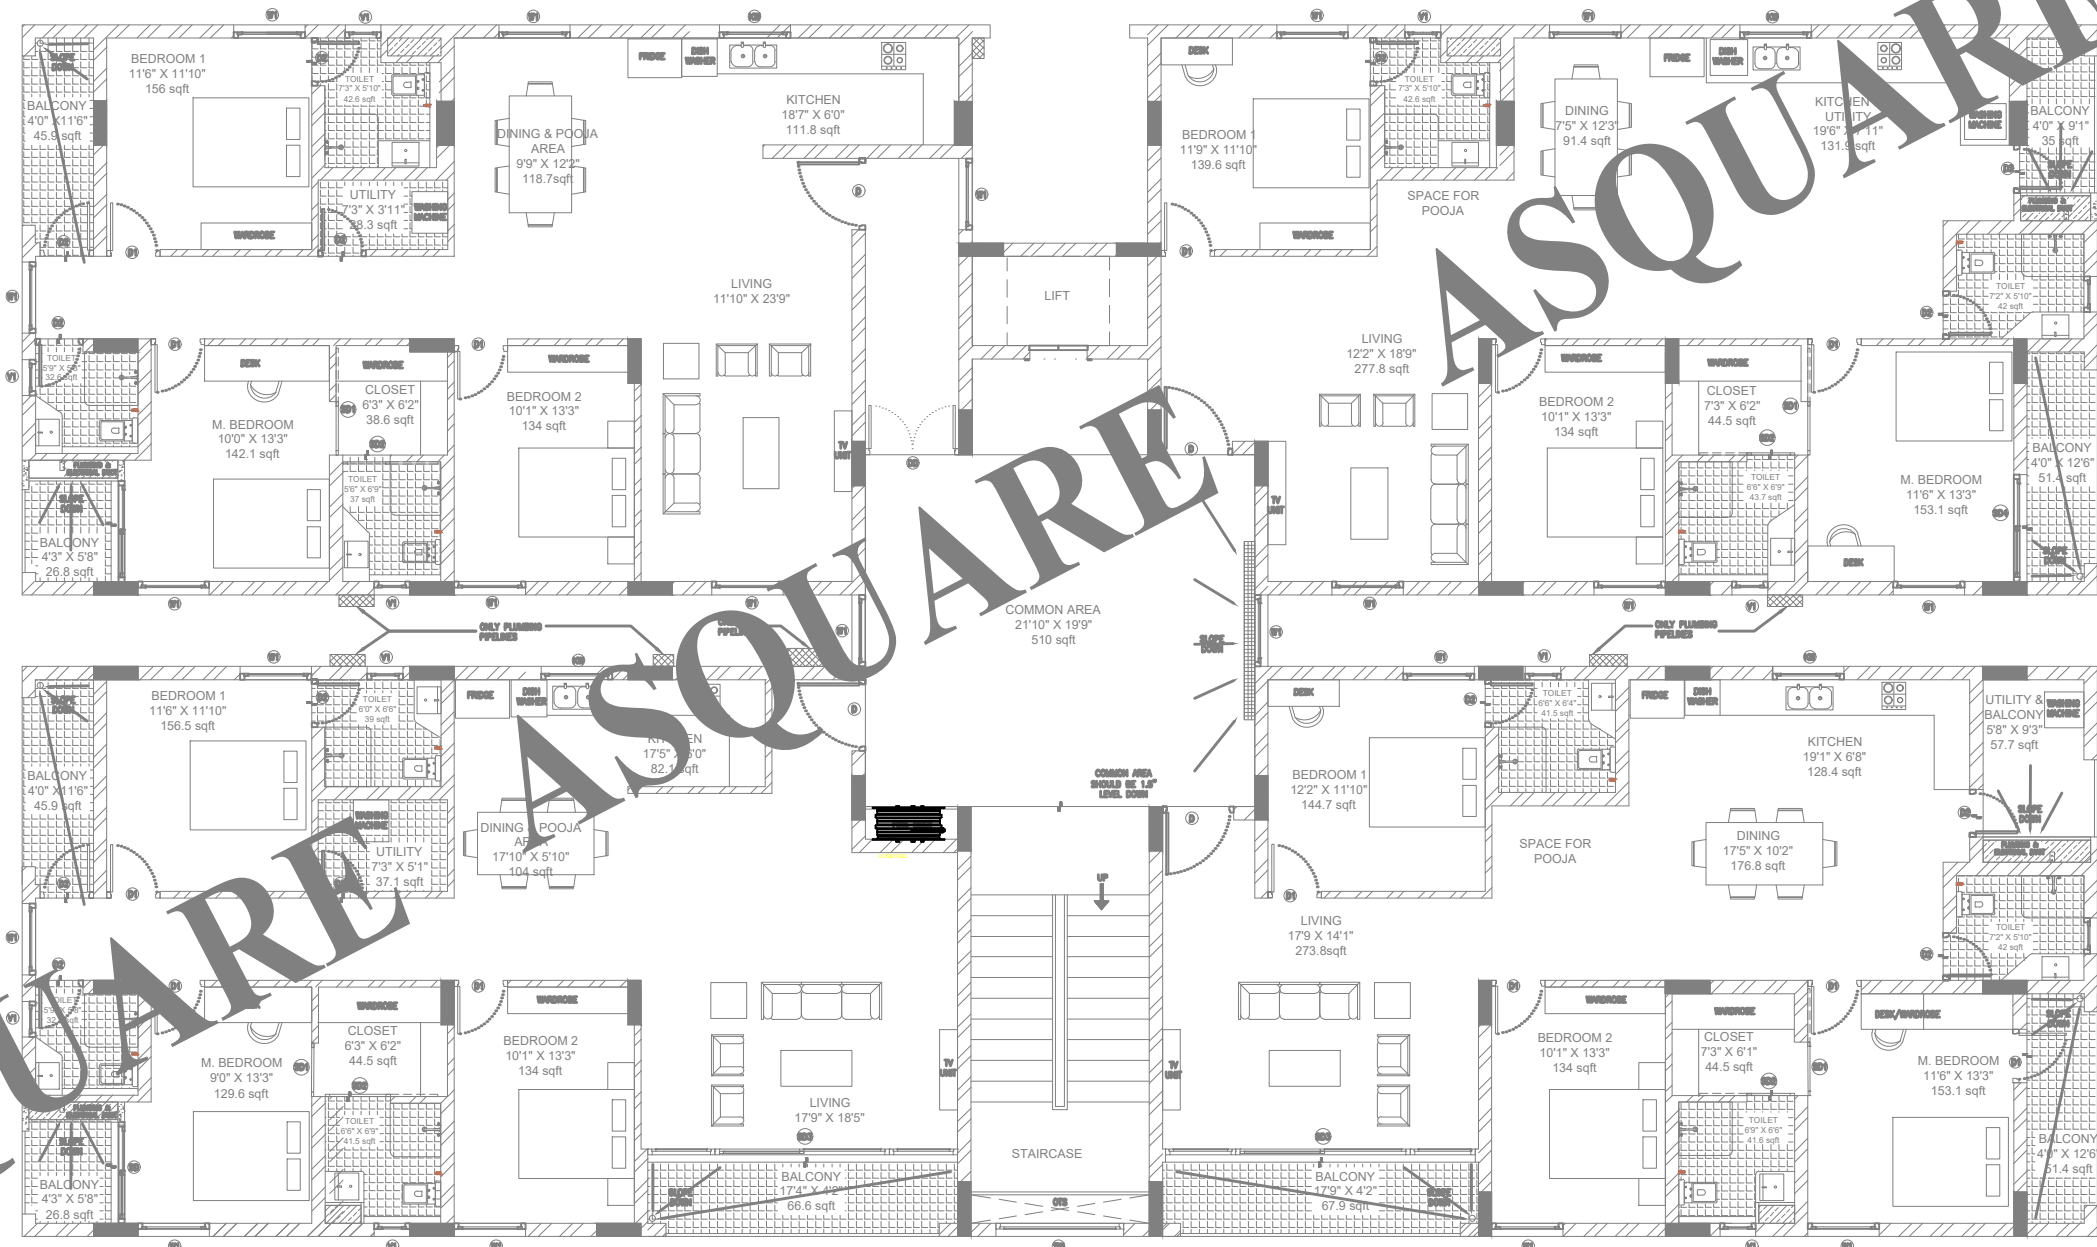

GOOD FOR CONSTRUCTION

Issued by: _____
 Issued Date: 03 OCT 2024

COPYRIGHT POLICY

A-SQUARE MEP Consultants (hereafter referred to as "A-SQUARE") retains all copyright and other proprietary rights to the drawings created by A-SQUARE. All drawings created by A-SQUARE are protected by Indian and international copyright laws. Any unauthorized reproduction, distribution, or modification of A-SQUARE's drawings is strictly prohibited. A-SQUARE reserves the right to take legal action against any unauthorized use of its drawings. A-SQUARE grants clients a limited, non-exclusive, non-transferable license to use the drawings for the specific project or purpose for which they were created. Clients may not use the drawings for any other purpose without the express written consent of A-SQUARE. Clients may not modify, reproduce, distribute, transmit, display, perform, publish, license, create derivative works from, transfer, or sell any of A-SQUARE's drawings without the prior written consent of A-SQUARE. Clients may not use any of A-SQUARE's drawings as a basis for the design or construction of any other project without the express written consent of A-SQUARE. Clients may not disclose any of A-SQUARE's drawings to any third party without the prior written consent of A-SQUARE. kindly visit our web-site, to know more.

ENGINEERING CONSULTANTS:



G-31, CEDAR BUILDING, BRIGADE ORCHARDS, SPINAL ROAD, DEVANAHALLI, BANGALORE-562110
 Email: Support@a-square.group
 Contact No: +91 9845208299
 www.a-square.group

PROJECT NAME:

ALAKANANDA APARTMENTS AT KAVALI

DRWN CHD APPD

VIJAY ALTAF ALTAF

REVISION CHART

	REVISION DATE	REV. NO.
1	15-07-2024	R0
2	24-08-2024	R1
3	03-10-2024	GFC
4		

ARCHITECT NAME


INNOBUILD LANDHOLDINGS PVT. LTD
 #460, 17th cross, 4th sector, CS Towers, HSR layout, Bangalore 560102

DRAWING TITLE:

FIRE LAYOUT
 TYPICAL FLOOR

SCALE SHEET SIZE REV.

NTS A1 R2

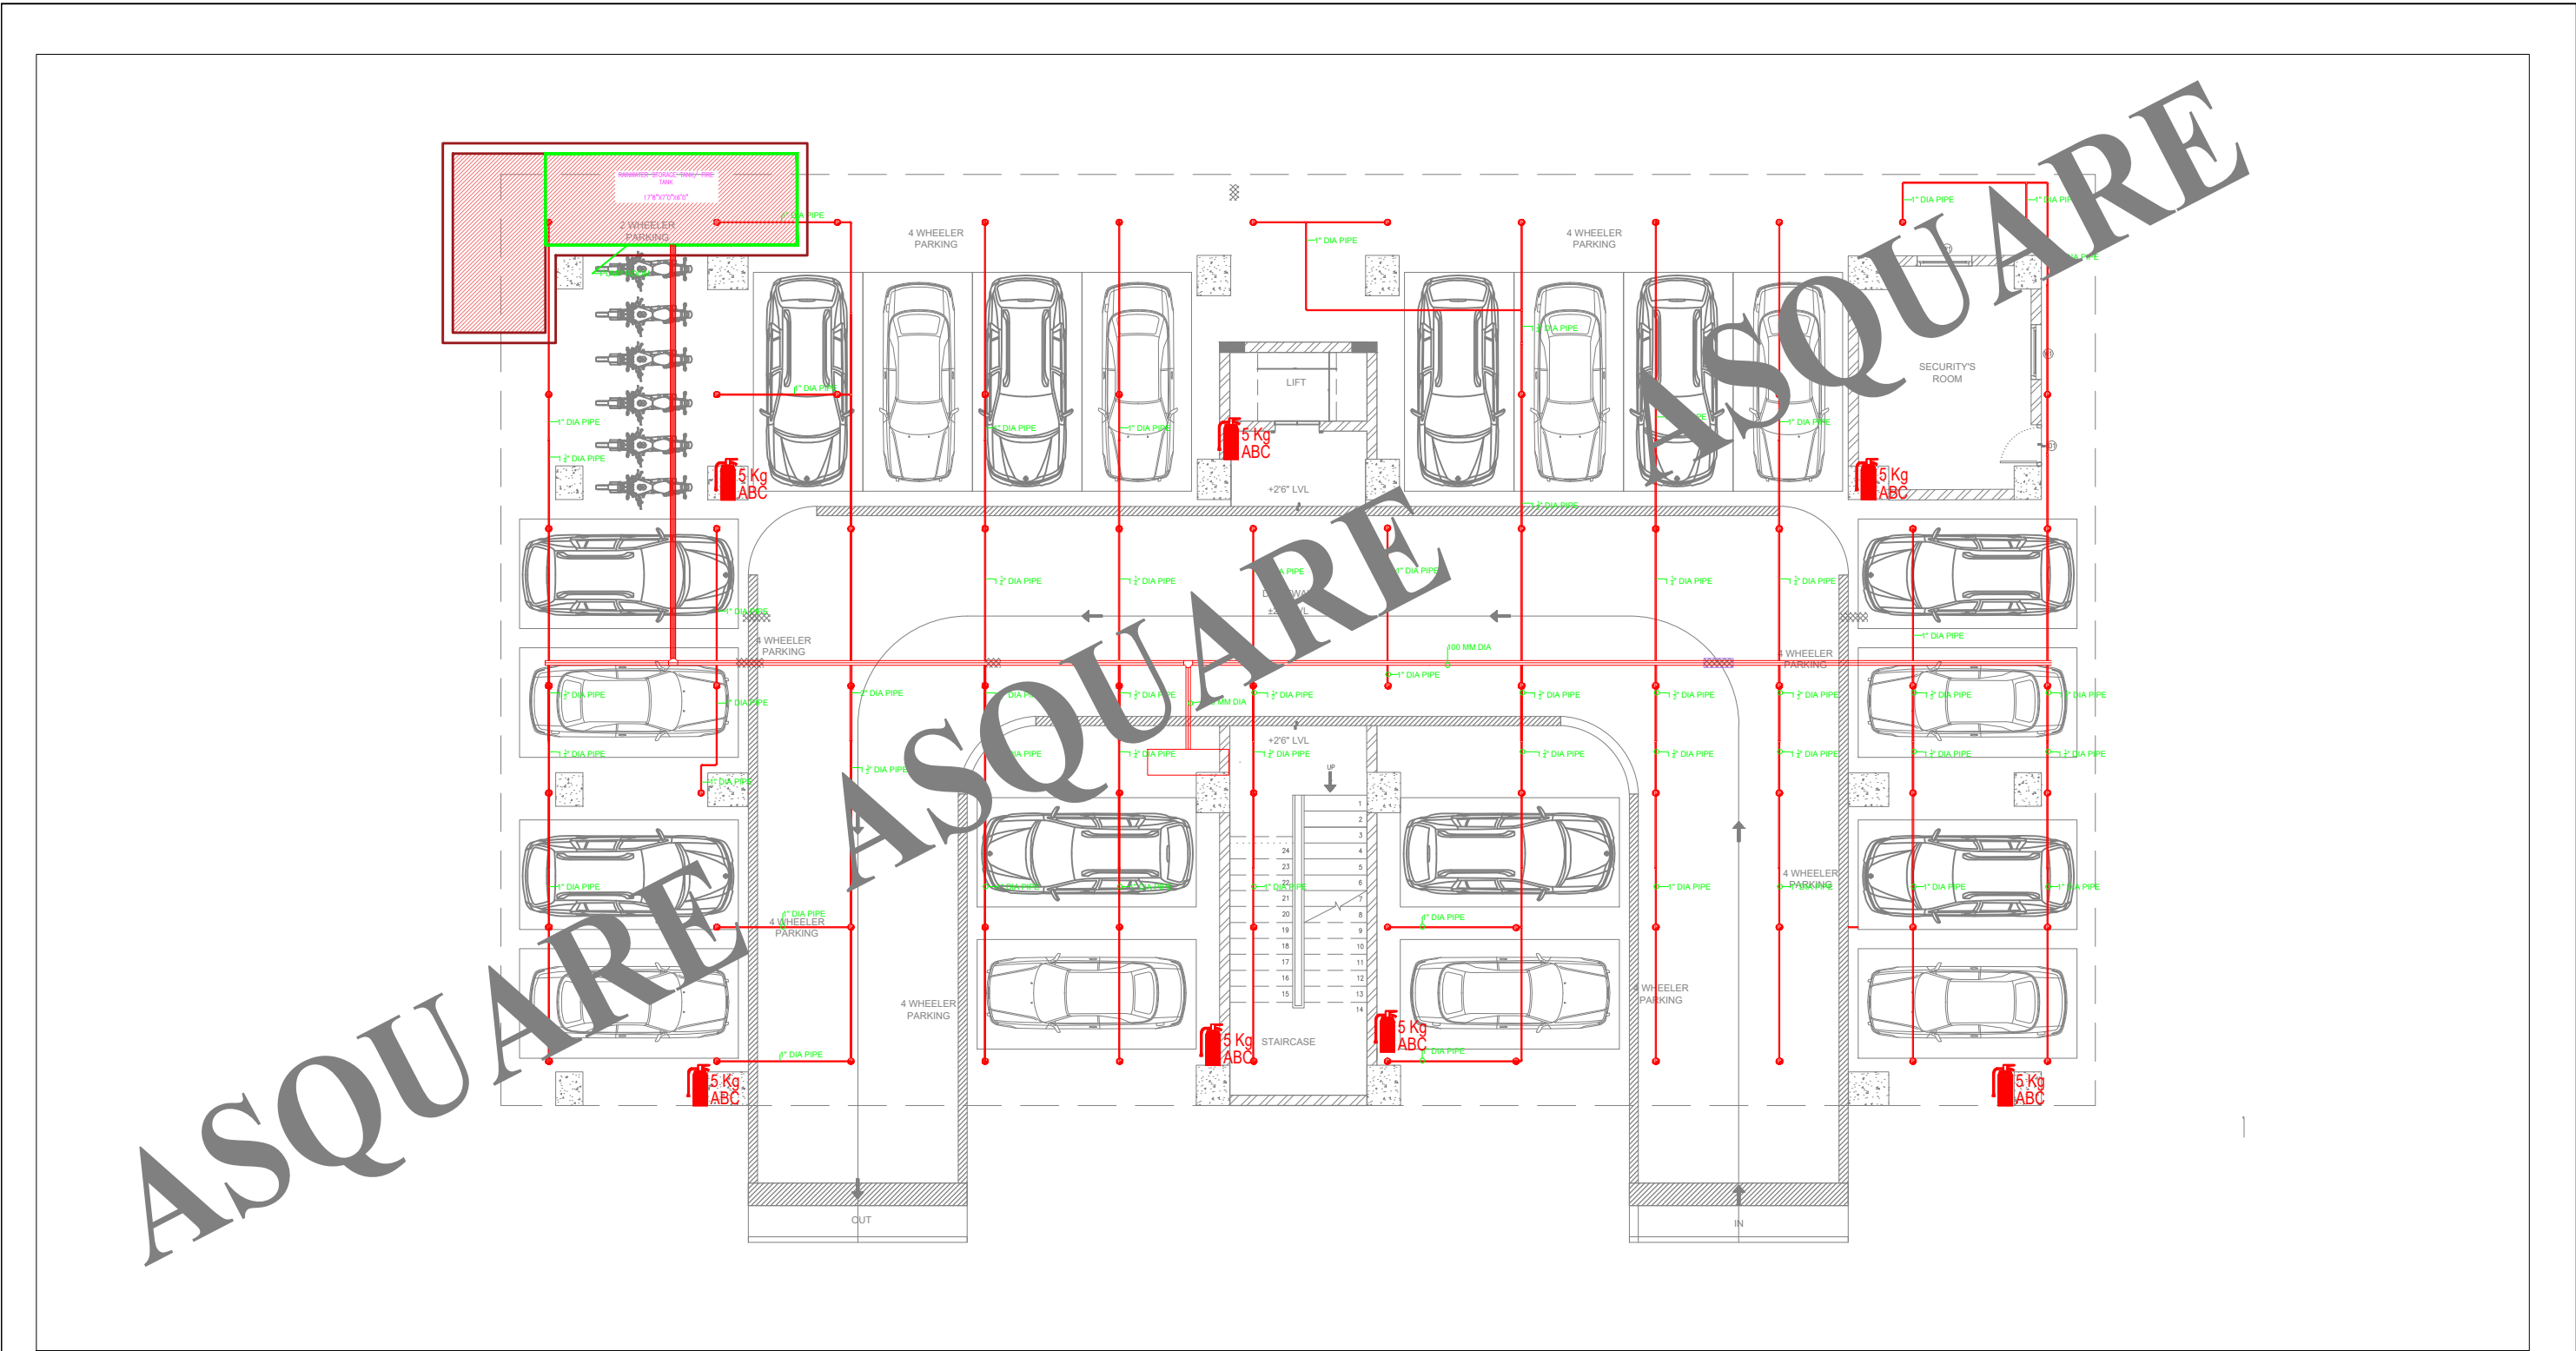

GOOD FOR CONSTRUCTION

Issued by: _____

Issued Date: 03 OCT 2024

COPYRIGHT POLICY

A-SQUARE MEP Consultants (hereafter referred to as "A-SQUARE") retains all copyright and other proprietary rights to the drawings created by A-SQUARE. All drawings created by A-SQUARE are protected by Indian and international copyright laws. Any unauthorized reproduction, distribution, or modification of A-SQUARE's drawings is strictly prohibited. A-SQUARE reserves the right to take legal action against any unauthorized use of its drawings. A-SQUARE grants clients a limited, non-exclusive, non-transferable license to use the drawings for the specific project or purpose for which they were created. Clients may not use the drawings for any other purpose without the express written consent of A-SQUARE. Clients may not modify, reproduce, distribute, transmit, display, perform, publish, license, create derivative works from, transfer, or sell any of A-SQUARE's drawings without the prior written consent of A-SQUARE. Clients may not use any of A-SQUARE's drawings as a basis for the design or construction of any other project without the express written consent of A-SQUARE. Clients may not disclose any of A-SQUARE's drawings to any third party without the prior written consent of A-SQUARE. kindly visit our web-site, to know more.

ENGINEERING CONSULTANTS:



G-31, CEDAR BUILDING, BRIGADE ORCHARDS, SPINAL ROAD, DEVANAHALLI, BANGALORE-562110
 Email: Support@a-square.group
 Contact No: +91 9845208299
 www.a-sqaure.group

PROJECT NAME:

ALAKANANDA APARTMENTS AT KAVALI

DRWN	CHD	APPD
VIJAY	ALTAF	ALTAF

REVISION CHART

	REVISION DATE	REV. NO.
1	15-07-2024	R0
2	24-08-2024	R1
3	03-10-2024	GFC
4		

ARCHITECT NAME

INNOBUILD LANDHOLDINGS PVT. LTD
 #460, 17th cross, 4th sector, CS Towers, HSR layout, Bangalore 560102

DRAWING TITLE:



FIRE LAYOUT
 STILT FLOOR

SCALE	SHEET SIZE	REV.
NTS	A1	R2

A-SQUARE

A-SQUARE

A-SQUARE

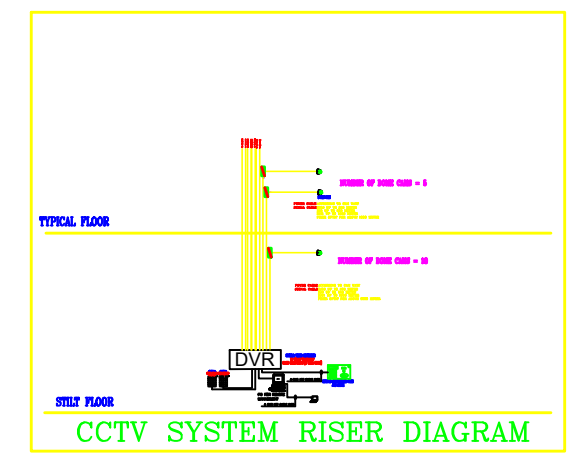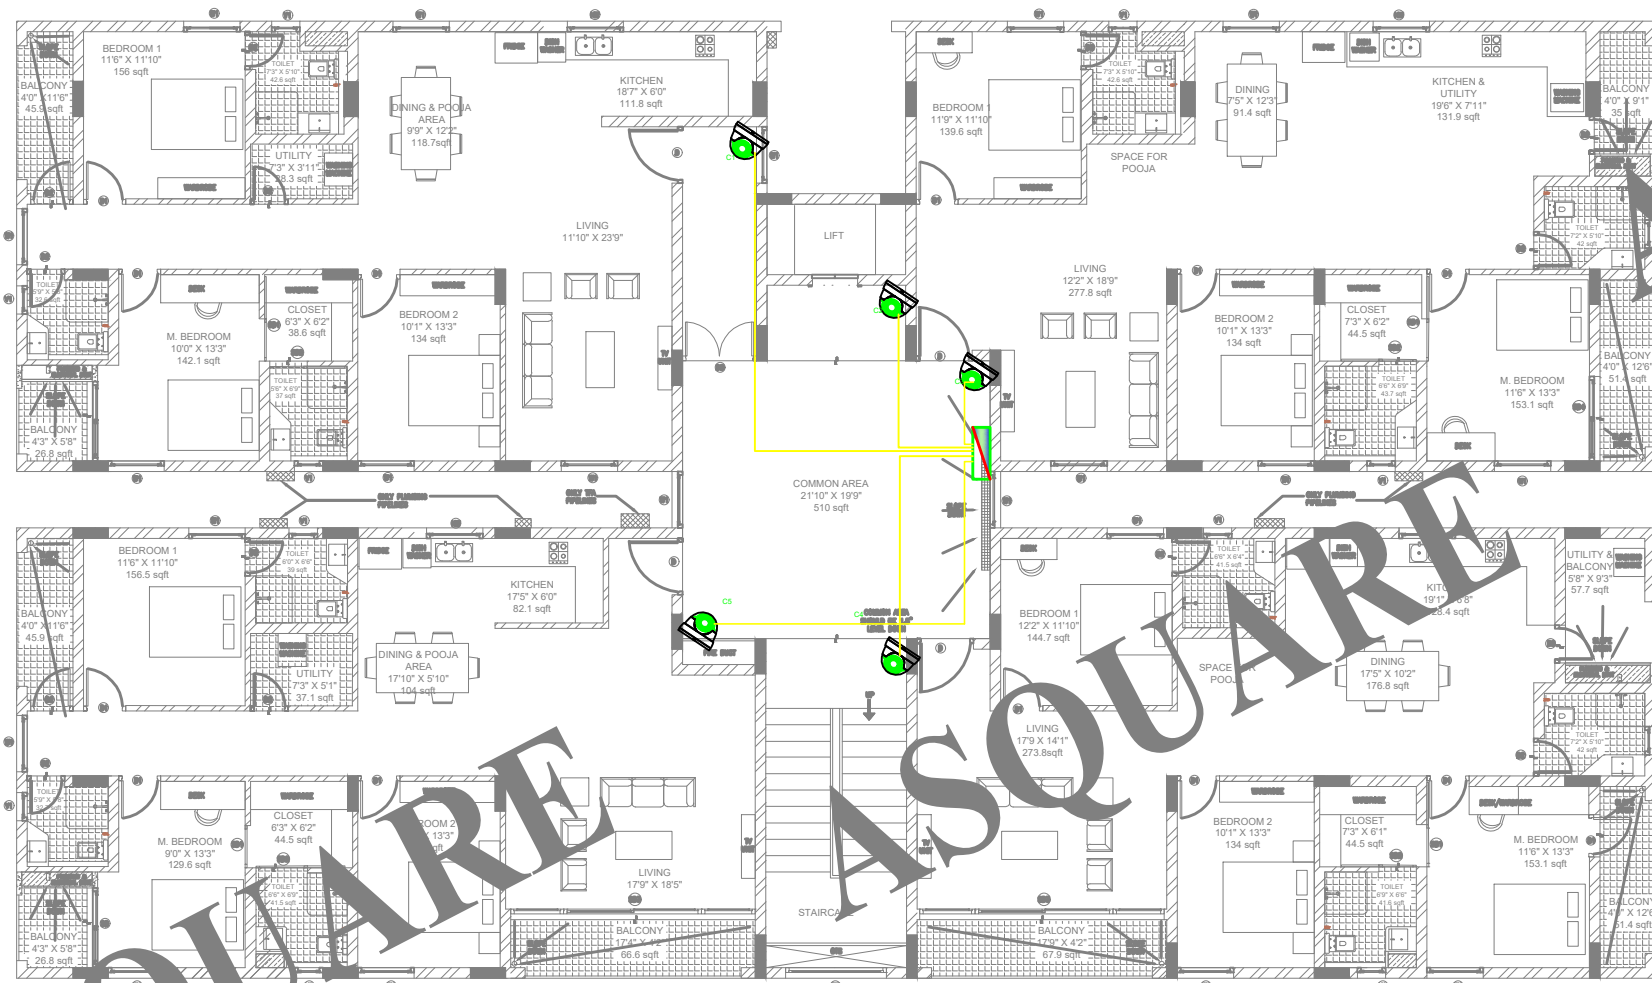

LEGEND	
DOME CAM	
EXTRA LOW VOLTAGE DB	
(KEYPAD CONTROLLER) WITH JOYSTICK	
LCD 21"	
RECORD & SHOW UNIT (DVR)	

NOTE : All Cable Should be FRLS cable Drawn in MS conduit

GOOD FOR CONSTRUCTION

Issued by: _____
 Issued Date: 03 OCT 2024

COPYRIGHT POLICY

A-SQUARE MEP Consultants (hereafter referred to as "A-SQUARE") retains all copyright and other proprietary rights to the drawings created by A-SQUARE. All drawings created by A-SQUARE are protected by Indian and international copyright laws. Any unauthorized reproduction, distribution, or modification of A-SQUARE's drawings is strictly prohibited. A-SQUARE reserves the right to take legal action against any unauthorized use of its drawings. A-SQUARE grants clients a limited, non-exclusive, non-transferable license to use the drawings for the specific project or purpose for which they were created. Clients may not use the drawings for any other purpose without the express written consent of A-SQUARE. Clients may not modify, reproduce, distribute, transmit, display, perform, publish, license, create derivative works from, transfer, or sell any of A-SQUARE's drawings without the prior written consent of A-SQUARE. Clients may not use any of A-SQUARE's drawings as a basis for the design or construction of any other project without the express written consent of A-SQUARE. Clients may not disclose any of A-SQUARE's drawings to any third party without the prior written consent of A-SQUARE. kindly visit our web-site, to know more.

ENGINEERING CONSULTANTS:



G-31, CEDAR BUILDING, BRIGADE ORCHARDS, SPINAL ROAD, DEVANAHALLI, BANGALORE- 562110
 Email: Support@a-square.group
 Contact No: +91 9845208299
 www.a-sqaure.group

PROJECT NAME:

ALAKANANDA APARTMENTS AT KAVALI

DRWN	CHD	APPD
VIJAY	AA	ALTAF

REVISION CHART

	REVISION DATE	REV. NO.
1	15-07-2024	R0
2	24-08-2024	R1
3	09-09-2024	R2
4		

ARCHITECT NAME



INNOBUILD LANDHOLDINGS PVT. LTD
 #460, 17th cross, 4th sector, CS Towers, HSR layout, Bangalore 560102

DRAWING TITLE:

CCTV LAYOUT

SCALE	SHEET SIZE	REV.
NTS	A1	R2

ASQUARE

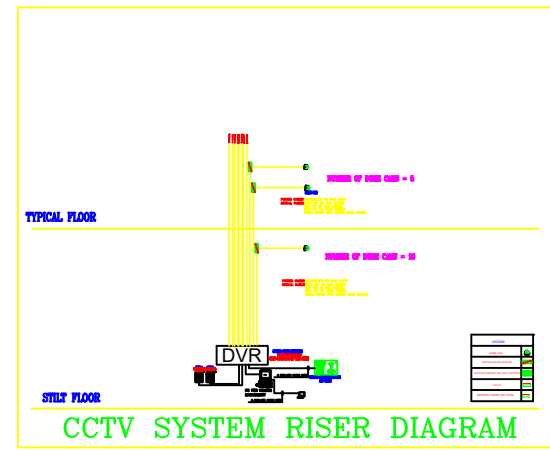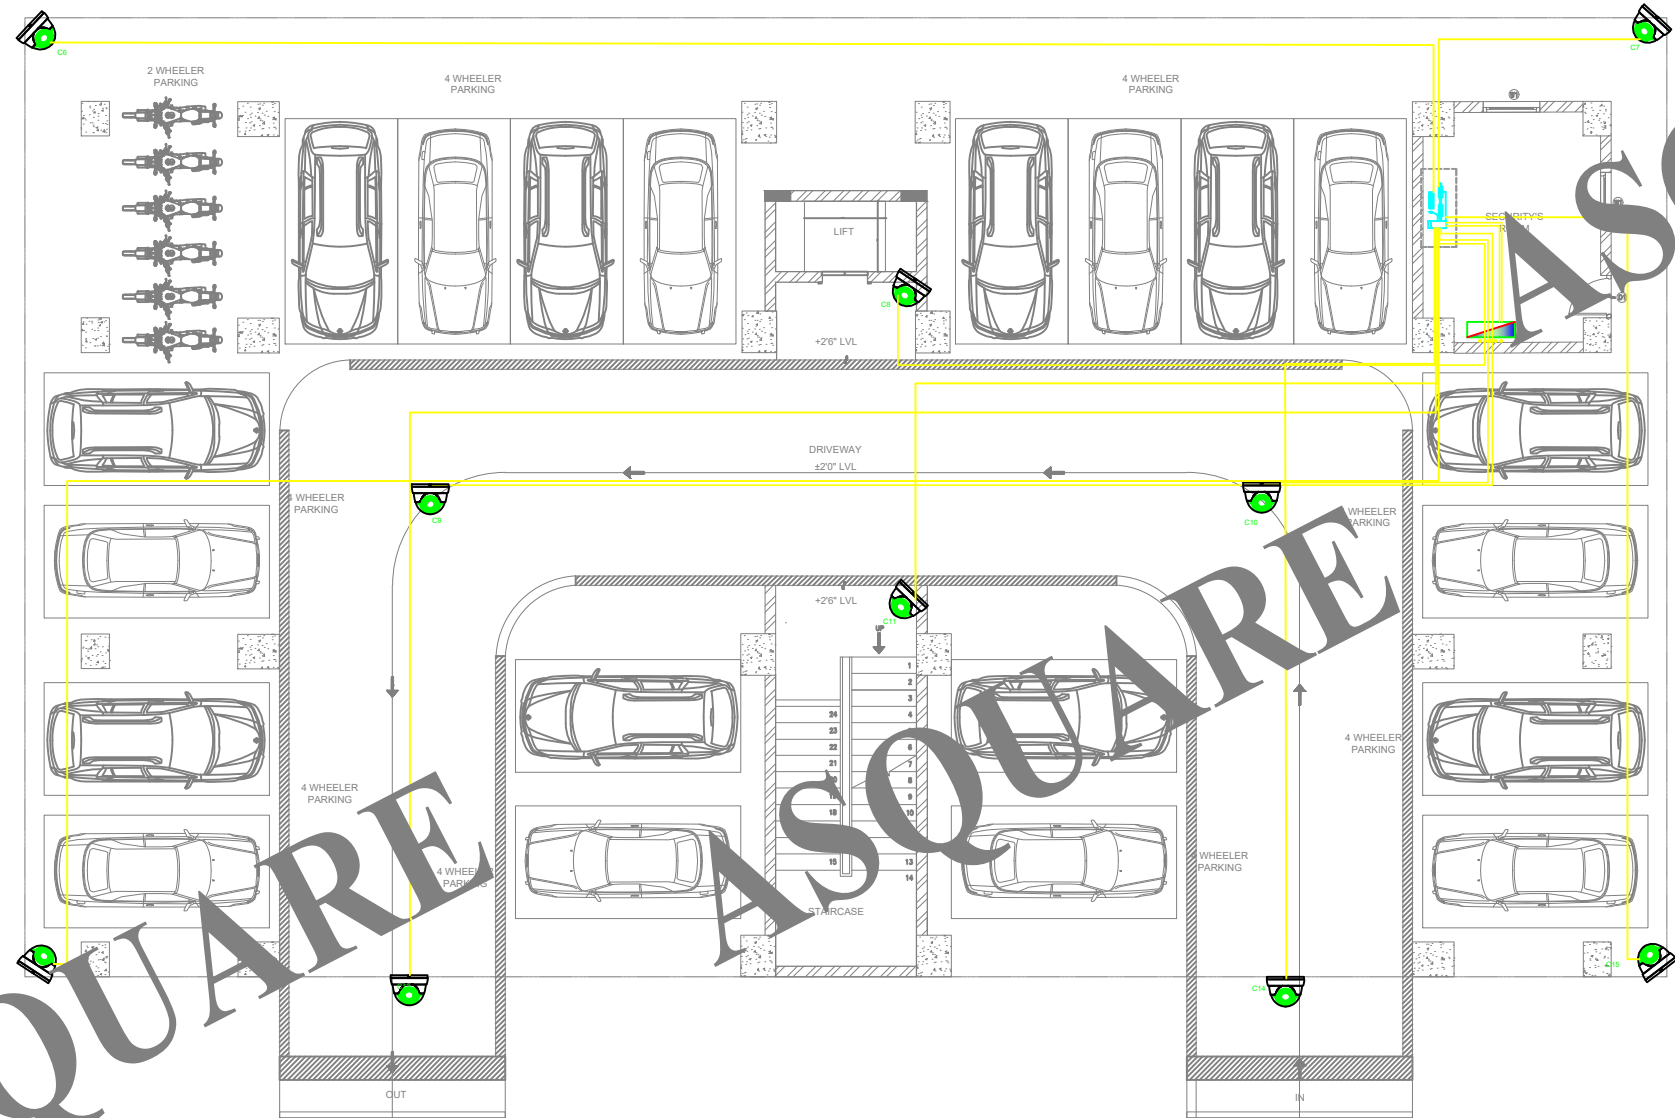

NOTE : All Cable Should be FRLS cable Drawn in MS conduit

GOOD FOR CONSTRUCTION

Issued by: _____
 Issued Date: 03 OCT 2024

COPYRIGHT POLICY

A-SQUARE MEP Consultants (hereafter referred to as "A-SQUARE") retains all copyright and other proprietary rights to the drawings created by A-SQUARE. All drawings created by A-SQUARE are protected by Indian and international copyright laws. Any unauthorized reproduction, distribution, or modification of A-SQUARE's drawings is strictly prohibited. A-SQUARE reserves the right to take legal action against any unauthorized use of its drawings. A-SQUARE grants clients a limited, non-exclusive, non-transferable license to use the drawings for the specific project or purpose for which they were created. Clients may not use the drawings for any other purpose without the express written consent of A-SQUARE. Clients may not modify, reproduce, distribute, transmit, display, perform, publish, license, create derivative works from, transfer, or sell any of A-SQUARE's drawings without the prior written consent of A-SQUARE. Clients may not use any of A-SQUARE's drawings as a basis for the design or construction of any other project without the express written consent of A-SQUARE. Clients may not disclose any of A-SQUARE's drawings to any third party without the prior written consent of A-SQUARE. kindly visit our web-site, to know more.

ENGINEERING CONSULTANTS:



G-31, CEDAR BUILDING, BRIGADE ORCHARDS, SPINAL ROAD, DEVANAHALLI, BANGALORE- 562110
 Email: Support@a-square.group
 Contact No: +91 9845208299
 www.a-square.group

PROJECT NAME:

ALAKANANDA APARTMENTS AT KAVALI

DRWN	CHD	APPD
------	-----	------

VIJAY	AA	ALTAF
-------	----	-------

REVISION CHART

	REVISION DATE	REV. NO.
1	15-07-2024	R0
2	24-08-2024	R1
3	09-09-2024	R2
4		

ARCHITECT NAME

INNOBUILD LANDHOLDINGS PVT. LTD
 #460, 17th cross, 4th sector, CS Towers, HSR layout, Bangalore 560102

DRAWING TITLE:

CCTV LAYOUT

SCALE	SHEET SIZE	REV.
-------	------------	------

NTS	A1	R2
-----	----	----